

# **CALL TO ARTISTS - REQUEST FOR PROPOSALS**

## **MARK & ROBYN JONES COLLEGE OF NURSING CO-OP ROOM PUBLIC ART MONTANA STATE UNIVERSITY**

Bozeman, Montana



Campus Planning, Design & Construction

Montana State University

Physical Plant – 6<sup>th</sup> Avenue & Grant Street

PO Box 172760

Bozeman, MT 59717-2760

**July 2025**

**I. PROJECT SUMMARY**

Montana State University (MSU) wishes to commission a professional artist or artist team to create original art installations at each of MSU's five new Mark & Robyn Jones College of Nursing Buildings. This project seeks to recognize and honor the legacy of Suzie Walking Bear Yellowtail, the first Indigenous registered nurse in the United States from Pryor, Montana. In addition to honoring Yellowtail, the proposed art should reflect broader themes of community, student empowerment, sense of belonging, and the cultural significance of Montana's rural and Indigenous spaces.

**II. PROJECT BACKGROUND**

The Mark & Robyn Jones College of Nursing project will establish five state-of-the-art nursing education facilities in Bozeman, Billings, Great Falls, Kalispell, and Missoula, Montana. The five facilities will create new opportunities and expand existing offerings meeting the contemporary needs to provide high quality nurses to serve all Montanans.

**III. PROJECT LOCATION**

The commissioned art will be located in the each of the five Mark & Robyn College of Nursing building's Co-Op rooms. Please see Attachment A for further details.

**IV. SELECTION PROCESS**

The selection of art will be reviewed by a 6-member committee composed of the university architect, planning manager, 2 members of the Public Art and Artifacts Committee appointed by the committee, 1 Nursing representative, and 1 student representative.

**V. BUDGET**

The maximum public art budget for the Nursing Co-Op Room Public Art is \$25,000.

The Selection Committee through their selection of an artist(s) or artist team for the design, creation, and installation of art procured through this solicitation shall determine how the budget will be utilized, with any remainder being returned to the Art maintenance fund for long term maintenance of the art.

**VI. TIMELINE**

|                             |                                                |
|-----------------------------|------------------------------------------------|
| July 28th, 2025             | Call for Artists (RFP) Posted                  |
| October 2nd, 2025           | Artist Proposals Due                           |
| October 31st, 2025          | Anticipated Selection/Notice to Artists        |
| November 2025 – August 2026 | Installation Period – See Attachment A, page 2 |

## **VII. APPLICATION PROCESS**

### **ART PROPOSAL**

Proposal that summarizes the artwork, creation process and timeline, and installation process and timeline, including any specialized installation requirements shall be provided. Please submit as a PDF file.

### **BUDGET PROPOSAL**

Detailed cost of the proposed pieces, including installation costs, equipment rental, and travel costs if necessary. Please submit as a PDF file.

### **ARTIST STATEMENT**

Statement that addresses the artist's interest in creating art for the Nursing building Co-op rooms, including the relevance and significance of the proposed work to the community. Limit statement to no more than 1,500 words. Please submit as a PDF file.

### **RESUME**

Resume that includes contact information, formal and informal education, exhibitions, inclusion in public and private collections, awards, and/or other information attesting to the artistic quality of the artist. Please submit as a PDF file.

### **ARTIST DOCUMENTATION**

Up to 10 digital images of recent work to provide an overview of the artist's work for the selection committee. No more than 10 total images may be submitted.

#### **Digital images must be:**

1. a JPG file.
2. High resolution digital images (no less than 300 dpi and no more than 600 dpi sized to approximately 5"x7")
3. Labeled with applicant's last name, first name, and image number, e.g., DoeJane1.jpg, DoeJane2.jpg (If you have detail images, keep them in sequence with image of complete work.)

#### **Image detail list:**

A corresponding and consecutively numbered list submitted as a PDF file containing the following information for each documentation image:

1. Number of image (e.g. DoeJane1.jpg)
2. Title of work
3. Medium
4. Dimensions
5. Date of completion

6. **Cost of Design and Installation:** It will be assumed that the inclusion of a purchase price means that the work is available and proposed for sale. If the work is provided as a representative sample and not available for purchase, mark as NFS and do not include price.

## **VIII. CONSIDERATIONS FOR YOUR ARTWORK**

- Art reflects the intentions stated for the installation (Section I).
- Art is appropriate for the scale, fit, and experience of each space as defined in Attachment A.
- Art should promote the MSU Public Art and Artifacts Policy's Mission and Intent
  - The proposed art enriches the educational experience for the MSU community.
  - The proposed art is of a subject matter or provides a message of interest for installation on campus.
  - The proposed art is not out of compliance with any relevant laws.
- **Quality and Presentation**
  - The quality of art refers to the overall accomplishment in the art form and content, and the quality of craftsmanship. Art with its own merit may not be acceptable if they are in contrast with the general aesthetic atmosphere and character of the University.
  - The art must be constructed in a manner that ensures intended longevity. The making of the art should include the use of correct technical processes and materials which have sufficient permanence.
  - Works of art must be presented in a professional manner and demonstrate proficient and practiced art techniques.
  - Works of art must be designed and constructed of durable and appropriate materials.
  - The portfolio of art is of appropriate quality of materials/medium for installation on campus.

## **IX. STUDENT ENGAGEMENT**

As an institute of higher education, MSU values experiential learning and student engagement opportunities with professional artists. If selected, MSU is interested in finding mutually agreeable student engagement opportunities around the vision, creation, and/or installation of your artwork.

## **X. Submission Deadline and Details**

- Please submit all application process items to the following OneDrive link: [Nursing Co-Op Submission](#)
- You may contact Sarah Knoebl, Campus Planner, with any questions regarding this RFP at the following email ([sarah.knoebl@montana.edu](mailto:sarah.knoebl@montana.edu)) or by calling (406)-994-5455

- **All submissions must be received by 5pm MDT on September 11th, 2025**  
Submissions received after this deadline will not be reviewed.

**ATTACHMENT A: MARK & ROBYN JONES COLLEGE OF NURSING CO-OP ROOM PUBLIC ART**

## **TECHNICAL NOTES**

- Proposed art must complement the wallcovering shown on page 3, labeled “SP1” in the included drawings.
- Please see drawings below for architectural details.
- Utilization of the column in the Bozeman location is desired.

## **INSTALLATION NOTES**

- Installation of art must be coordinated with the project manager and construction team at sites still under construction (Bozeman, Billings, Kalispell & Missoula).
- Installation of art must be coordinated with building occupants at sites that have been completed (Great Falls).

## **EXPECTED INSTALLATION TIMEFRAME**

- Great Falls – After October 10<sup>th</sup>, 2025
- Bozeman – After March 20<sup>th</sup>, 2026
- Billings – After May 8<sup>th</sup>, 2026
- Kalispell – After July 7<sup>th</sup>, 2026
- Missoula – After August 18<sup>th</sup>, 2026

\*Installation timeframes for sites still under construction are subject to change.


## **WALLCOVERING**

The wallcovering below will be installed where all site drawings are labeled “SP1”

Product Link: <https://momentumtextilesandwalls.com/products/09238953>





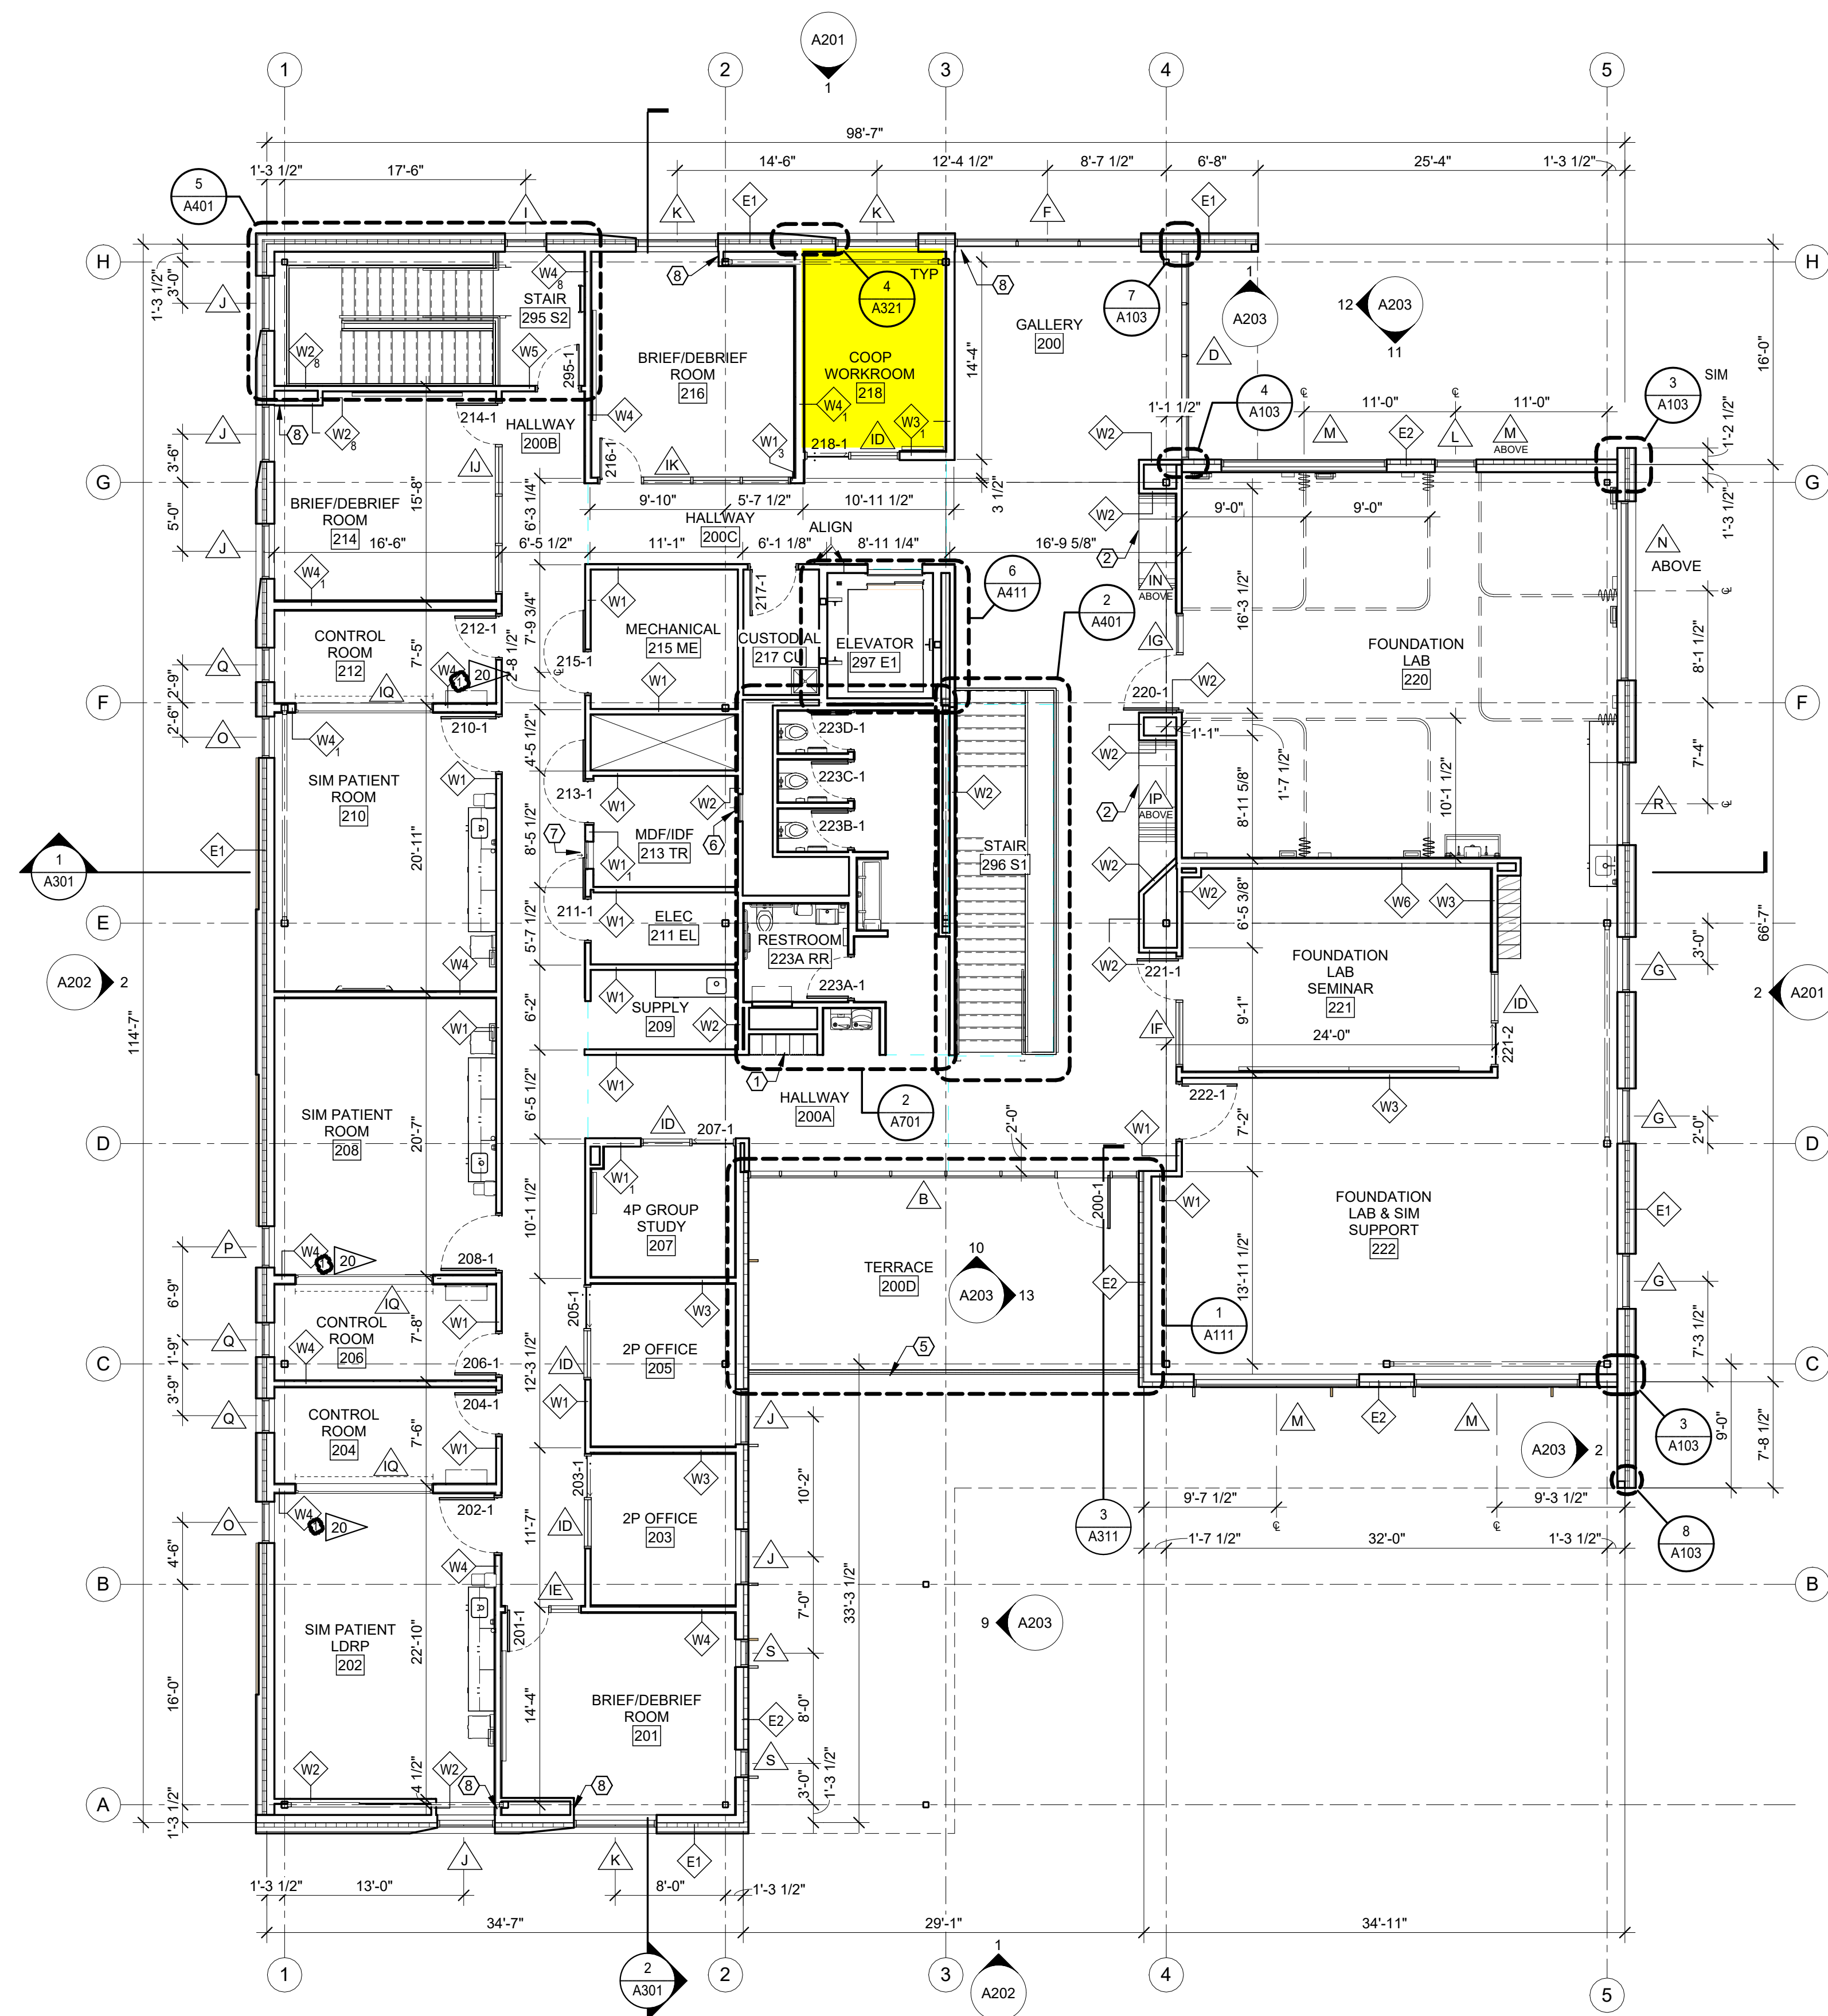

1 SECOND FLOOR PLAN  
A102 1/8" = 1'-0"



## PLAN LEGEND

- W## ASSEMBLY TYPE (SEE ASSEMBLIES SHEET)  
1 ASSEMBLY MODIFIER, PER TYPE  
NAME ROOM NAME AND NUMBER  
X WINDOW TYPE (SEE A600s)  
X KEYNOTE  
SIM DIRECTION OF VIEW, IF APPLICABLE  
1 DRAWING NUMBER  
X000 SHEET WHERE DRAWN  
101-1 DOOR NUMBER (SEE SHEET A601)  
DIMENSION TO FACE OF FRAMING  
DIMENSION TO GRID LINE  
DIMENSION TO CENTER LINE

## GENERAL PLAN NOTES

- A. SEE A500 SHEETS FOR ALL FINISH REQUIREMENTS.  
B. SEE A600 SHEETS FOR WINDOW AND DOOR SCHEDULES.  
C. SEE A700 SHEETS FOR INTERIOR ELEVATIONS.  
D. COORDINATE WITH BUILDING SECTIONS AND STRUCTURAL DRAWINGS FOR FINISH FLOOR ELEVATIONS.  
E. SEE G100 SHEETS REGARDING BUILDING CODE REQUIREMENTS.  
F. SEE SHEET A002 FOR TYPICAL EXTERIOR AND INTERIOR WALL TYPE ASSEMBLIES.  
G. SEE A900 SHEETS FOR REFLECTED CEILING PLANS AND DETAILS.  
H. PROVIDE BLOCKING IN WALL FOR ALL MOUNTED EQUIPMENT, MILLWORK, AND HARDWARE.  
I. FIELD VERIFY ALL CASEWORK AND BUILT IN COMPONENTS PRIOR TO FABRICATION.  
J. COORDINATE ALL PLUMBING FIXTURES LOCATIONS WITH PLUMBING DRAWINGS.  
K. DIMENSIONS OF EXTERIOR WALL ARE TO FACE OF STUD (UNLESS NOTED OTHERWISE).

## KEYNOTES


- 1 BUILT-IN LOCKERS  
2 CUSTOM BUILT-IN SEAT & TABLE NOOK A803  
3 NOT USED  
4 NOT USED  
5 METAL GUARDRAIL. SEE 1/A402 FOR DETAIL. SAME AS STAIR 1 GUARDRAIL.  
6 24"x48" ACCESS PANEL, MOUNT FLUSH WITHIN WALL 6" ABOVE FINISH FLOOR, PAINT TO MATCH ADJACENT WALL.  
7 24"x24" ACCESS PANEL, MOUNT FLUSH WITHIN WALL 5' TO CENTERLINE OF PANEL, PAINT TO MATCH ADJACENT WALL.  
8 WALL TO ALIGN WITH OPENING PER 8/A103.

BUILDING PERMIT SET

MARK & ROBYN JONES COLLEGE  
OF NURSING - GREAT FALLS  
MONTANA STATE UNIVERSITY

Cushing  
Terrell  
ARCHITECTS

|              |                |          |
|--------------|----------------|----------|
| DRAWN BY:    |                | TS       |
| REVIEWED BY: |                | KN       |
| REV.         | DESCRIPTION    | DATE     |
| 4            | CITY COMMENT 1 | 05.03.24 |
| 7            | PR-04          | 07.17.24 |
| 9            | PR-06          | 07.17.24 |
| 16           | PR-12          | 10.22.24 |
| 20           | PR-16          | 11.21.24 |

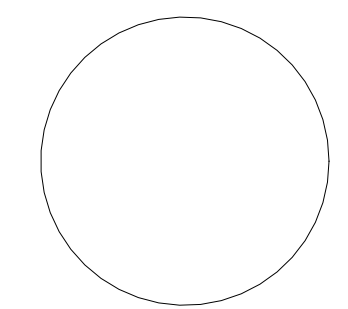

PPA#21-0170


A/E#: 2022-02-09-02

SHEET TITLE  
SECOND FLOOR PLAN

SHEET  
A102

DATE  
03.08.2024



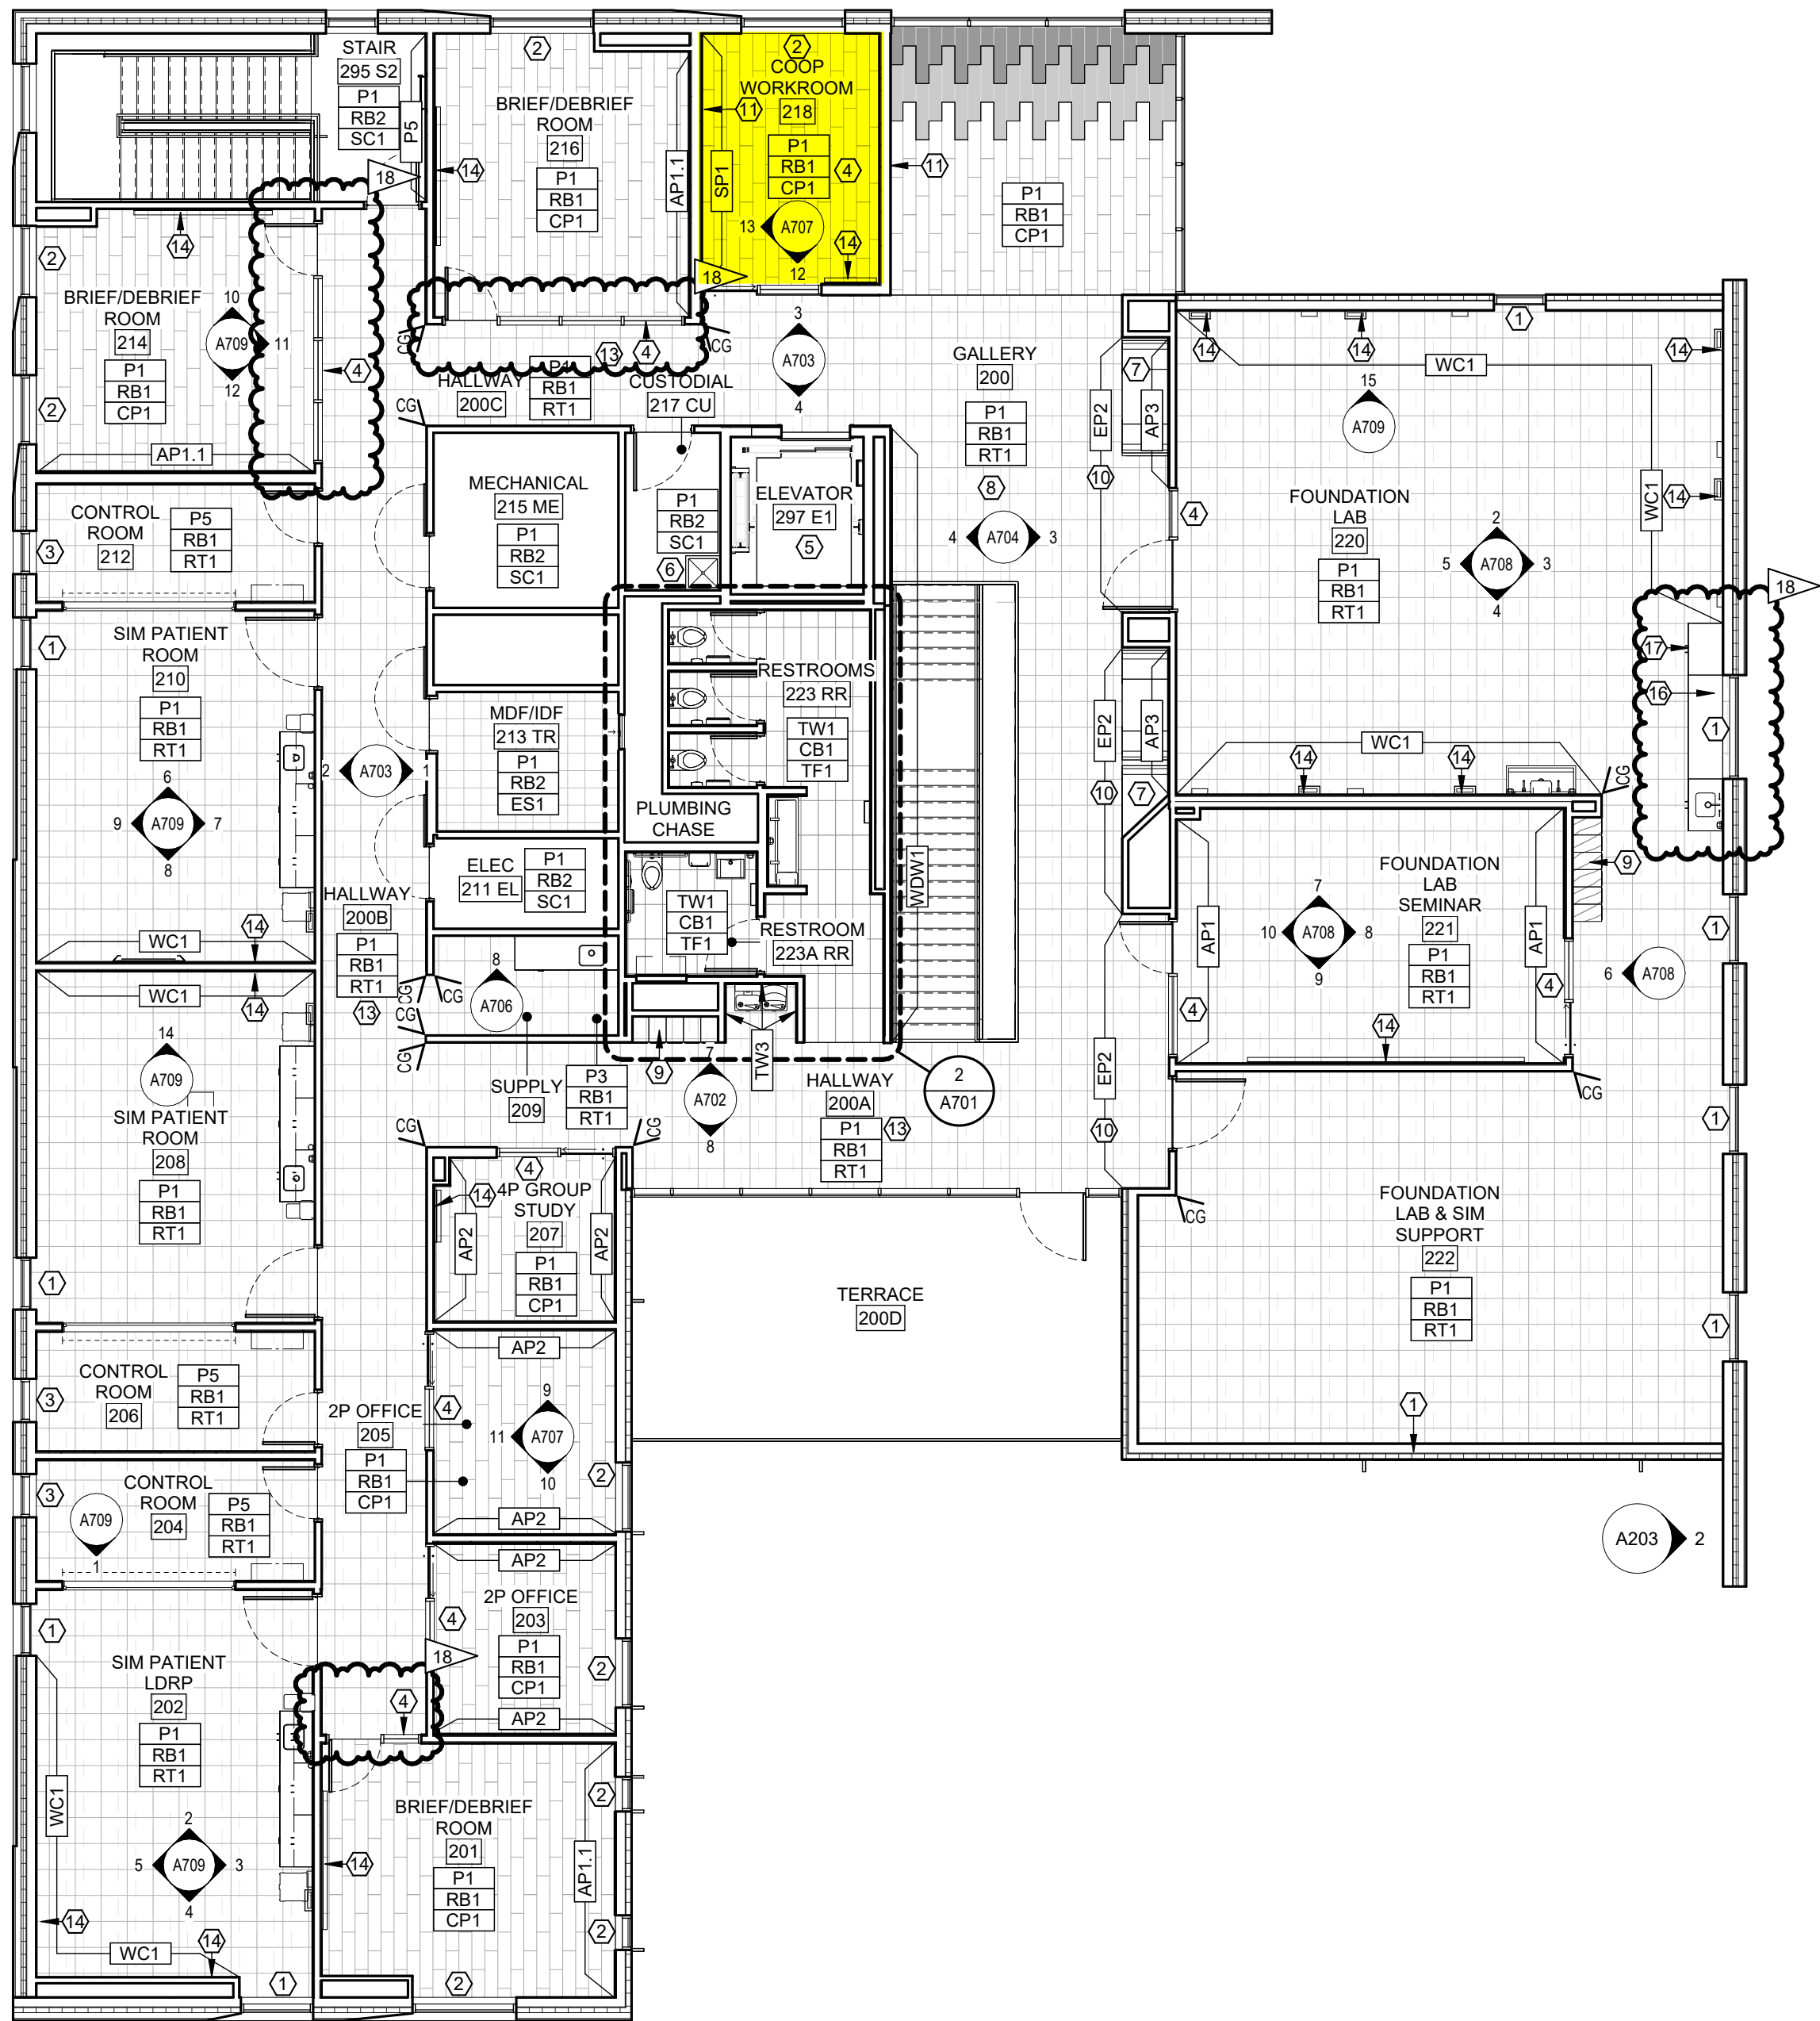

1 SECOND FLOOR FINISH PLAN  
A502 1/8" = 1'-0"

FINISH PLAN LEGEND

NAME  
101 ROOM NAME AND NUMBER

(A8#) # INTERIOR ELEVATION CALLOUT AND DIRECTION OF ELEVATION VIEW

XX### FINISH TAG

XX### EXTENT OF ACCENT PAINT OR WALL FINISHES

FINISH TAGS DISPLAYED IN GROUPING ON FINISH PLAN REPRESENT MAJORITY ROOM FINISH SELECTIONS. ORDER OF GROUPING DEFINED IN EXAMPLE BELOW:

XX### MAJORITY WALL FINISH  
XX### MAJORITY BASE FINISH  
XX### MAJORITY FLOOR FINISH

CG LOCATION AND TYPE OF CORNER GUARDS 'CG1'

FLOOR FINISH 'CP1' FLOOR FINISH 'ES1'  
FLOOR FINISH 'CP2' FLOOR FINISH 'RT1'  
FLOOR FINISH 'CP3' FLOOR FINISH 'TF1'  
FLOOR FINISH 'EM1' FLOOR FINISH 'TF2'  
FLOOR FINISH 'EM2'

GENERAL FINISH NOTES

- A. VERIFY ALL CONDITIONS AND DIMENSIONS IN FIELD PRIOR TO FABRICATION.
- B. ALL PRODUCTS ARE TO BE INSTALLED PER MANUFACTURER'S INSTRUCTIONS, USING MANUFACTURER'S ADHESIVES, TOOLS, AND METHODS.
- C. REFER TO SPECIFICATIONS AND MATERIAL FINISH LIST FOR ALL MATERIAL PRODUCT INFORMATION.
- D. FOR INTERIOR ELEVATIONS AND ADDITIONAL FINISHES, RE: A700'S.
- E. FOR CEILING HEIGHTS AND ADDITIONAL FINISHES RE: A800'S.
- F. COORDINATE ALL OWNER FURNISHED EQUIPMENT, ACCESSORIES, AND FURNITURE WITH OWNER AND/OR OWNER'S VENDOR.
- G. ALL FLOOR TRANSITIONS ARE TO OCCUR DIRECTLY BENEATH DOORS OR CENTERED IN OPENINGS. TRANSITIONS ARE TO BE ADA COMPLIANT.
- H. REFER TO FINISH PLAN FOR LOCATION OF CORNER GUARDS. INSTALL AT TOP OF WALL BASE.
- I. ALL GYPSUM WALLS TO BE PAINTED 'P1' UNLESS OTHERWISE NOTED.
- J. ALL GYPSUM CEILINGS AND SOFFITS TO BE PAINTED 'P1' UNLESS OTHERWISE NOTED ON REFLECTED CEILING PLAN.
- K. ALL WALL BASE TO BE 'RB1' UNLESS OTHERWISE NOTED.
- L. ALL HOLLOW METAL FRAMES TO BE PAINTED BLACK IN SEMI-GLOSS FINISH, UNLESS OTHERWISE NOTED.
- M. ALL METAL ACCESS PANELS, COVER PLATES, VENTS, AND GRILLES TO BE PAINTED TO MATCH THE SURFACE IT IS LOCATED ON.
- N. ALL QUARTZ AND SOLID SURFACE COUNTERTOPS TO HAVE EASED EDGES. ADJACENT BACKSPLASH TO MATCH, UNLESS OTHERWISE NOTED.
- O. ALL WINDOW TREATMENTS ARE TO BE FIELD MEASURED, INSTALLED WITH ALL COMPONENTS, AND INSIDE MOUNTED, UNLESS OTHERWISE NOTED.
- P. ALL WALLS TO RECEIVE CUSTOM GRAPHIC TO HAVE A LEVEL 5 GYP FINISH.
- Q. ALL LEARNING STUDIOS, LABS, CONFERENCE ROOMS, AND OFFICES TO RECEIVE 'WH1' WHITEBOARD. REFER TO MATERIAL FINISH LIST FOR PRODUCT SPECIFICATIONS AND ELEVATIONS FOR SIZING.
- R. FOR ALL FLOORING AND WALL TRANSITIONS REFER TO MATERIAL FINISH LIST FOR PRODUCT SPECIFICATIONS. GC IS RESPONSIBLE TO PROVIDE THE CORRECT SIZING FOR TRANSITIONS.
- S. SEE RCP FOR PAINTED DRYFALL SYSTEM AND ACOUSTIC SPRAY SYSTEM.
- T. PAINT ALL EXPOSED STRUCTURAL STEEL COLUMNS, CROSS BRACING, ETC. WITH 'P1' SEMI-GLOSS FINISH, UNLESS NOTED OTHERWISE.

# KEYNOTES

1. MOTORIZED AND CONTROLLED ROLLER SHADES 'WS1' TO BE INSTALLED ON EXTERIOR WINDOWS IN THIS ROOM. COORDINATE POWER AND AUTOMATION WITH ELECTRICAL.
2. MANUAL ROLLER SHADES 'WS2' ON EXTERIOR WINDOWS IN THIS ROOM.
3. MANUAL ROLLER SHADES 'WS3' ON EXTERIOR WINDOWS IN THIS ROOM.
4. INSTALL PRIVACY WINDOW FILM 'WF1' ON GLAZING IN THIS ROOM. REFER TO MATERIAL FINISH LIST FOR PRODUCT SPECIFICATIONS. REFER TO DOOR SCHEDULE FOR MOUNTING HEIGHTS. AT LOCATIONS INDICATED, INSTALL FILM ON CORRIDOR SIDE OF GLASS.
5. ELEVATOR CAB FINISHES TO BE SELECTED BY ARCHITECT FROM VENDORS FULL RANGE, INCLUDING WALL AND CEILING PANELS, HAND RAILS, AND FLOORING.
6. INSTALL 'FRP1' ON ALL WALLS IN THIS ROOM. 4FT HIGH TO START AT TOP OF BASE.
7. CUSTOM BOOTH SEATING AND TABLES. SEE ELEVATIONS, RENDERINGS AND DETAILS FOR CONSTRUCTION AND DESIGN INTENT. REFER TO MATERIAL FINISH LIST FOR UPHOLSTERY.
8. SEE ISOMETRICS, ELEVATIONS, RENDERINGS FOR DESIGN AND MATERIAL INTENT.
9. SEE MATERIAL FINISH LIST 'LK1' / 'LK1.1' FOR LOCKER OR CUBBY SPECIFICATION. VENDOR PROVIDED. VENDOR INSTALLED.
10. ALL WALLS WITHIN ALCOVE TO BE PAINTED WITH 'EP2'.
11. LEVEL 5 WALL FINISH FOR FUTURE ART INSTALLATION.
12. INSTALL 'WP1' ON ALL WALLS IN THIS ROOM. 4FT HIGH TO START AT TOP OF FINISHED FLOOR. INSTALL WALL BASE ON TOP OF WP#.
13. WHITEBOARD LOCATED ON THIS WALL. REFER TO MATERIAL FINISH LIST FOR PRODUCT SPECIFICATIONS AND ELEVATIONS FOR SIZING.
14. COORDINATE GROMMET LOCATION WITH AV DRAWINGS. CUT IN FIELD. PROVIDE COVER INSERT.
15. COORDINATE VENTING REQUIREMENTS FOR AV EQUIPMENT HOUSED IN LOWER CABINET. CABINET TO PROVIDE POWER CONNECTION OR ROUTE TO POWER CONNECTION.

**MONTANA STATE UNIVERSITY**

**MARK & ROBYN JONES COLLEGE OF NURSING - GREAT FALLS**

**MONTANA STATE UNIVERSITY**

**BUILDING PERMIT SET**

**Cushing Terrell**

**co ARCHITECTS**

| DRAWN    | LD          |               |
|----------|-------------|---------------|
| REVIEWED | MH          |               |
| REV      | DESCRIPTION | DATE          |
| 3        | ADD-03      | 04.16.24      |
| 9        | PR-06       | 07.17.24      |
| 15       | PR-11       | 10.01.24      |
| 18       | PR-14       | Date 10.26.24 |

PPA#21-0170

A/E# 2022-02-09-02

**SHEET TITLE**

**SECOND FLOOR FINISH PLAN**

**SHEET**

**A502**

**DATE**

**03.08.2024**



GENERAL INTERIOR ELEVATION NOTES

A. A. SEE A701 FOR TOILET AND LAV ACCESSORY SCHEDULE.  
B. SEE A503 FOR MATERIAL/FINISH ABBREVIATION LIST.  
C. PAINT ALL EXPOSED STRUCTURAL STEEL COLUMNS, CROSS BRACING, ETC. WITH 'P1' SEMI-GLOSS FINISH, UNLESS NOTED OTHERWISE.

KEYNOTES


- MODULAR CASEWORK: GC TO COORDINATE, VENDOR PROVIDED, VENDOR INSTALLED. SEE SHEET A801 AND MATERIAL FINISH LIST FOR PRODUCT SPECIFICATIONS. LABS & CLINICAL CASEWORK TO HAVE UNDERCABINET LIGHTING ALSO PROVIDED BY MODULAR CASEWORK VENDOR. COORDINATE WITH ELECTRICAL.
- FAUCET BY GC/PLUMBING SUB. COORDINATE WITH MODULAR CASEWORK VENDOR FOR INSTALLATION DIMENSIONS.
- AV MONITOR. REFER TO AV DRAWINGS FOR MOUNTING HEIGHTS.
- EQUIPMENT NIC. REFER TO ELECTRICAL AND MECHANICAL PLANS FOR CONNECTIONS AND HEAT LOADS.



**MARK & ROBYN JONES COLLEGE  
OF NURSING - GREAT FALLS**  
MONTANA STATE UNIVERSITY

**Cushing  
Terrell**  
ARCHITECTS

|              |             |         |
|--------------|-------------|---------|
| DRAWN BY:    |             | LD      |
| REVIEWED BY: |             | MH      |
| REV.         | DESCRIPTION | DATE    |
| 1            | ADD-01      | 04.01.2 |
| 3            | ADD-03      | 04.16.2 |
|              |             |         |
|              |             |         |

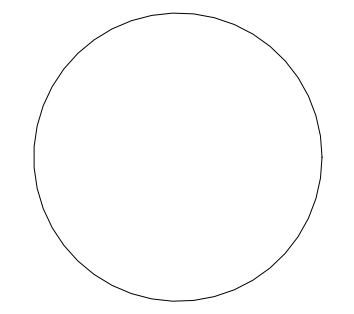

PPA#21-0170


A/E#: 2022-02-09-02

**SHEET TITLE**  
INTERIOR ELEVATIONS


**SHEET**  
**A707**

**DATE**  
**03.08.2024**


BUILDING PERMIT SET

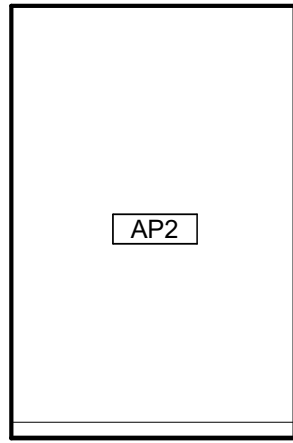


1 TYP. PRIVATE MEET - NORTH  
A707 1/4" = 1'-0"

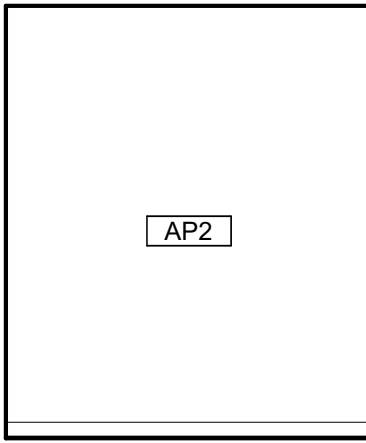


2 TYP. PRIVATE MEET - EAST  
A707 1/4" = 1'-0"

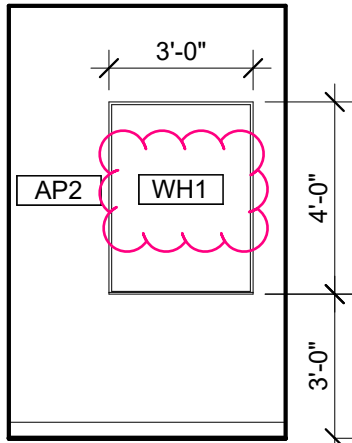


3 TYP. PRIVATE MEET - SOUTH  
A707 1/4" = 1'-0"

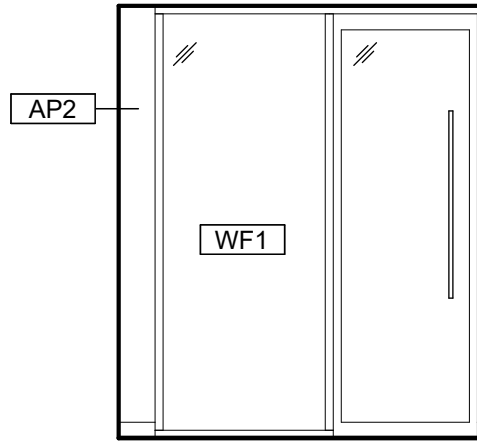


4 TYP. PRIVATE MEET - WEST  
A707 1/4" = 1'-0"

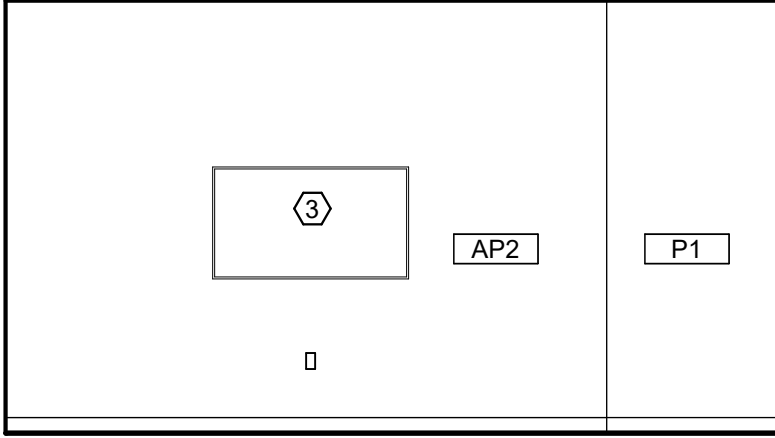


5 TYP. 4P GROUP STUDY - NORTH  
A707 1/4" = 1'-0"

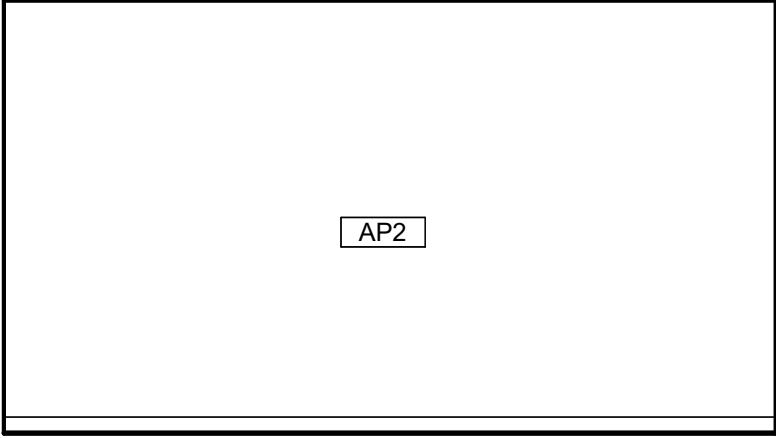


6 TYP. 4P GROUP STUDY - SOUTH  
A707 1/4" = 1'-0"

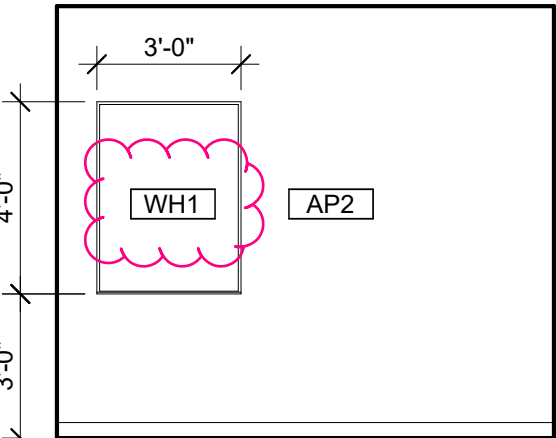


7 TYP. PRIVATE OFFICE - WEST  
A707 1/4" = 1'-0"

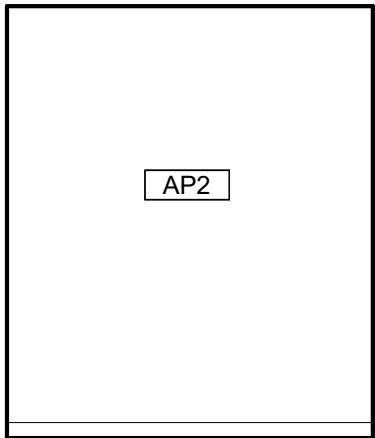


8 TYP. PRIVATE OFFICE - NORTH  
A707 1/4" = 1'-0"

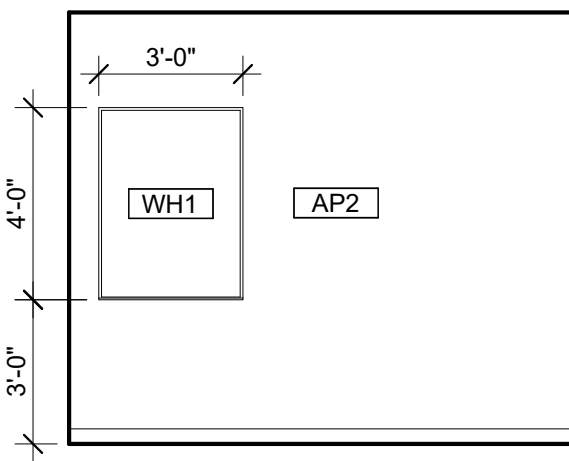


9 TYP. 2P OFFICE - NORTH  
A707 1/4" = 1'-0"

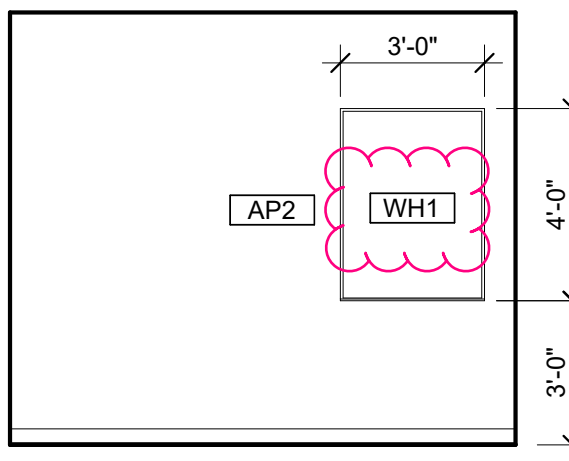


10 TYP. 2P OFFICE - SOUTH  
A707 1/4" = 1'-0"

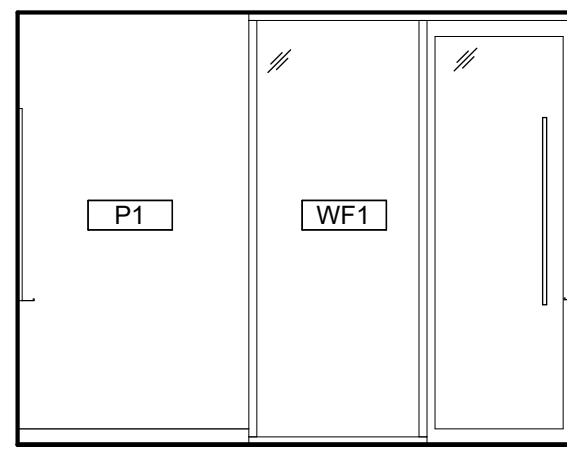


11 TYP. 2P OFFICE - WEST  
A707 1/4" = 1'-0"

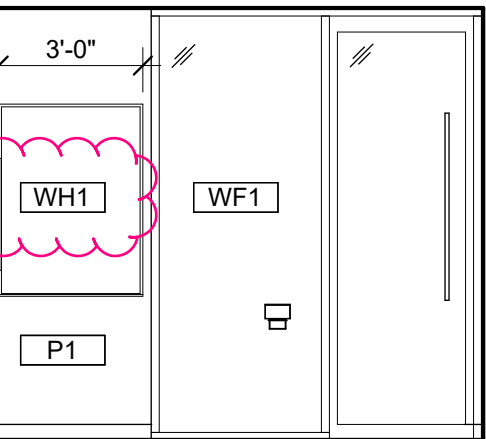


12 COOP WORKROOM - SOUTH  
A707 1/4" = 1'-0"

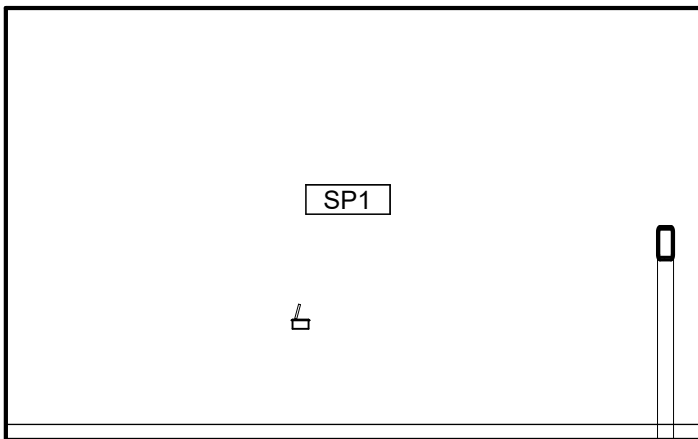

13 COOP WORKROOM - WEST  
A707 1/4" = 1'-0"

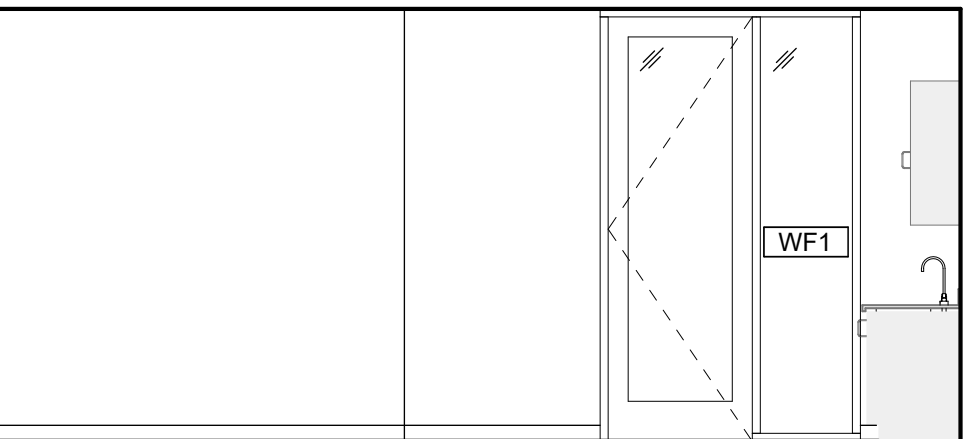

14 FACULTY LOUNGE - SOUTH  
A707 1/4" = 1'-0"

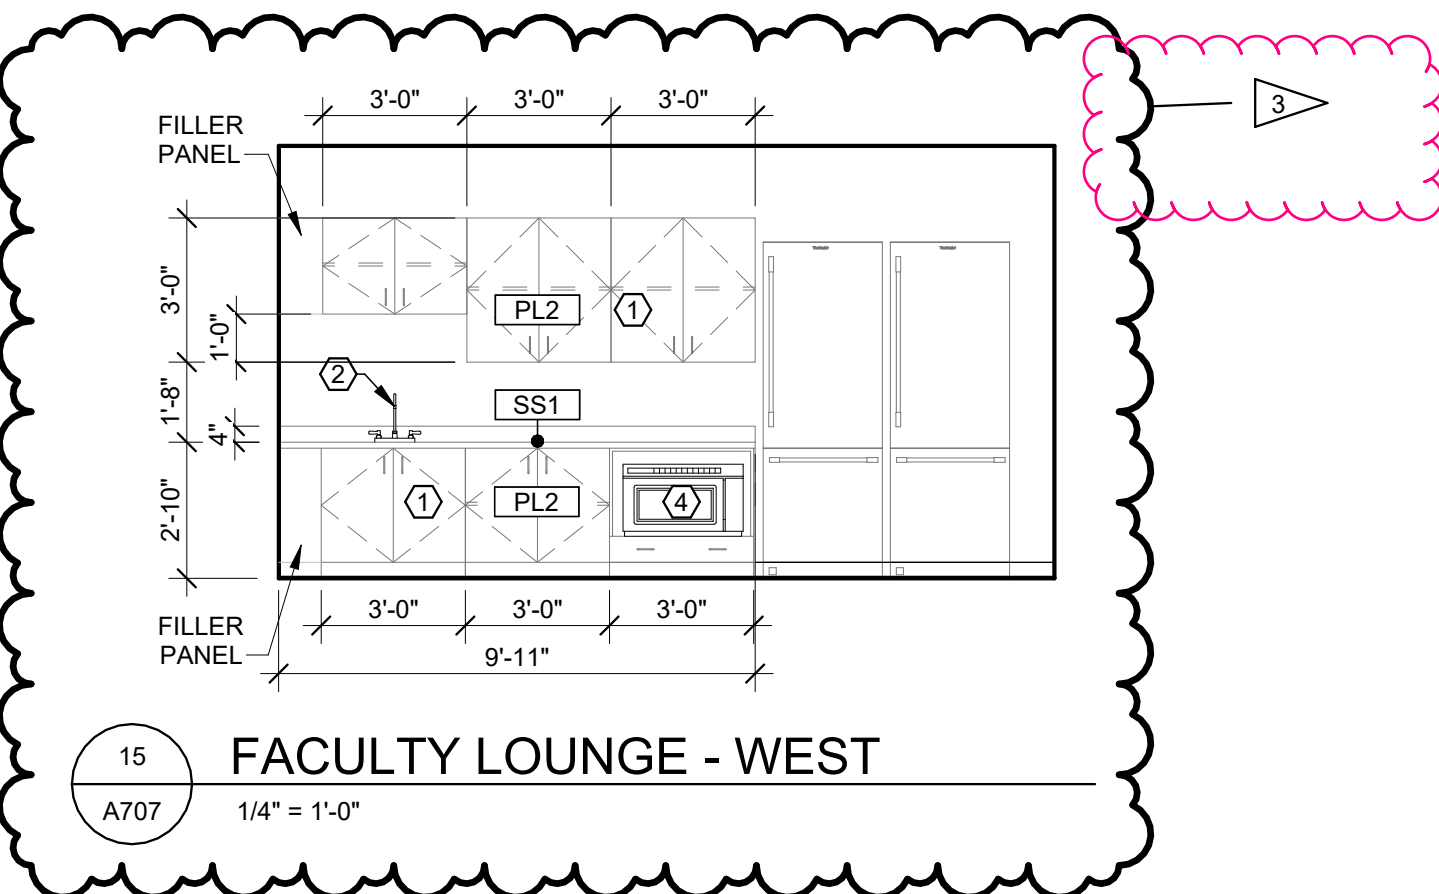

15 FACULTY LOUNGE - WEST  
A707 1/4" = 1'-0"

SHEET A707

- ADD Whiteboard 'WH1' designation to detail numbers 3, 9, 10, 12.


SHEET A707

- ADD Filler panels to casework at Faculty Lounge. Detail 15.

SLETTEN MARKED UP TO INCLUDE ALL NARRATIVES FROM  
CT FOR ADDENDUMS NO. 1,2,3 - DATED APRIL 2, 2024,  
APRIL 11, 2024, APRIL 16, 2024 RESPECTFULLY.




| MATERIALS LIST - BASIS OF DESIGN |                                    |                               |                                                                                              |                                                                                           |                                                                         |                                                                                                                                                                                                                |                                                 |
|----------------------------------|------------------------------------|-------------------------------|----------------------------------------------------------------------------------------------|-------------------------------------------------------------------------------------------|-------------------------------------------------------------------------|----------------------------------------------------------------------------------------------------------------------------------------------------------------------------------------------------------------|-------------------------------------------------|
| ITEM NO                          | PRODUCT TYPE                       | MANUFACTURER                  | DESCRIPTION                                                                                  | COLOR                                                                                     | SIZE                                                                    | NOTES                                                                                                                                                                                                          | SUSTAINABILITY NOTES                            |
| BASE                             |                                    |                               |                                                                                              |                                                                                           |                                                                         |                                                                                                                                                                                                                |                                                 |
| CB1                              | COVE BASE                          | SCHLUTER SYSTEMS              | DILEX-AHK COVE BASE                                                                          | STAINLESS STEEL                                                                           | GC TO CONFIRM SIZE WITH TILE ASSEMBLY                                   | TO BE INSTALLED WITH LATICRETE SPECTRALOCK EPOXY GROUT COLOR 78 STERLING SILVER                                                                                                                                | RECYCLED CONTENT, NON-EMITTING SOURCE OF VOCs   |
| RB1                              | RESILIENT BASE                     | JOHNSONITE                    | MILLWORK PROFILE MONUMENT                                                                    | PEWTER CG                                                                                 | 4" HIGH                                                                 | MITER CORNERS                                                                                                                                                                                                  | EPD, FLOORSORE, CRADLE TO GATE                  |
| RB2                              | RESILIENT BASE                     | JOHNSONITE                    | THERMOSET THERMOPLASTIC RUBBER COVE BASE                                                     | PEWTER CG                                                                                 | 4" HIGH                                                                 | MITER CORNERS, ROLLED GOODS                                                                                                                                                                                    | EPD, FLOORSORE, CRADLE TO GATE                  |
| CEILING                          |                                    |                               |                                                                                              |                                                                                           |                                                                         |                                                                                                                                                                                                                |                                                 |
| AC1                              | ACOUSTIC CEILING                   | ARMSTRONG                     | CALLA MINERAL FIBER                                                                          | WHITE                                                                                     | 2X2GRID, PRELUDE XL 15/16 SUSPENSION SYSTEM IN COLOR WHITE              | -                                                                                                                                                                                                              | EPD, HPD, DECLARE, GREENGUARD                   |
| AC3                              | ACOUSTIC CEILING                   | FSORB                         | FSORB ACOUSTIC PANELING                                                                      | WHITE                                                                                     | 1"THICK, 48"X96"                                                        | SEE RCPS. COORDINATE WITH MEP FIXTURES                                                                                                                                                                         | EPD, HPD, DECLARE, GREENGUARD                   |
| AC4                              | ACOUSTIC CEILING                   | ARMSTRONG                     | CALLA MINERAL FIBER                                                                          | BLACK                                                                                     | 2X2GRID, PRELUDE XL 15/16 SUSPENSION SYSTEM IN COLOR BLACK              | CONTROL ROOMS ONLY. SEE RCPS.COORDINATE WITH MEP FIXTURES                                                                                                                                                      | EPD, HPD, DECLARE, GREENGUARD                   |
| AL                               | ALUMINUM CEILING                   | LONGBOARD                     | ENDURA LINEAR DIRECT MOUNT CEILING, 6INCH V GROOVE PLANK                                     | BEECHWOOD                                                                                 | -                                                                       | SEE RCPS.                                                                                                                                                                                                      | EPD                                             |
| ALP                              | ALUMINUM CEILING                   | LONGBOARD                     | ENDURA LINEAR DIRECT MOUNT CEILING, 6INCH V GROOVE PERFORATED PLANK, SOUNDTEX ACOUSTIC LINER | BEECHWOOD, SOUNDTEX BLACK                                                                 | -                                                                       | SEE RCPS. COORDINATE WITH MEP FIXTURES                                                                                                                                                                         | EPD                                             |
| BF1                              | BAFFLES                            | LONGBOARD                     | DAUNTLESS BAFFLE CEILING SYSTEM                                                              | BEECHWOOD, HANGING SYSTEM DRYFALL WHITE                                                   | 6" HIGH BAFFLE                                                          | SEE RCPS. COORDINATE WITH MEP FIXTURES                                                                                                                                                                         | EPD                                             |
| FLOOR                            |                                    |                               |                                                                                              |                                                                                           |                                                                         |                                                                                                                                                                                                                |                                                 |
| CP1                              | CARPET                             | MILLIKEN                      | COLLECTION: LOW COUNTRY, PATTERN: SALT MARSH                                                 | SLM13 FRIPP                                                                               | 9.85"X39.4"                                                             | 33% OFFSET ASHLAR INSTALLATION                                                                                                                                                                                 | EPD, DECLARE, C2C                               |
| CP2                              | CARPET                             | MILLIKEN                      | COLLECTION: LOW COUNTRY, PATTERN: SEA RISE                                                   | SRS196-13 INDIGO PLANT                                                                    | 9.85"X39.4"                                                             | 33% OFFSET ASHLAR INSTALLATION                                                                                                                                                                                 | EPD, DECLARE, C2C                               |
| CP3                              | CARPET                             | MILLIKEN                      | COLLECTION: LOW COUNTRY, PATTERN: WATERWAY                                                   | WAT196-13 INDIGO PLANT                                                                    | 9.85"X39.4"                                                             | 33% OFFSET ASHLAR INSTALLATION                                                                                                                                                                                 | EPD, DECLARE, C2C                               |
| EM1                              | ENTRY WALK OFF CARPET              | MILLIKEN                      | OBEX BAR TRANSITIONS RECESSED                                                                | DARK GREY                                                                                 | 10.87"X39.37"                                                           | COORDINATE WITH STRUCTURE                                                                                                                                                                                      | INDOOR AIR ADVANTAGE GOLD                       |
| EM2                              | ENTRY WALK OFF CARPET              | MILLIKEN                      | WALK OFF OBEX CARPET TILE                                                                    | CUT FIZZ, DARK GREY                                                                       | 19.68X19.68                                                             | COORDINATE WITH STRUCTURE                                                                                                                                                                                      | INDOOR AIR ADVANTAGE GOLD                       |
| ES1                              | ELECTRIC STATIC FLOOR              | STATICWORK                    | AMERIWORKX CLASSIC EDS SOLID VINYL TILE                                                      | ADIRONDACK RIDGE                                                                          | 12X12                                                                   | COORDINATE GROUNDING FOR COPPER WIRE WITH ELECTRICAL                                                                                                                                                           | FLOORSORE, RECYCLED CONTENT                     |
| RT1                              | RESILIENT FLOORING                 | TARKE-IT                      | COLLECTION: COLOR WEAVE                                                                      | THUNDER                                                                                   | 18X18                                                                   | GLUE DOWN                                                                                                                                                                                                      | EPD, FLOORSORE, CRADLE TO GATE                  |
| SC1                              | SEALED CONCRETE                    | SHERWIN WILLIAMS              | H&C CLARISHIELD WATER-BASED CONCRETE SEALER                                                  | NATURAL LOOK                                                                              | -                                                                       | -                                                                                                                                                                                                              | -                                               |
| TF1                              | TILE FLOOR                         | EMSER                         | MOOD                                                                                         | RIVER GRAY                                                                                | 12X23                                                                   | TO BE INSTALLED WITH LATICRETE SPECTRALOCK EPOXY GROUT COLOR78 STERLING SILVER. TO BE USED WITH SCHLUTER UNCOUPLING MEMBRANE AND EXPANSION JOINTS AS RECOMMENDED                                               | HPD, REDLIST FREE                               |
| TF2                              | TILE FLOOR                         | FLORIDA TILE                  | CANAL STREET COLLECTION                                                                      | BLACK BAYOU                                                                               | 24X48                                                                   | TO BE INSTALLED WITH LATICRETE SPECTRALOCK EPOXY GROUT COLOR78 STERLING SILVER. TO BE USED WITH SCHLUTER UNCOUPLING MEMBRANE AND EXPANSION JOINTS AS RECOMMENDED                                               | EPD, HPD, GREENGUARD                            |
| MILLWORK                         |                                    |                               |                                                                                              |                                                                                           |                                                                         |                                                                                                                                                                                                                |                                                 |
| FB1                              | FABRIC UPHOLSTERY                  | ANZEA                         | KAPOW COLLECTION                                                                             | SLURP                                                                                     | SEE ELEVATIONS AND RENDERING FOR DESIGN INTENT                          | SEAT CUSHION. GC TO PROVIDE SHOP DRAWINGS FOR FINAL APPROVAL                                                                                                                                                   | HPD, REDLIST FREE                               |
| FB2                              | FABRIC UPHOLSTERY                  | CARNEGIE                      | ANAGRAM COLLECTION                                                                           | #6                                                                                        | SEE ELEVATIONS AND RENDERING FOR DESIGN INTENT                          | BACK CUSHION. GC TO PROVIDE SHOP DRAWINGS FOR FINAL APPROVAL                                                                                                                                                   | HPD, REDLIST FREE                               |
| HD1                              | HARDWARE: MODULAR CASEWORK         | CAROLINA MILEMARKER           | GRIP CABINET PULL, ADA COMPLIANT                                                             | SATIN NICKEL                                                                              | -                                                                       | TO BE INSTALLED WITH MODULAR CASEWORK, CONTACT: Jared.B@cdcollective.com WITH CONTRACT DESIGN                                                                                                                  | -                                               |
| PL1                              | PLASTIC LAMINATE: CUSTOM MILLWORK  | WILSONART                     | HPL BLOND ECHO LINEARITY FINISH                                                              | 7939K-18                                                                                  | -                                                                       | ALL MILLWORK SURFACES TO BE MATCHING WOOD GRAIN LOOK, NO MELAMINE                                                                                                                                              | HPD, INDOOR AIR ADVANTAGE GOLD, GREENGUARD GOLD |
| PL2                              | PLASTIC LAMINATE: MODULAR CASEWORK | CAROLINA-OFS                  | HPL LINEN (WOOD LOOK)                                                                        | OFS STANDARD LAMINATE                                                                     | -                                                                       | ALL MILLWORK SURFACES TO BE MATCHING WOOD GRAIN LOOK, NO MELAMINE                                                                                                                                              | INDOOR AIR ADVANTAGE GOLD                       |
| PL3                              | PLASTIC LAMINATE: CUSTOM MILLWORK  | WILSONART                     | HPL LINEN (WHITE) COLOR CORE                                                                 | D427-60 MATTE FINISH                                                                      | -                                                                       | ALL MILLWORK SURFACES TO BE MATCHING WOOD GRAIN LOOK, NO MELAMINE                                                                                                                                              | HPD, INDOOR AIR ADVANTAGE GOLD, GREENGUARD GOLD |
| QZ1                              | QUARTZ SURFACE                     | EVERO QUARTZ BY BRADLEY       | GEO SERIES                                                                                   | ANDORRA                                                                                   | -                                                                       | RESTROOM TROUGH SINK. SEE PLUMBING FOR DETAILS                                                                                                                                                                 | GREENGUARD GOLD                                 |
| SS1                              | SOLID SURFACE: MODULAR CASEWORK    | CAROLINA-OFS                  | LIVINGSTONE SURFACES, SNOWFALL                                                               | L213                                                                                      | -                                                                       | MITERED CORNERS, EASED EDGES, CONTACT: Jared.B@cdcollective.com WITH CONTRACT DESIGN                                                                                                                           | HPD, GREENGUARD                                 |
| MISC.                            |                                    |                               |                                                                                              |                                                                                           |                                                                         |                                                                                                                                                                                                                |                                                 |
| AC2                              | ACOUSTIC CEILING                   | TURF DESIGNS                  | ARCHITECTURAL ELEMENT: PATTERN FRACTAL, CLASS A                                              | SHELL HOUSING COLOR: DAMASCAS 09, INSERTS: LIGHT 04 GREY                                  | MODULAR CLOUD, 36"X36"                                                  | SEE RCP, DETAILS, AND ELEVATIONS FOR DESIGN INTENT. COORDINATE WITH MECHANICAL, ELECTRICAL AND STRUCTURAL SYSTEMS. INSTALLER TO USE RECOMMENDED THREADED ROD CONNECTION. CONTACT: jordan@absolute-resource.com | HPD, DECLARE                                    |
| AP1                              | ACOUSTIC PRODUCTS                  | KIREI                         | SOLID WALL PANEL                                                                             | 442 GREY                                                                                  | SHEET SIZE 9'X4'X1/2"THICK                                              | Z-CLIP MOUNT. SEE ELEVATIONS FOR DESIGN INTENT AND SIZING                                                                                                                                                      | HPD                                             |
| AP1.1                            | ACOUSTIC PRODUCTS                  | KIREI                         | SOLID WALL PANEL                                                                             | 442 GREY                                                                                  | SHEET SIZE 9'X4'X1/2"THICK                                              | Z-CLIP MOUNT. SEE ELEVATIONS FOR DESIGN INTENT AND SIZING                                                                                                                                                      | HPD                                             |
| AP2                              | ACOUSTIC PRODUCTS                  | MOMENTUM TEXTILES             | NUFELT MANCHESTER ACOUSTIC WALLCOVERING. PATTERN TO RUN HORIZONTAL. MATCH SEAMS.             | WISHFUL THINKING                                                                          | 0.12" THICK X 63" WIDE ROLL                                             | ADHESIVE MOUNT. PROVIDE METAL TRANSITION ON ALL EXPOSED EDGES.GC TO PROVIDE SHOP DRAWINGS FOR FINAL APPROVAL                                                                                                   | HPD, GREENGUARD, RECYCLED CONTENT               |
| AP3                              | ACOUSTIC PRODUCTS                  | KIREI                         | GROOVY 3.0 PANELS                                                                            | NAVY 365                                                                                  | SHEET SIZE: 110 X 44 NOOKS, TO BE USED WITH TRANSITION EDGE #LVT908EBRZ | SEE ELEVATIONS AND DETAILS FOR DESIGN INTENT. COORDINATE FITTING WITH ELECTRICAL AND FIRE PROTECTION                                                                                                           | EPD, HPD, DECLARE, RECYCLED CONTENT             |
| AP4                              | ACOUSTIC PRODUCTS                  | MDC WALLCOVERING              | ZINTRA, PATTTERN: PEREDITA                                                                   | CADET                                                                                     | 48X108X1/2" THICK                                                       | SEE ELEVATIONS AND DETAILS FOR DESIGN INTENT. COORDINATE FITTING WITH ELECTRICAL AND FIRE PROTECTION                                                                                                           | EPD, HPD, DECLARE, RECYCLED CONTENT             |
| CC1                              | CUBICLE CURTAIN                    | KNOLL                         | FABRIC PATTERN SIGNAL, MESH: WHITE, ACCESSORIES AND TRACK PROVIDED BY GC                     | FABRIC: COASTLINE, MESH: WHITE, GROMMETS: WHITE OR CLEAR ANNOIDIZED                       | SEE ELEVATIONS AND RENDERING FOR DESIGN INTENT                          | OMBRE STRIPES TO RUN HORIZONTAL. GC TO PROVIDE SHOP DRAWINGS FOR FINAL APPROVAL. SEE RCP AND DETAILS FOR HANGING STRUCTURE                                                                                     | FREE OF INTENTIONALLY ADDED PFAS                |
| LK1                              | LOCKERS                            | CAROLINA MILEMARKER           | 2 TIER STORAGE LOCKER. BATTERY OPERATED LOCKS. PULL: RECESSED. INCLUDE2 PRONG COAT HOOKS     | HPL LINEN (WOOD LOOK). PULL: SATIN NICKEL                                                 | SEE ELEVATIONS                                                          | -                                                                                                                                                                                                              | INDOOR AIR ADVANTAGE GOLD                       |
| LK1.1                            | LOCKERS                            | CAROLINA MILEMARKER           | OPEN CUBBIES                                                                                 | HPL LINEN (WOOD LOOK) PULL: STAIN NICKLE                                                  | SEE ELEVATIONS                                                          | CONFIRM QTY AND SIZE OF OPEN CUBBIES WITH CLIENT PRIOR TO APPROVAL                                                                                                                                             | INDOOR AIR ADVANTAGE GOLD                       |
| WF1                              | PRIVACY WINDOW FILM                | TAKEFORM                      | DUAL FADE FROSTED CUSTOM PATTERN                                                             | FROSTED                                                                                   | 60 INCH BAND TO START 2FT FROM BOTTOM OF DOOR                           | GC TO PROVIDE SHOP DRAWINGS FOR APPROVAL. GC TO PROVIDE MOCKUP PRIOR TO ORDERING FOR WINDOW FILM                                                                                                               | -                                               |
| WH1                              | WHITEBOARD                         | CLARUS                        | FLOAT: BACKPAINTED MAGNETIC GLASSBOARD                                                       | WHITE                                                                                     | SEE ELEVATIONS                                                          | REFER TO DETAIL FOR INSTALLATION. INCLUDE MARKERS, HANGERS AND ALL ACCESSORIES                                                                                                                                 | EPD, DECLARE                                    |
| WS1                              | WINDOW SHADES                      | LUTRON                        | MANUAL DUAL ROLLER SHADE: CONTRACT ROLLER MANUAL                                             | OPEN WEAVE, COLOR: M SCREEN CHARCOAL/GREY                                                 | FIELD VERIFY ON SITE                                                    | -                                                                                                                                                                                                              | -                                               |
| WS2                              | WINDOW SHADES                      | LUTRON                        | MANUAL ROLLER SHADES: CONTRACT ROLLER MANUAL                                                 | FASCIA: TBD, FABRIC: 1% OPEN WEAVE, COLOR: M SCREEN CHARCOAL/GREY                         | FIELD VERIFY ON SITE                                                    | -                                                                                                                                                                                                              | -                                               |
| WS3                              | WINDOW SHADES                      | LUTRON                        | MANUAL DUAL ROLLER SHADE: CONTRACT ROLLER MANUAL                                             | FASCIA: TBD, FABRIC #1: 1% OPEN WEAVE, COLOR: M SCREEN CHARCOAL/GREY. FABRIC #2: BLACKOUT | FIELD VERIFY ON SITE                                                    | -                                                                                                                                                                                                              | -                                               |
| TRANSITIONS                      |                                    |                               |                                                                                              |                                                                                           |                                                                         |                                                                                                                                                                                                                |                                                 |
| TR1                              | TRANSITION PROFILE                 | SCHLUTER SYSTEMS              | CARPET TO TILE: SCHIENE                                                                      | TBD                                                                                       | GC TO CONFIRM SIZES WITH MATERIAL THICKNESS                             | SEE ARCHITECTURAL DETAIL                                                                                                                                                                                       | RECYCLED CONTENT, NON-EMITTING SOURCE OF VOCs   |
| TR2                              | TRANSITION PROFILE                 | FUTURA TRANSITIONS            | CARPET TO RESILIENT: CARPET TO LVT PROFILE                                                   | ETCHED ALUMINUM                                                                           | GC TO CONFIRM SIZES WITH MATERIAL THICKNESS                             | SEE ARCHITECTURAL DETAIL                                                                                                                                                                                       | REACH / ROHS COMPLIANT                          |
| TR3                              | TRANSITION PROFILE                 | FUTURA TRANSITIONS            | CARPET TO CONCRETE: DELUXE BINDER BAR                                                        | ETCHED ALUMINUM                                                                           | GC TO CONFIRM SIZES WITH MATERIAL THICKNESS                             | SEE ARCHITECTURAL DETAIL                                                                                                                                                                                       | REACH / ROHS COMPLIANT                          |
| TR4                              | TRANSITION PROFILE                 | SCHLUTER SYSTEMS              | RESILIENT TO TILE: RENO-U                                                                    | TBD                                                                                       | GC TO CONFIRM SIZES WITH MATERIAL THICKNESS                             | SEE ARCHITECTURAL DETAIL                                                                                                                                                                                       | RECYCLED CONTENT, NON-EMITTING SOURCE OF VOCs   |
| TR5                              | TRANSITION PROFILE                 | FUTURA TRANSITIONS            | RESILIENT TO CONCRETE: COVING CAP                                                            | ETCHED ALUMINUM                                                                           | GC TO CONFIRM SIZES WITH MATERIAL THICKNESS                             | SEE ARCHITECTURAL DETAIL                                                                                                                                                                                       | REACH / ROHS COMPLIANT                          |
| TR6                              | TRANSITION PROFILE                 | FUTURA TRANSITIONS            | TILE TO CONCRETE: CERAMIC REDUCER EDGETEK U SHAPED                                           | ETCHED ALUMINUM                                                                           | GC TO CONFIRM SIZES WITH MATERIAL THICKNESS                             | SEE ARCHITECTURAL DETAIL                                                                                                                                                                                       | REACH / ROHS COMPLIANT                          |
| TR7                              | TRANSITION PROFILE                 | FUTURA TRANSITIONS            | FELT METAL EDGE FOR AP3                                                                      | #LVT 908 EBLK                                                                             | GC TO CONFIRM SIZES WITH MATERIAL THICKNESS                             | SEE ARCHITECTURAL DETAIL                                                                                                                                                                                       | REACH / ROHS COMPLIANT                          |
| TR8                              | TRANSITION PROFILE                 | FUTURA TRANSITIONS            | FELT METAL EDGE FOR AP2: BEVEL CAP                                                           | 4MM, #LVT 906 EBLK                                                                        | GC TO CONFIRM SIZES WITH MATERIAL THICKNESS                             | SEE ARCHITECTURAL DETAIL                                                                                                                                                                                       | REACH / ROHS COMPLIANT                          |
| TR9                              | TRANSITION PROFILE                 | TBD                           | WALL PROTECTION EDGE -LABS                                                                   | TBD                                                                                       | GC TO CONFIRM SIZES WITH MATERIAL THICKNESS                             | SEE ARCHITECTURAL DETAIL                                                                                                                                                                                       | -                                               |
| TR10                             | TRANSITION PROFILE                 | SCHLUTER SYSTEMS              | WALL TILE EDGE + CORNERS: FINEC SO - ALL EXPOSED EDGES, OUTSIDE CORNERS                      | TBD                                                                                       | GC TO CONFIRM SIZES WITH MATERIAL THICKNESS                             | SEE ARCHITECTURAL DETAIL                                                                                                                                                                                       | -                                               |
| TR11                             | TRANSITION PROFILE                 | FUTURA TRANSITIONS            | VENEER LAMINATE EDGE - NOOKS: COVING CAP 1/8" OR 3/32"                                       | EBLK                                                                                      | GC TO CONFIRM SIZES WITH MATERIAL THICKNESS                             | SEE ARCHITECTURAL DETAIL                                                                                                                                                                                       | RECYCLED CONTENT, NON-EMITTING SOURCE OF VOCs   |
| TR12                             | TRANSITION PROFILE                 | VARIES                        | STAIR TREAD TRANSITION                                                                       | TBD                                                                                       | GC TO CONFIRM SIZES WITH MATERIAL THICKNESS                             | SEE ARCHITECTURAL DETAIL                                                                                                                                                                                       | REACH / ROHS COMPLIANT                          |
| WALL                             |                                    |                               |                                                                                              |                                                                                           |                                                                         |                                                                                                                                                                                                                |                                                 |
| EP1                              | EPOXY PAINT                        | SHERWIN WILLIAMS              | PRO-INDUSTRIAL WATERBASED CATALYZED EPOXY                                                    | SW7566 WESTHIGHLAND WHITE                                                                 | CEILINGS: FLAT FINISH, WALLS EG-SHEL FINISH                             | GC TO PROVIDE LOW/NO VOC PAINT                                                                                                                                                                                 | -                                               |
| EP2                              | EPOXY PAINT                        | SHERWIN WILLIAMS              | PRO-INDUSTRIAL WATERBASED CATALYZED EPOXY                                                    | SW7609 GEORGIAN REVIVAL BLUE                                                              | CEILINGS: FLAT FINISH, WALLS EG-SHEL FINISH                             | GC TO PROVIDE LOW/NO VOC PAINT                                                                                                                                                                                 | -                                               |
| P1                               | PAINT                              | SHERWIN WILLIAMS              | ZERO VOC HARMONY INTERIOR LATEX PAINT                                                        | SW7566 WESTHIGHLAND WHITE                                                                 | CEILINGS: FLAT FINISH, WALLS EG-SHEL FINISH                             | GC TO PROVIDE LOW/NO VOC PAINT                                                                                                                                                                                 | -                                               |
| P2                               | PAINT                              | SHERWIN WILLIAMS              | ZERO VOC HARMONY INTERIOR LATEX PAINT                                                        | SW7609 GEORGIAN REVIVAL BLUE                                                              | CEILINGS: FLAT FINISH, WALLS EG-SHEL FINISH                             | GC TO PROVIDE LOW/NO VOC PAINT                                                                                                                                                                                 | -                                               |
| P3                               | PAINT                              | SHERWIN WILLIAMS              | ZERO VOC HARMONY INTERIOR LATEX PAINT                                                        | SW7506 VAST SKY                                                                           | CEILINGS: FLAT FINISH, WALLS EG-SHEL FINISH                             | GC TO PROVIDE LOW/NO VOC PAINT                                                                                                                                                                                 | -                                               |
| P4                               | PAINT                              | SHERWIN WILLIAMS              | ZERO VOC HARMONY INTERIOR LATEX PAINT                                                        | SW7072 ONLINE                                                                             | CEILINGS: FLAT FINISH, WALLS EG-SHEL FINISH                             | GC TO PROVIDE LOW/NO VOC PAINT                                                                                                                                                                                 | -                                               |
| P5                               | PAINT                              | SHERWIN WILLIAMS              | ZERO VOC HARMONY INTERIOR LATEX PAINT                                                        | SW7075 WEB GRAY                                                                           | CEILINGS: FLAT FINISH, WALLS EG-SHEL FINISH                             | GC TO PROVIDE LOW/NO VOC PAINT                                                                                                                                                                                 | -                                               |
| SP1                              | SPECIALITY PAINT/COATING           | GC/ SIGNAGE VENDOR TO PROVIDE | CUSTOM GRAPHIC ON TYPE III TERRAZON VINYL                                                    | CUSTOM IMAGERY                                                                            | SEE ELEVATIONS AND RENDERING FOR DESIGN INTENT                          | WALLS RECEIVING GRAPHIC TO HAVE A LEVEL 5 GYP FINISH. PROVIDE MOCKUP TO DESIGNER FOR APPROVAL, GC/CT TO PROVIDE DESIGN INTENT. GC TO PROVIDE METAL EDGE TRIM ON EXPOSED EDGES                                  | -                                               |
| FW1                              | FIBERGLASS REINFORCED PANEL        | CONSTRUCTION SPECIALTIES      | FRP ACROVYN WALL COVERING                                                                    | WHITE, SUEDE FINISH                                                                       | 4'X8'                                                                   | FRP TO START AT TOP OF BASE                                                                                                                                                                                    | EPD                                             |
| WP1                              | WALL PROTECTION                    | CONSTRUCTION SPECIALTIES      | ACROVYN WALL PROTECTION RIGID SHEET                                                          | WHITE, SUEDE FINISH                                                                       | 4'X8'                                                                   | INSTALL ABOVE FINISHED FLOOR; WALL BASE TO BE INSTALLED ON TOP OF WP# PANEL.                                                                                                                                   | EPD, CRADLE TO CRADLE                           |
| WALL PROTECTION                  |                                    |                               |                                                                                              |                                                                                           |                                                                         |                                                                                                                                                                                                                |                                                 |
| CG1                              | CORNER GUARD                       | C.S. ACROVYN                  | SSM-20                                                                                       | WHITE, SUEDE FINISH                                                                       | 2" WINGS, FULL HEIGHT                                                   | CG1 TO START AT TOP OF BASE.                                                                                                                                                                                   | EPD                                             |
| CH1                              | CHAIR RAIL                         | CS ACROVYN                    | SCR-40 SURFACE MOUNTED                                                                       | WHITE, SUEDE FINISH                                                                       | 4" HIGH                                                                 | SEE ELEVATIONS FOR DESIGN INTENT AND SIZING                                                                                                                                                                    | EPD                                             |
| FRP1                             | FIBERGLASS REINFORCED PANEL        | CONSTRUCTION SPECIALTIES      | FRP ACROVYN WALL COVERING                                                                    | WHITE, SUEDE FINISH                                                                       | 4'X8'                                                                   | FRP TO START AT TOP OF BASE                                                                                                                                                                                    | -                                               |

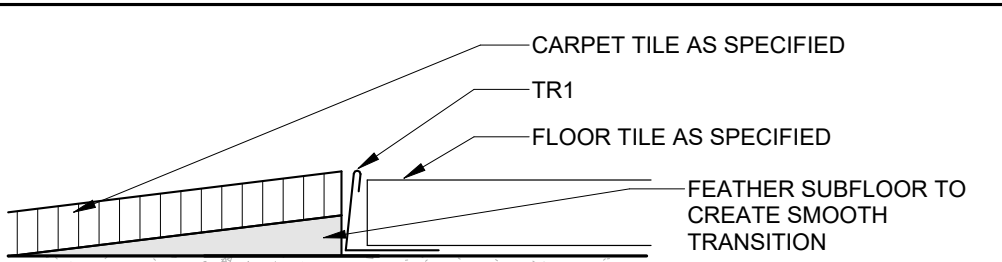


1  
A503  
12" = 1'-0"

INTERIOR DETAIL - TR1 CARPET TO FLOOR TILE

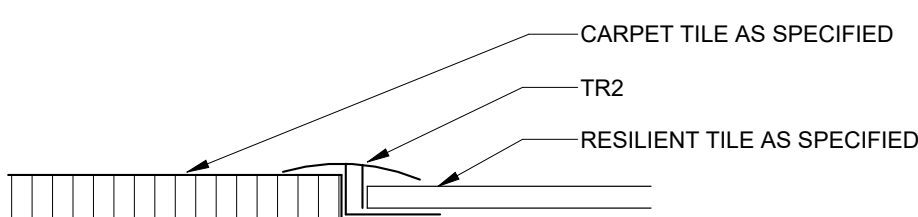


2  
A503  
12" = 1'-0"

INTERIOR DETAIL - TR2 CARPET TO RESILIENT

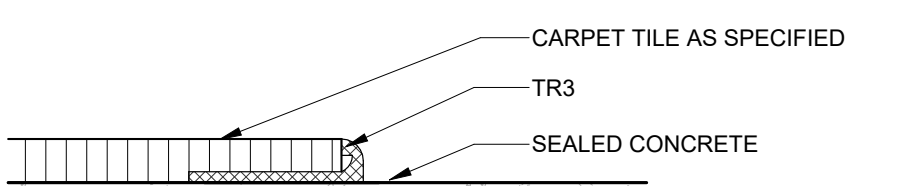


3  
A503  
12" = 1'-0"

INTERIOR DETAIL - TR3 CARPET TO CONCRETE

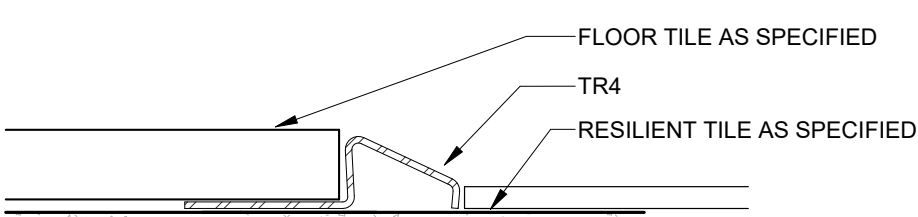


4  
A503  
12" = 1'-0"

INTERIOR DETAIL - TR4 RESILIENT TO FLOOR TILE

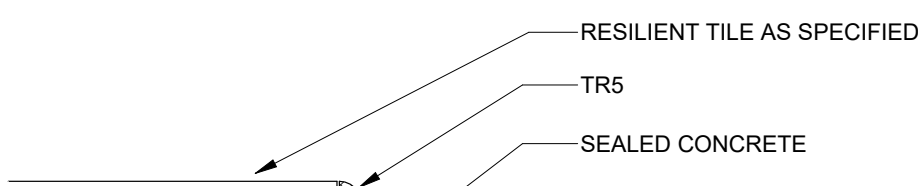


5  
A503  
12" = 1'-0"

INTERIOR DETAIL - TR5 RESILIENT TO CONCRETE

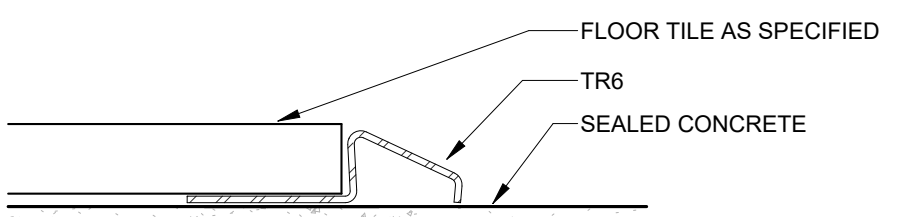


6  
A503  
12" = 1'-0"

INTERIOR DETAIL - TR6 FLOOR TILE TO CONCRETE

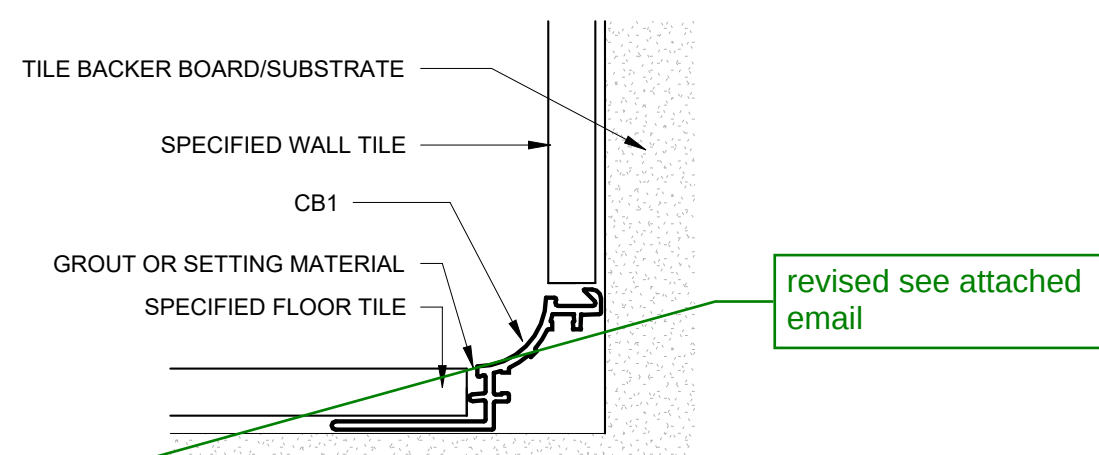


7  
A503  
12" = 1'-0"

INTERIOR DETAIL - TILE COVE BASE

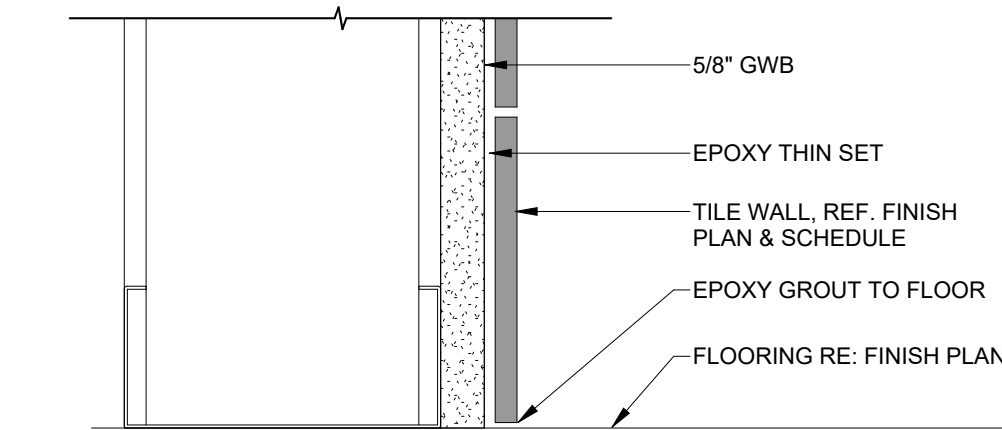

8  
A503  
6" = 1'-0"

INTERIOR DETAIL - TILE WALL BASE

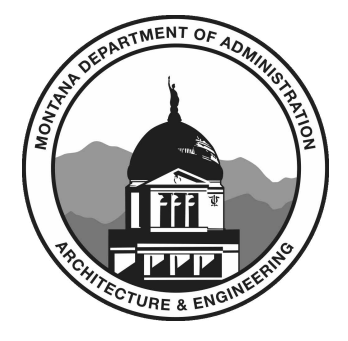

**MARK & ROBYN JONES COLLEGE OF NURSING - GREAT FALLS**

**MONTANA STATE UNIVERSITY**

BUILDING PERMIT SET

**Cushing Terrell**

**co ARCHITECTS**

| DRAWN | LD                  |
|-------|---------------------|
| REV   | DESCRIPTION         |
| 2     | ADD-02 04.10.24     |
| 3     | ADD-03 04.16.24     |
| 15    | PR-11 10.01.24      |
| 18    | PR-14 Date 10.26.24 |

PPA#21-0170

A/E#: 2022-02-09-02

**SHEET TITLE**

**INTERIOR MATERIALS**

**SCHEDULE AND DETAILS**


**SHEET**

**A503**

**DATE**

**03.08.2024**



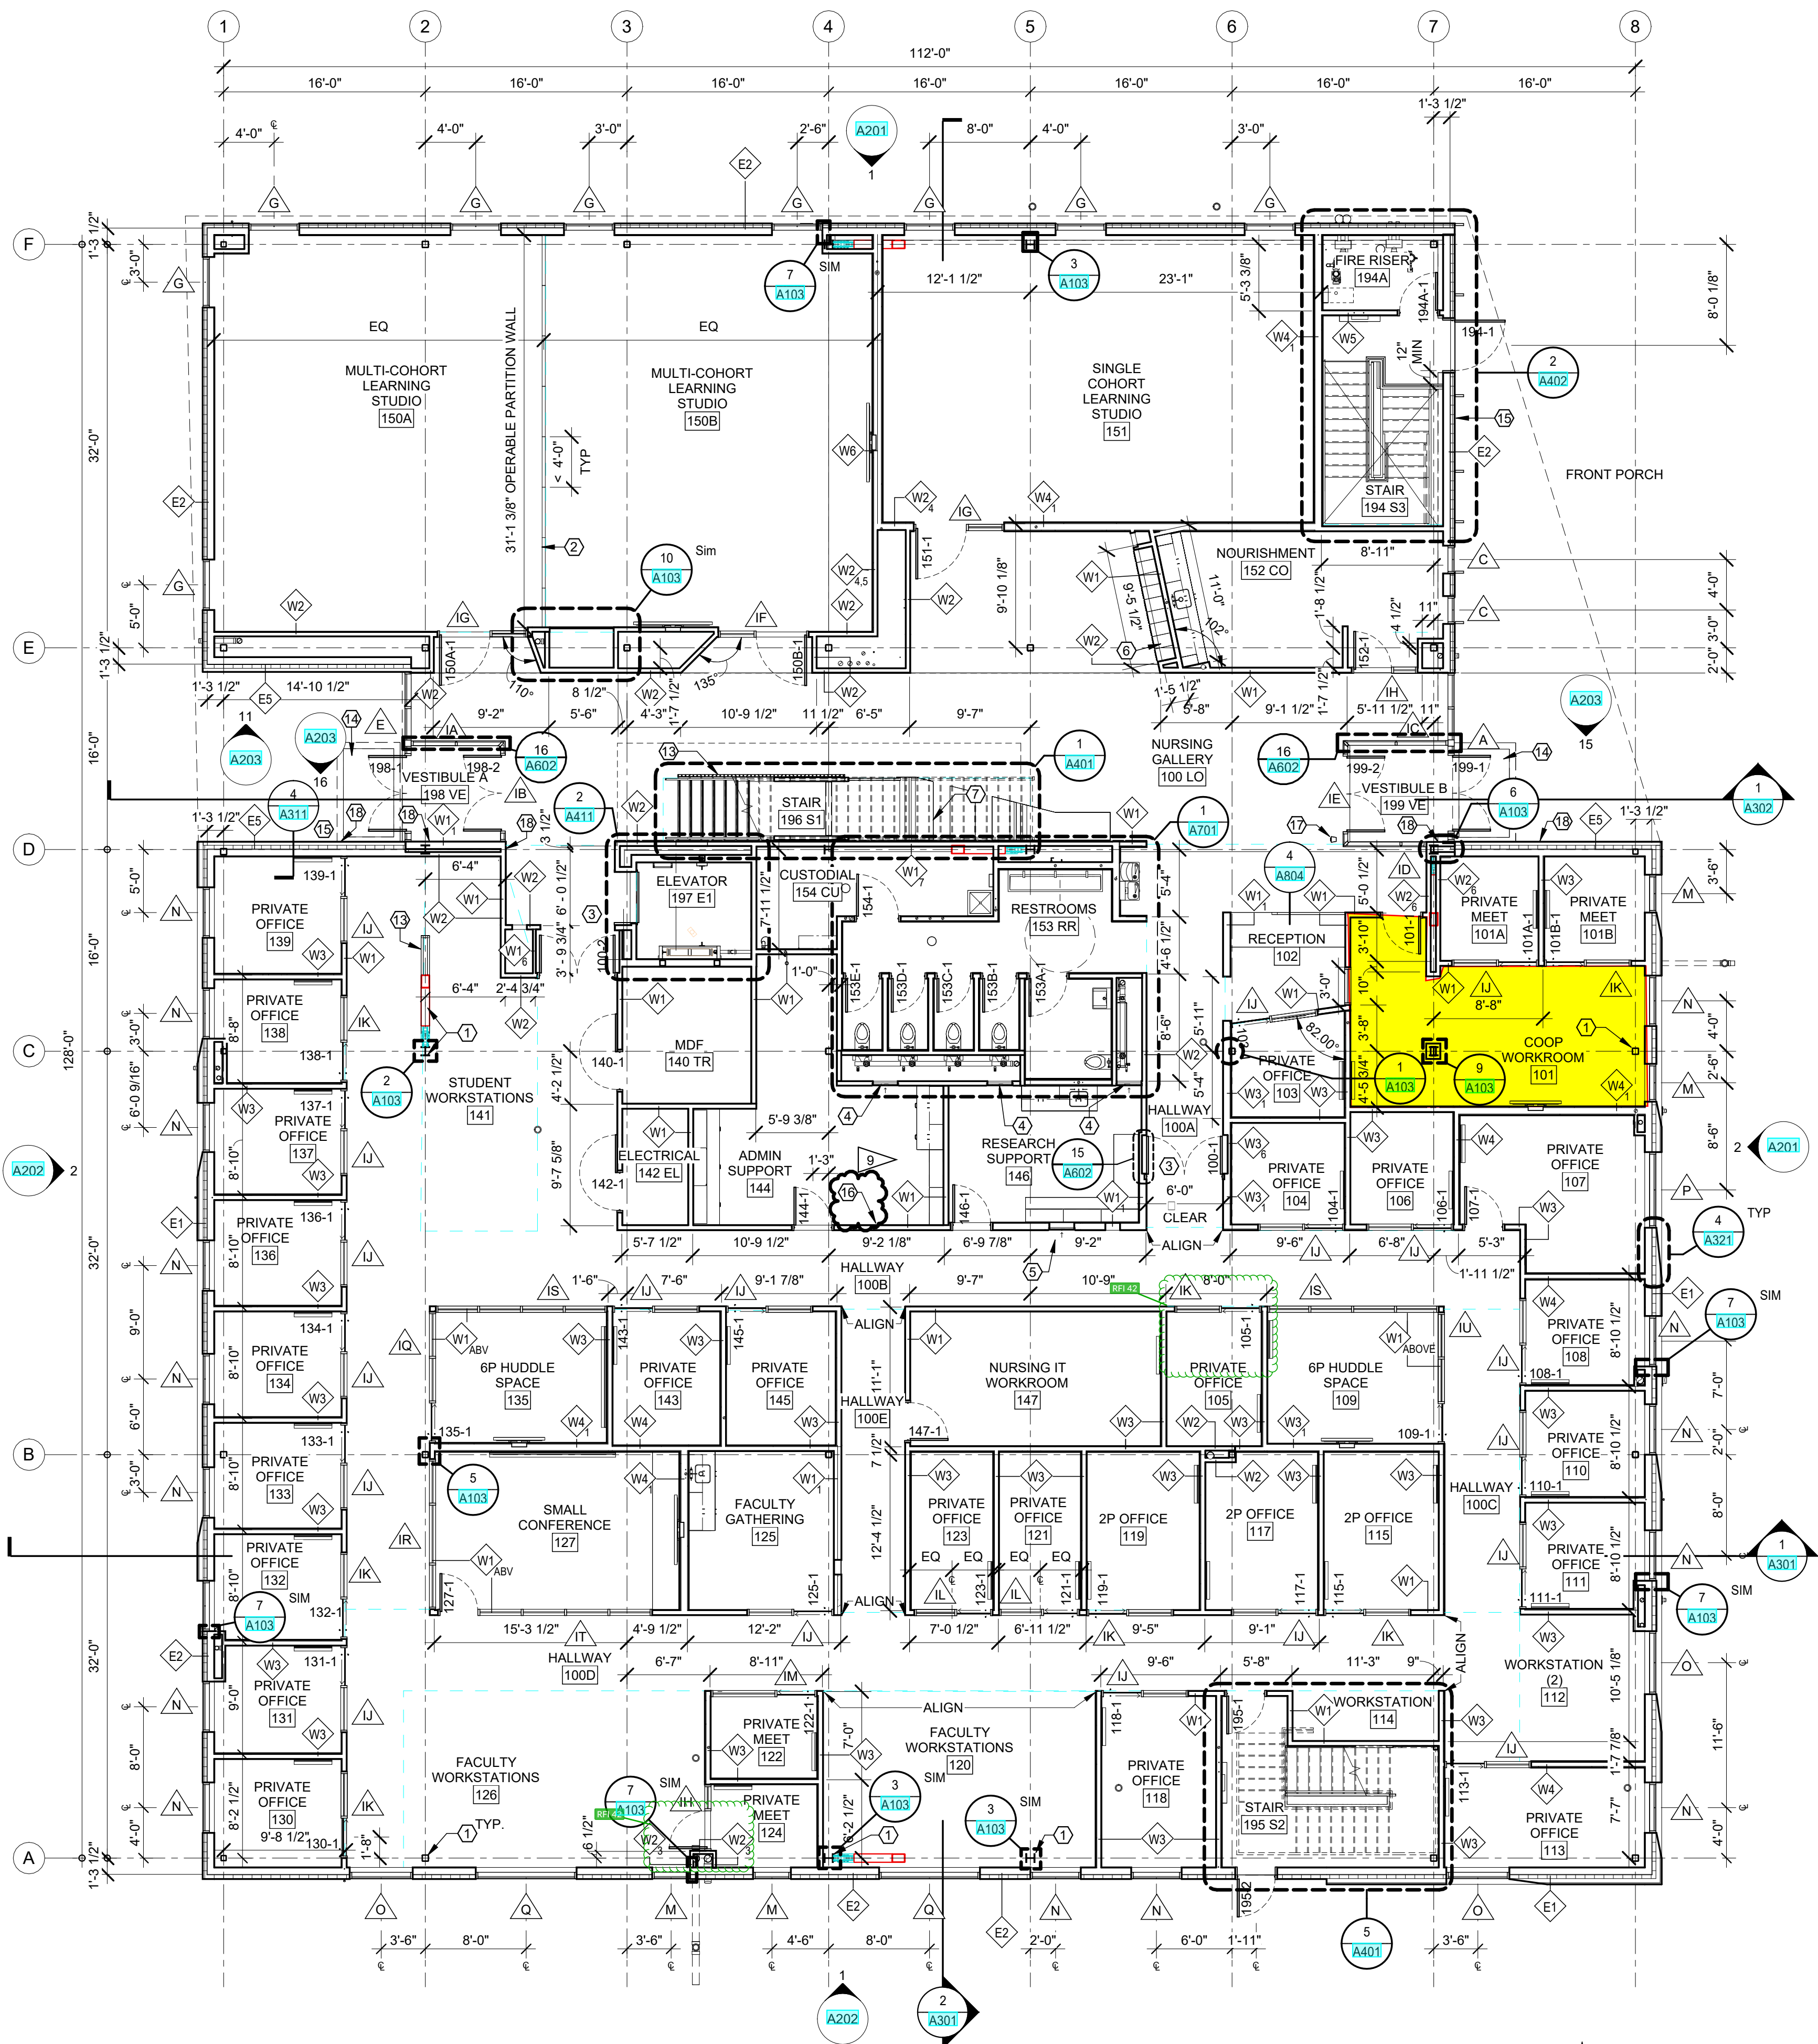

PLAN LEGEND

- WALL → ASSEMBLY TYPE (SEE ASSEMBLIES SHEET)  
1 → ASSEMBLY MODIFIER, PER TYPE  
NAME → ROOM NAME AND NUMBER  
X → WINDOW TYPE (SEE A600s)  
X → KEYNOTE  
1 → DIRECTION OF VIEW, IF APPLICABLE  
1 → DRAWING NUMBER  
X000 → SHEET WHERE DRAWN  
101 → DOOR NUMBER (SEE SHEET A601)  
→ DIMENSION TO FACE OF FRAMING  
→ DIMENSION TO GRID LINE  
→ DIMENSION TO CENTER LINE

GENERAL PLAN NOTES

- A. SEE A500 SHEETS FOR ALL FINISH REQUIREMENTS.  
B. SEE A600 SHEETS FOR WINDOW AND DOOR SCHEDULES.  
C. SEE A700 SHEETS FOR INTERIOR ELEVATIONS.  
D. COORDINATE WITH BUILDING SECTIONS AND STRUCTURAL DRAWINGS FOR FINISH FLOOR ELEVATIONS.  
E. SEE G100 SHEETS REGARDING BUILDING CODE REQUIREMENTS.  
F. SEE SHEET A602 FOR TYPICAL EXTERIOR AND INTERIOR WALL TYPE ASSEMBLIES.  
G. SEE A900 SHEETS FOR REFLECTED CEILING PLANS AND DETAILS.  
H. PROVIDE BLOCKING IN WALL FOR ALL MOUNTED EQUIPMENT, MILLWORK, AND HARDWARE.  
I. FIELD VERIFY ALL CASEWORK AND BUILT IN COMPONENTS PRIOR TO FABRICATION.  
J. COORDINATE ALL PLUMBING FIXTURES LOCATIONS WITH PLUMBING DRAWINGS.

KEYNOTES

1. PAINT EXPOSED STRUCTURE. SEE FINISH PLANS.  
2. SOLID PANEL OPERABLE PARTITION WALL SYSTEM, SEE SPEC.  
3. DOOR TO BE RECESSED INTO ADJACENT WALLS, SEE DOOR SCHEDULE AND DETAILS, TYPICAL BOTH SIDES.  
4. 24"x48" ACCESS PANEL, MOUNT FLUSH WITHIN WALL 6" ABOVE FINISH FLOOR, PAINT TO MATCH ADJACENT WALL.  
5. 24"x24" ACCESS PANEL, MOUNT FLUSH WITHIN WALL 5' TO CENTERLINE OF PANEL, PAINT TO MATCH ADJACENT WALL.  
6. LOCKERS, SEE FINISH PLANS.  
7. CUSTOM BUILT-IN SEAT & TABLE NOOK, SEE A803.  
8. METAL GUARDRAIL, SEE A402 FOR DETAIL. SAME AS STAIR 1 GUARDRAIL.  
9. NOT USED.  
10. CUSTOM BUILT-IN SEAT & TABLE NOOK, SEE A803.  
11. CANE RAIL, SEE DETAIL 11/A103.  
12. WALK OFF GRATE.  
13. KNOX BOX, SEE FIRE ALARM.  
14. PROVIDE A BACK-TO-BACK STUD AT EACH SIDE OF THE RACK FOR ATTACHMENT SUPPORT. THE MOUNTING HOLES ARE LOCATED AT 18", SO ALIGN INTERIOR STUD SPACING TO ACCOMMODATE RACK LOCATION SHOWN.  
15. ADA COMPLIANT, HEAVY DUTY TOWER PEDESTAL. BASIS OF DESIGN: INTERCOM ONLINE PD1054, 47 INCHES TALL, POWDER COATED BLACK, ONE SINGLE GANG BOX CUTOFF FOR ADA BUTTON, COORDINATE WITH AUTOMATIC OPERATORS.  
16. WALL MOUNT ADA OPERATOR DOOR ACTUATOR LOCATION, SEE HARDWARE SPEC AND COORDINATE WITH ELECTRICAL.


1 FIRST FLOOR PLAN  
A101 1/8" = 1'-0"



MARK & ROBYN JONES COLLEGE  
OF NURSING - BOZEMAN  
MONTANA STATE UNIVERSITY

Cushing  
Terrell  
ARCHITECTS

|              |             |          |
|--------------|-------------|----------|
| DRAWN BY:    |             | TS, ET   |
| REVIEWED BY: |             | SC       |
| REV.         | DESCRIPTION | DATE     |
| 1            | ADD-02      | 04.26.24 |
| 6            | ASI-02      | 08.05.24 |
| 9            | PR-03       | 08.30.24 |

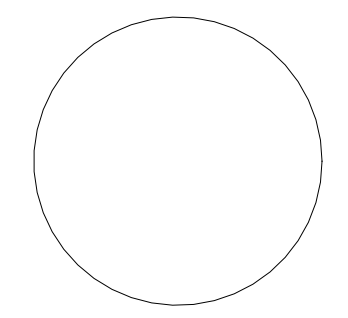

PPA#21-0167


A/E#: 2022-02-09-01

SHEET TITLE  
FIRST FLOOR PLAN

SHEET  
A101

DATE  
03.22.2024



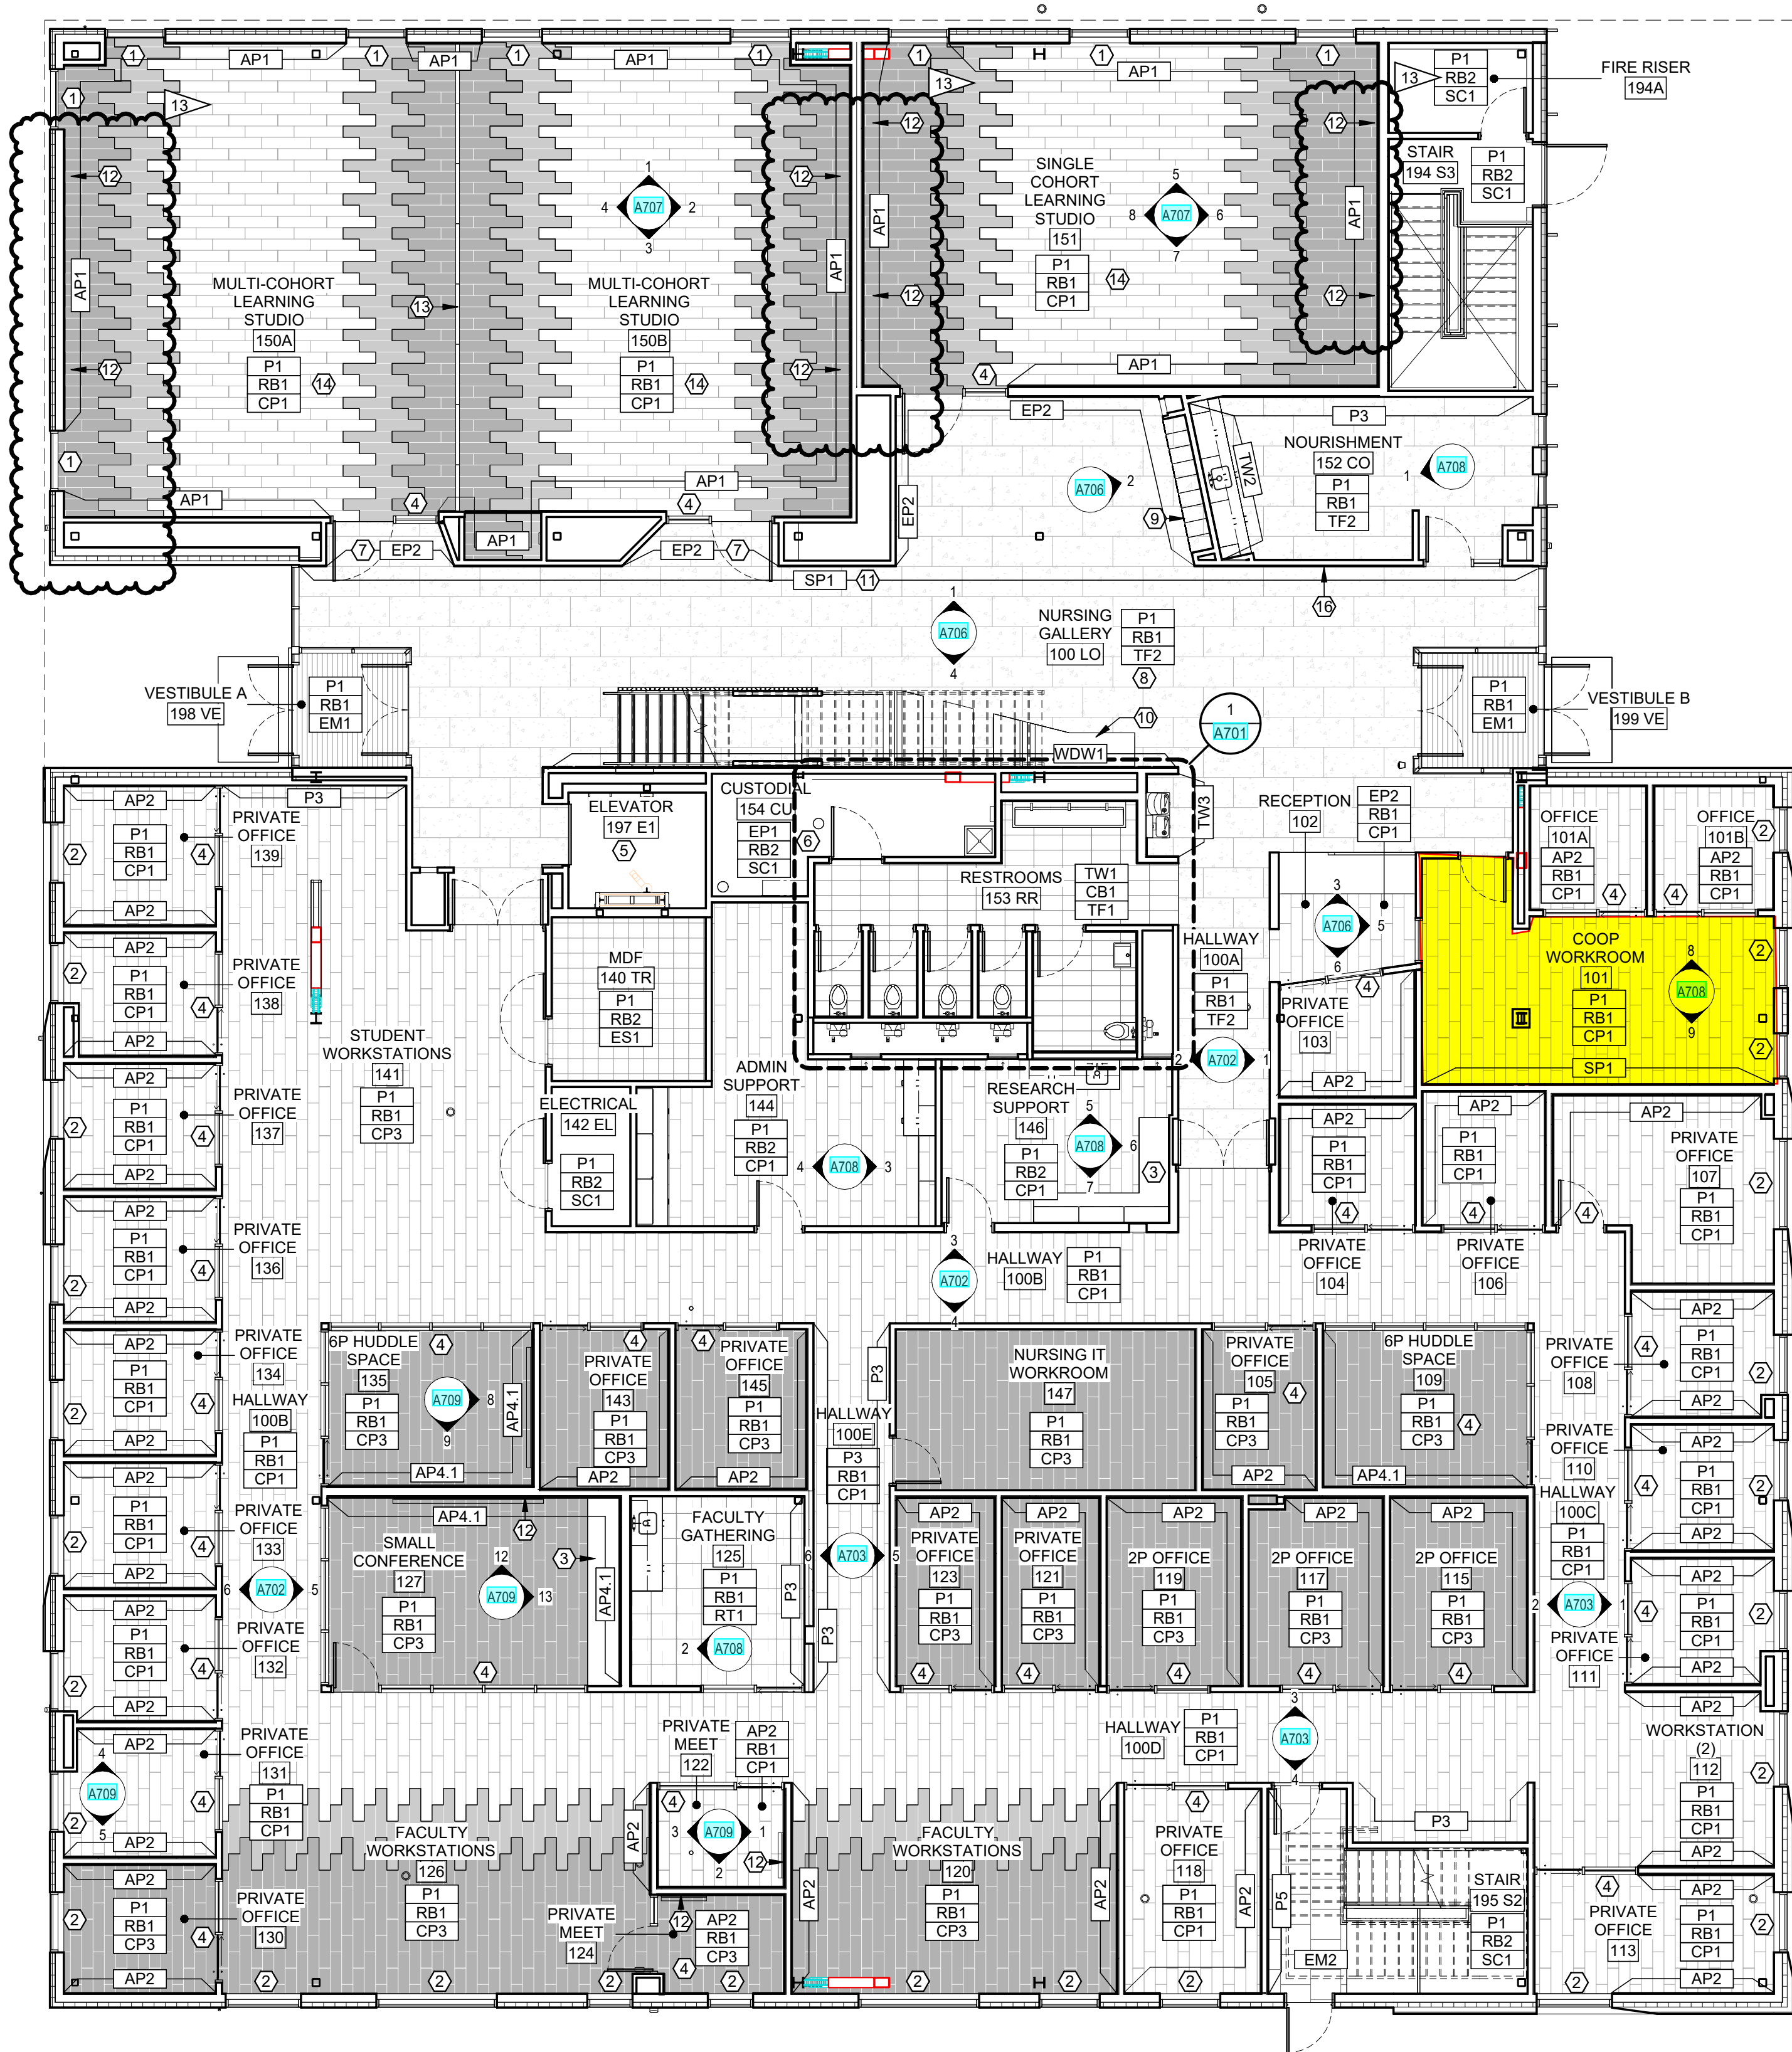

1 FIRST FLOOR FINISH PLAN  
A501 1/8" = 1'-0"



## FINISH PLAN LEGEND

- NAME  
101 ROOM NAME AND NUMBER
- (A8##) # INTERIOR ELEVATION CALLOUT AND DIRECTION OF ELEVATION VIEW
- XX### FINISH TAG
- XX### EXTENT OF ACCENT PAINT OR WALL FINISHES

FINISH TAGS DISPLAYED IN GROUPING ON FINISH PLAN REPRESENT MAJORITY ROOM FINISH SELECTIONS. ORDER OF GROUPING DEFINED IN EXAMPLE BELOW:

- XX### MAJORITY WALL FINISH  
XX### MAJORITY BASE FINISH  
XX### MAJORITY FLOOR FINISH

CG LOCATION AND TYPE OF CORNER GUARDS 'CG1'

- FLOOR FINISH 'CP1' FLOOR FINISH 'ES1'
- FLOOR FINISH 'CP2' FLOOR FINISH 'RT1'
- FLOOR FINISH 'CP3' FLOOR FINISH 'TF1'
- FLOOR FINISH 'EM1' FLOOR FINISH 'TF2'
- FLOOR FINISH 'EM2'

## GENERAL FINISH NOTES

- VERIFY ALL CONDITIONS AND DIMENSIONS IN FIELD PRIOR TO FABRICATION.
- ALL PRODUCTS ARE TO BE INSTALLED PER MANUFACTURER'S INSTRUCTIONS, USING MANUFACTURER'S ADHESIVES, TOOLS, AND METHODS.
- REFER TO SPECIFICATIONS AND MATERIAL FINISH LIST FOR ALL FINISH MATERIAL PRODUCT INFORMATION.
- FOR INTERIOR ELEVATIONS AND ADDITIONAL FINISHES, RE: A700'S.
- FOR CEILING HEIGHTS AND ADDITIONAL FINISHES RE: A900'S.
- COORDINATE ALL OWNER FURNISHED EQUIPMENT, ACCESSORIES, AND FURNITURE WITH OWNER AND/OR OWNER'S VENDOR.
- ALL FLOOR TRANSITIONS ARE TO OCCUR DIRECTLY BENEATH DOORS OR CENTERED IN OPENINGS. TRANSITIONS ARE TO BE ADA COMPLIANT.
- REFER TO FINISH PLAN FOR LOCATION OF CORNER GUARDS. INSTALL AT TOP OF WALL BASE.
- ALL GYPSUM WALLS TO BE PAINTED 'P1' UNLESS OTHERWISE NOTED.
- ALL GYPSUM CEILINGS AND SOFFITS TO BE PAINTED 'P1' UNLESS OTHERWISE NOTED ON REFLECTED CEILING PLAN.
- ALL WALL BASE TO BE 'RB1' UNLESS OTHERWISE NOTED.
- ALL HOLLOW METAL FRAMES TO BE PAINTED BLACK IN SEMI-GLOSS FINISH. UNLESS OTHERWISE NOTED. SEE DOOR SCHEDULE FOR MORE INFORMATION.
- ALL METAL ACCESS DOORS, PANELS, COVER PLATES, VENTS, AND GRILLES TO BE PAINTED TO MATCH THE SURFACE IT IS LOCATED ON.
- ALL QUARTZ AND SOLID SURFACE COUNTERTOPS TO HAVE EASED EDGES. ADJACENT BACKSPLASH TO MATCH. UNLESS OTHERWISE NOTED.
- ALL WINDOW TREATMENTS ARE TO BE FIELD MEASURED, INSTALLED WITH ALL COMPONENTS, AND INSIDE MOUNTED, UNLESS OTHERWISE NOTED.
- ALL WALLS TO RECEIVE CUSTOM GRAPHIC TO HAVE A LEVEL 5 GYP FINISH.
- ALL LEARNING STUDIOS, LABS, CONFERENCE ROOMS, AND OFFICES TO RECEIVE 'WH1' WHITEBOARD. REFER TO MATERIAL FINISH LIST FOR PRODUCT SPECIFICATIONS AND ELEVATIONS FOR SIZING.
- FOR ALL FLOORING AND WALL TRANSITIONS REFER TO MATERIAL FINISH LIST FOR PRODUCT SPECIFICATIONS. GC IS RESPONSIBLE TO PROVIDE THE CORRECT SIZING FOR TRANSITIONS.
- SEE RCP FOR PAINTED DRYFALL SYSTEM AND ACOUSTIC SPRAY SYSTEM.
- PAINT ALL EXPOSED STRUCTURAL STEEL COLUMNS, CROSS BRACING, ETC. WITH 'P1' SEMI-GLOSS FINISH. UNLESS NOTED OTHERWISE.

## KEYNOTES


- MOTORIZED AND CONTROLLED ROLLER SHADES 'WS1' TO BE INSTALLED ON EXTERIOR WINDOWS IN THIS ROOM. REFER TO MATERIAL FINISH LIST FOR PRODUCT SPECIFICATIONS. COORDINATE POWER AND AUTOMATION WITH ELECTRICAL.
- MANUAL ROLLER SHADES 'WS2' ON EXTERIOR WINDOWS IN THIS ROOM. REFER TO MATERIAL FINISH LIST FOR PRODUCT SPECIFICATIONS.
- CUSTOM MILLWORK. SEE ELEVATION FOR DETAILS.
- INSTALL PRIVACY WINDOW FILM 'WF1' ON GLAZING IN THIS ROOM. REFER TO MATERIAL FINISH LIST FOR PRODUCT SPECIFICATIONS. REFER TO DOOR AND WINDOW SCHEDULE FOR MOUNTING HEIGHTS.
- ELEVATOR CAB FINISHES TO BE SELECTED BY ARCHITECT FROM VENDORS FULL RANGE, INCLUDING WALL AND CEILING PANELS, HAND RAILS, AND FLOORING.
- INSTALL 'FRP1' ON ALL WALLS IN THIS ROOM. 4FT HIGH TO START AT TOP OF BASE.
- ALL WALLS WITHIN ALCOVE TO BE PAINTED WITH 'P2'.
- SEE ISOMETRICS, ELEVATIONS, RENDERINGS FOR DESIGN AND MATERIAL INTENT.
- SEE MATERIAL FINISH LIST 'LK1' FOR LOCKER SPECIFICATION. VENDOR PROVIDED, VENDOR INSTALLED.
- CUSTOM BOOTH SEATING AND TABLES. SEE ELEVATIONS, RENDERINGS AND DETAILS FOR CONSTRUCTION AND DESIGN INTENT. REFER TO MATERIAL FINISH LIST FOR UPHOLSTERY.
- LEVEL 5 WALL FINISH FOR FUTURE ART INSTALLATION.
- WHITEBOARD LOCATED ON THIS WALL. REFER TO MATERIAL FINISH LIST FOR PRODUCT SPECIFICATIONS, SIZE AND LOCATION.
- MOVEABLE WALL PARTITION. ARCHITECT TO SELECT FINISHES FROM FULL SAMPLE RANGE.
- INSTALL CHAIR RAIL 'CH1' IN THIS ROOM. SEE MATERIAL FINISH LIST AND ELEVATIONS FOR PRODUCT DETAILS, SIZING, AND LOCATION.
- NOT USED.
- FUTURE WALL HUNG ART LOCATION. GC TO PROVIDE IN WALL BACKING AS NEEDED.



MARK & ROBYN JONES COLLEGE  
OF NURSING - BOZEMAN  
MONTANA STATE UNIVERSITY

Cushing  
Terrell  
ARCHITECTS

|              |             |         |
|--------------|-------------|---------|
| DRAWN BY:    |             | LD      |
| REVIEWED BY: |             | MH      |
| REV.         | DESCRIPTION | DATE    |
| 1            | ADD-02      | 04.26.2 |
| 13           | PRO5        | 10.04.2 |

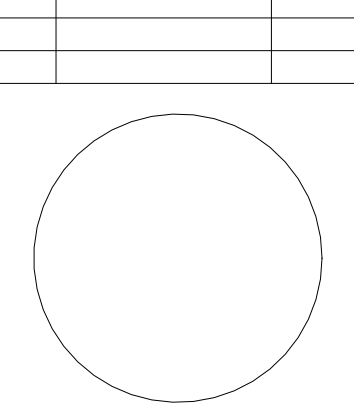

PPA#21-0167


A/E# 2022-02-09-01

SHEET TITLE  
FIRST FLOOR FINISH  
PLAN, SCHEDULES &  
DETAILS


SHEET  
A501

DATE  
03.22.2024




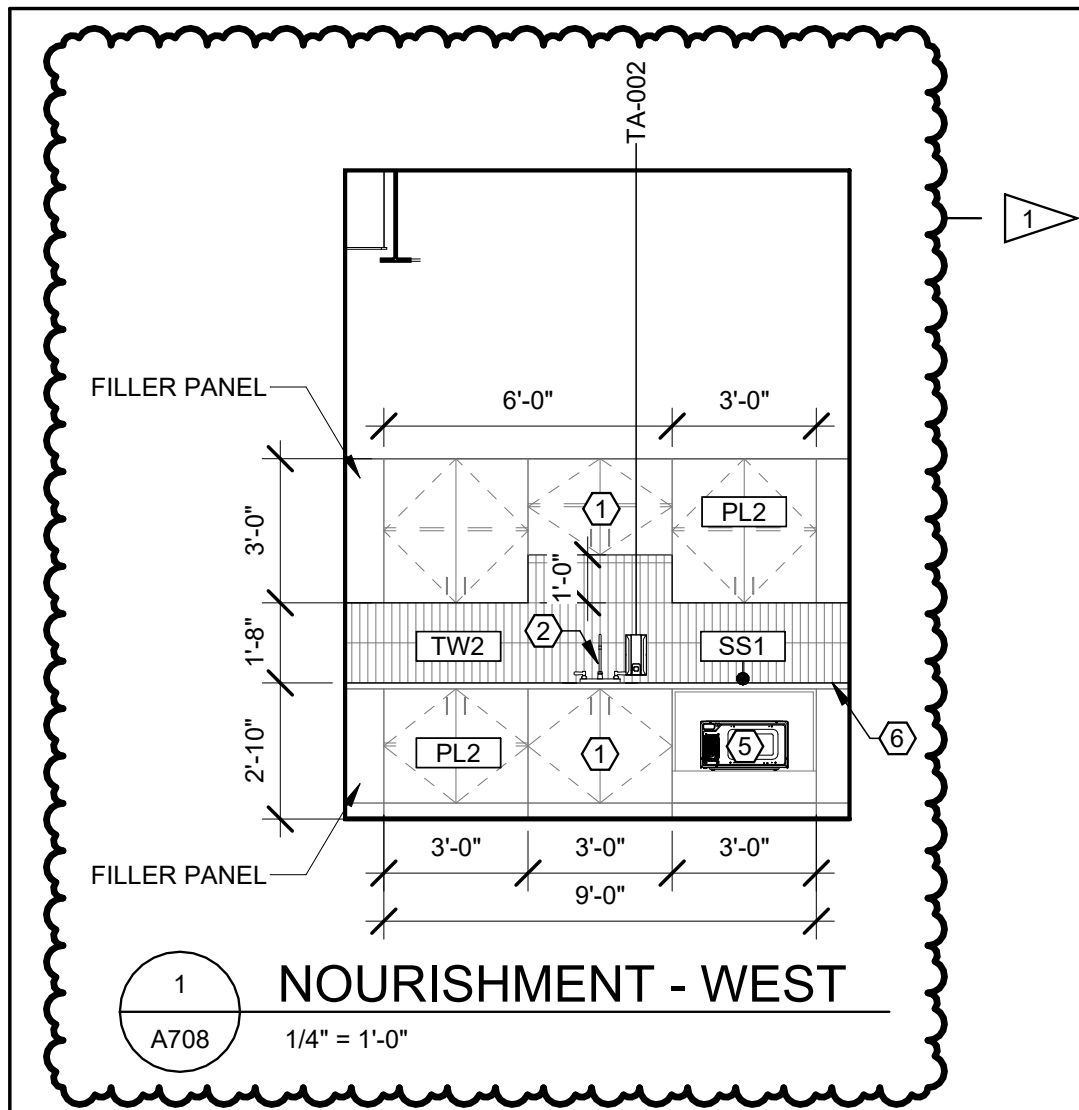


1 NOURISHMENT - WEST  
A708 1/4" = 1'-0"

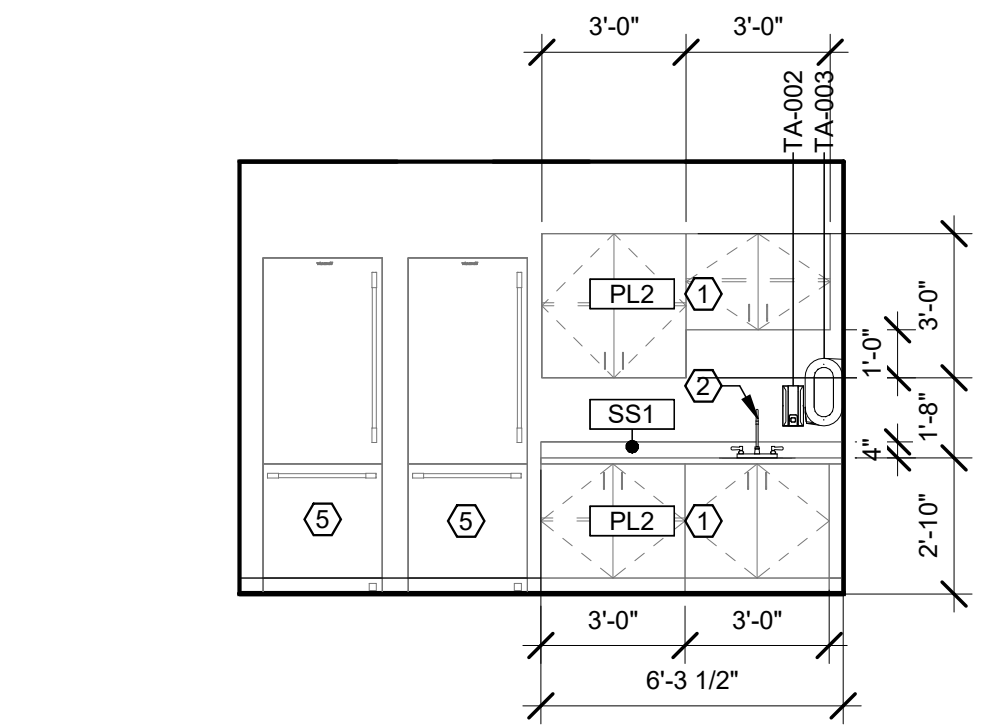


2 FACULTY GATHERING - WEST  
A708 1/4" = 1'-0"

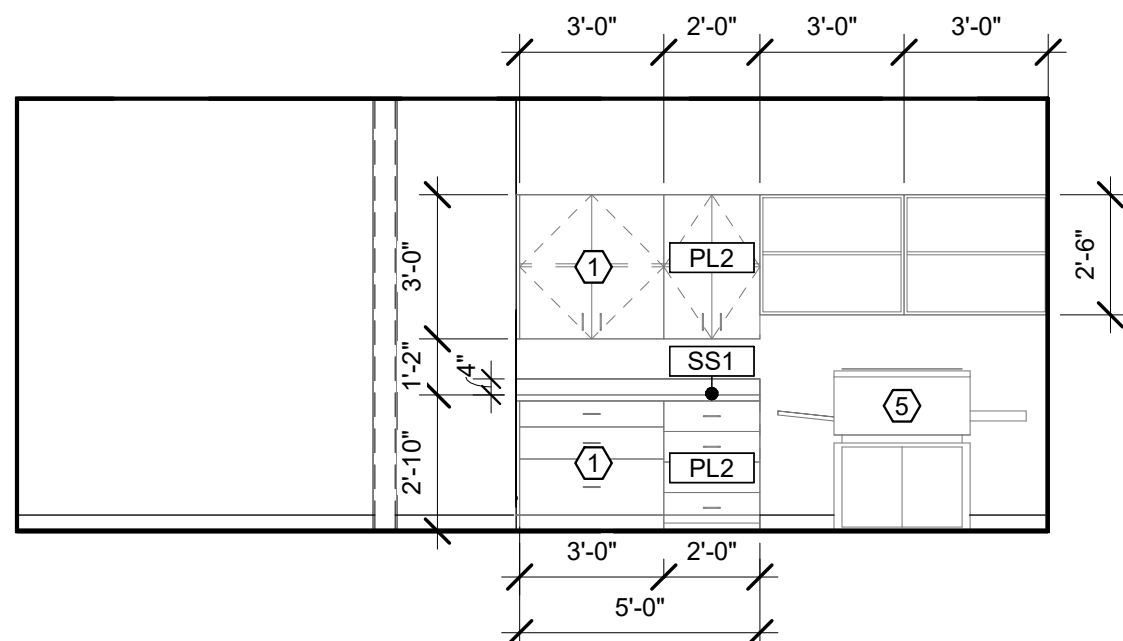


3 ADMIN SUPPORT - EAST  
A708 1/4" = 1'-0"

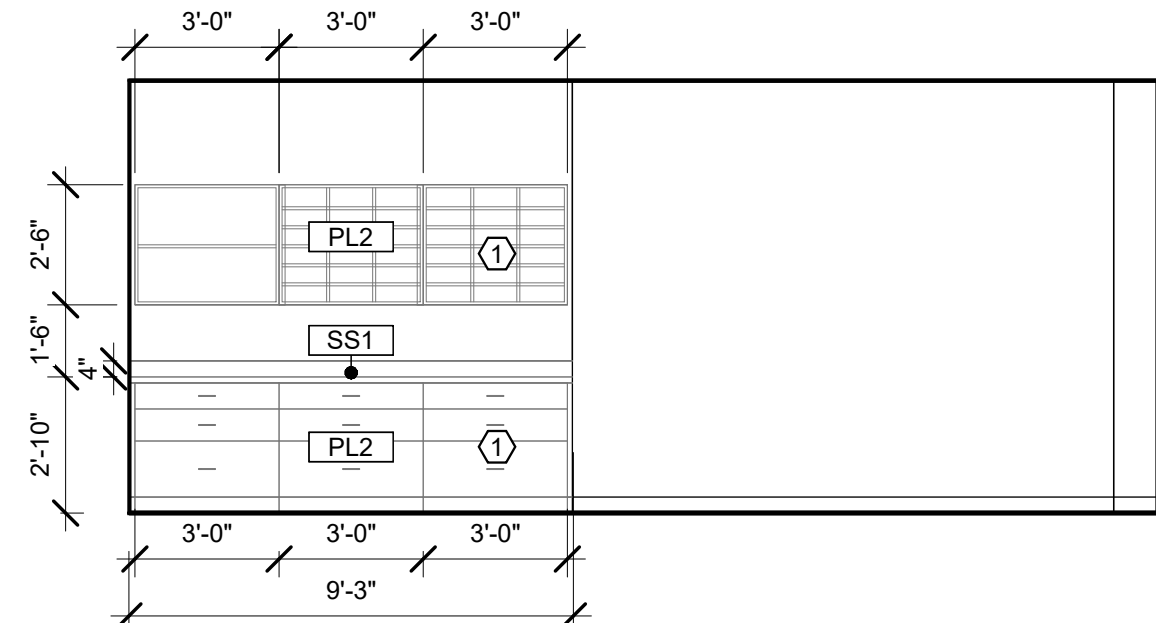


4 ADMIN SUPPORT - WEST  
A708 1/4" = 1'-0"

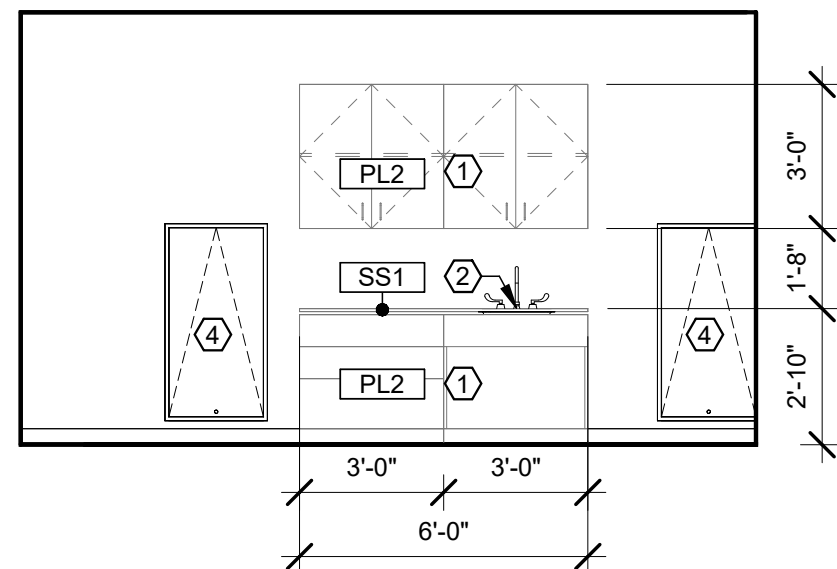

5 RESEARCH SUPPORT - NORTH  
A708 1/4" = 1'-0"

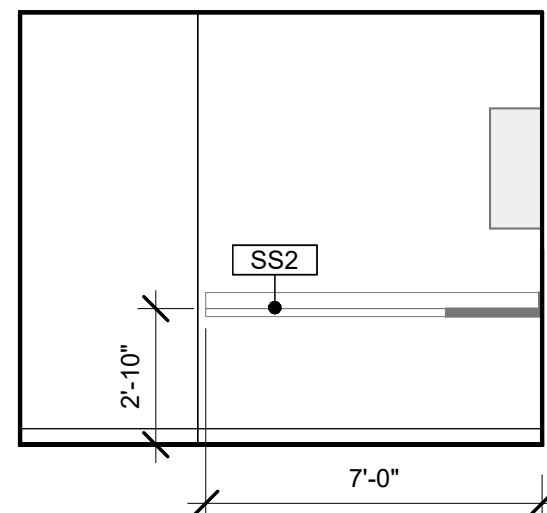


6 RESEARCH SUPPORT - EAST  
A708 1/4" = 1'-0"

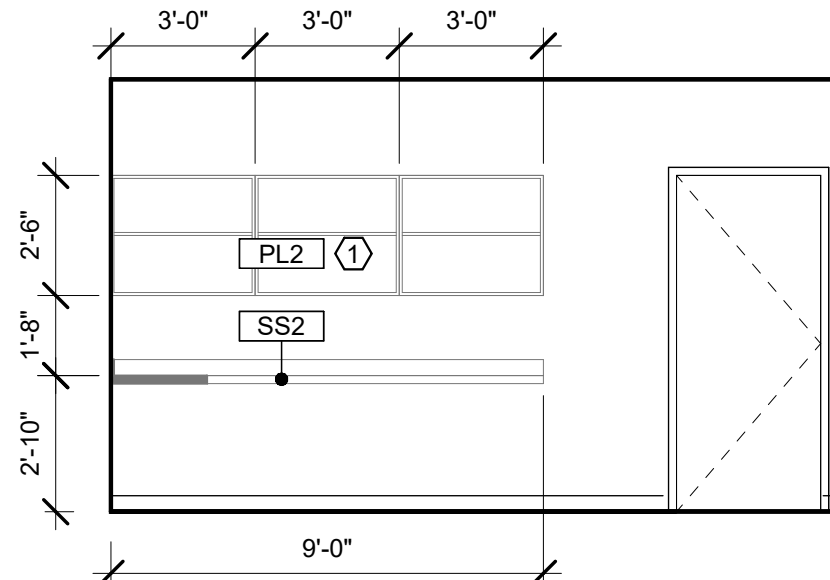

7 RESEARCH SUPPORT - SOUTH  
A708 1/4" = 1'-0"




8 CO OP WORKROOM - NORTH  
A708 1/4" = 1'-0"

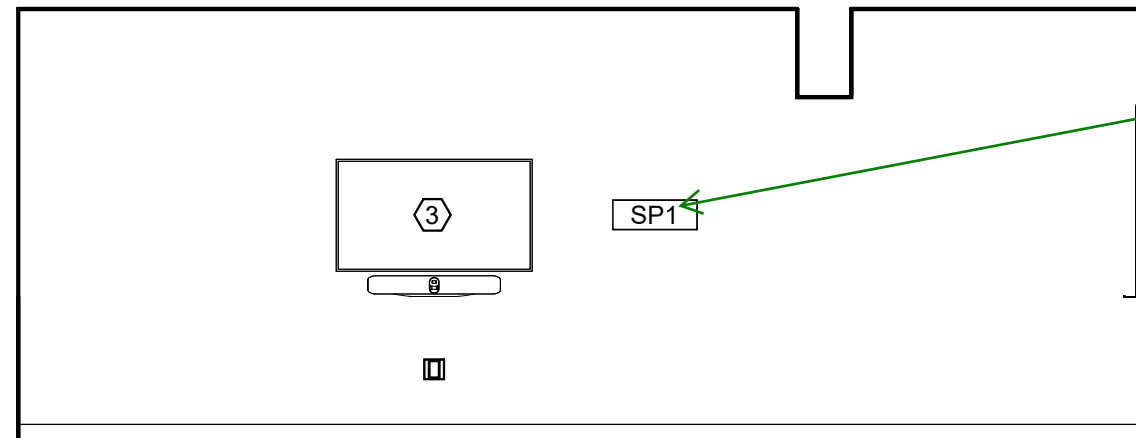

9 CO OP WORKROOM - SOUTH  
A708 1/4" = 1'-0"

## GENERAL INTERIOR ELEVATION NOTES


- SEE [A701](#) FOR TOILET AND LAV ACCESSORY SCHEDULE.
  - SEE [A503](#) FOR MATERIAL FINISH ABBREVIATION LIST.
  - PAINT ALL EXPOSED STRUCTURAL STEEL COLUMNS, CROSS BRACING, ETC. WITH 'P1' SEMI-GLOSS FINISH, UNLESS NOTED OTHERWISE.
- ### KEYNOTES
- MODULAR CASEWORK VENDOR PROVIDED, VENDOR INSTALLED. SEE SHEET [A502](#) AND MATERIAL FINISH LIST FOR PRODUCT SPECIFICATIONS.
  - FAUCET BY GC/PLUMBING SUB. COORDINATE WITH MODULAR CASEWORK VENDOR FOR INSTALLATION DIMENSIONS.
  - AV MONITOR. REFER TO AV DRAWINGS FOR MOUNTING HEIGHTS.
  - ACCESS PANEL, MOUNT FLUSH WITHIN WALL, PAINT TO MATCH ADJACENT WALL.
  - EQUIPMENT NIC. REFER TO ELECTRICAL AND MECHANICAL PLANS FOR CONNECTIONS AND HEAT LOADS.
  - OMIT COUNTERTOP BACKSPLASH AT 'TW#' LOCATIONS.

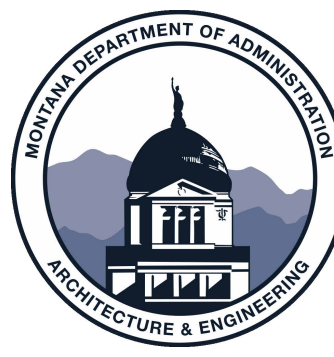

MARK & ROBYN JONES COLLEGE  
OF NURSING - BOZEMAN  
MONTANA STATE UNIVERSITY

Cushing  
Terrell  
co ARCHITECTS

|              |             |       |
|--------------|-------------|-------|
| DRAWN BY:    |             | LD    |
| REVIEWED BY: |             | MH    |
| REV.         | DESCRIPTION | DATE  |
| 1            | ADD-02      | 04.26 |
|              |             |       |
|              |             |       |

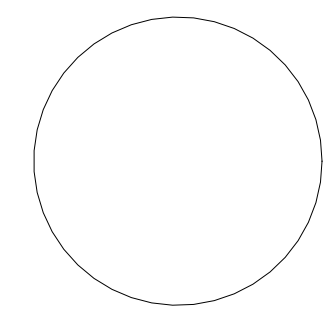

PPA#21-0167

A/E#: 2022-02-09-01

SHEET TITLE  
INTERIOR ELEVATIONS


SHEET  
A708

DATE  
03.22.2024




MATERIALS LIST - BASIS OF DESIGN

| ITEM NO         | PRODUCT TYPE                       | MANUFACTURER                     | DESCRIPTION                                                                                                    | COLOR                                                    | SIZE                                                                | NOTES                                                                                                                                                                                                          | Sustainability Notes                            |
|-----------------|------------------------------------|----------------------------------|----------------------------------------------------------------------------------------------------------------|----------------------------------------------------------|---------------------------------------------------------------------|----------------------------------------------------------------------------------------------------------------------------------------------------------------------------------------------------------------|-------------------------------------------------|
| BASE            |                                    |                                  |                                                                                                                |                                                          |                                                                     |                                                                                                                                                                                                                |                                                 |
| CB1             | COVE BASE                          | SCHLUTER SYSTEMS                 | DILEX-AHK COVE BASE                                                                                            | STAINLESS STEEL                                          | GC TO CONFIRM SIZE WITH TILE ASSEMBLY                               | TO BE USED WITH LATICRETE SPECTRALOCK EPOXY GROUT COLOR78 STERLING SILVER                                                                                                                                      | RECYCLED CONTENT, NON-EMITTING SOURCE OF VOCs   |
| RB1             | RESILIENT BASE                     | JOHNSONITE                       | MILLWORK PROFILE MONUMENT                                                                                      | PEWTER CG                                                | 4" HIGH                                                             | MITER CORNER                                                                                                                                                                                                   | EPD, FLOORSORE, CRADLE TO GATE                  |
| RB2             | RESILIENT BASE                     | JOHNSONITE                       | THERMOSET THERMOPLASTIC RUBBER COVE BASE                                                                       | PEWTER CG                                                | 4" HIGH                                                             | ROLLED GOODS                                                                                                                                                                                                   | EPD, FLOORSORE, CRADLE TO GATE                  |
| CEILING         |                                    |                                  |                                                                                                                |                                                          |                                                                     |                                                                                                                                                                                                                |                                                 |
| AC1             | ACOUSTIC CEILING                   | ARMSTRONG                        | CALLA MINERAL FIBER                                                                                            | WHITE                                                    | 2X2GRID, PRELUDE XL 15/16 SUSPENSION SYSTEM IN COLOR STANDARD WHITE | -                                                                                                                                                                                                              | EPD, HPD, DECLARE, GREENGUARD                   |
| AC3             | ACOUSTIC CEILING                   | FSORB                            | FSORB ACOUSTIC PANELING                                                                                        | WHITE                                                    | 1"THICK, 48"X96"                                                    | SEE RCPS. COORDINATE WITH MEP FIXTURES                                                                                                                                                                         | EPD, HPD, DECLARE, GREENGUARD                   |
| AC4             | ACOUSTIC CEILING                   | ARMSTRONG                        | CALLA MINERAL FIBER                                                                                            | BLACK                                                    | 2X2GRID, PRELUDE XL 15/16 SUSPENSION SYSTEM IN COLOR BLACK          | CONTROL ROOMS ONLY. SEE RCPS.COORDINATE WITH MEP FIXTURES                                                                                                                                                      | EPD, HPD, DECLARE, GREENGUARD                   |
| AL              | ALUMINUM CEILING                   | LONGBOARD                        | ENDURA LINEAR DIRECT MOUNT CEILING, 6INCH V GROOVE PLANK,                                                      | BEECHWOOD                                                | -                                                                   | SEE RCPS. COORDINATE WITH MEP FIXTURES                                                                                                                                                                         | EPD                                             |
| ALP             | ALUMINUM CEILING                   | LONGBOARD                        | ENDURA LINEAR DIRECT MOUNT CEILING, 6INCH V GROOVE PERFORATED PLANK, SOUNDTEX ACOUSTIC LINER                   | BEECHWOOD, SOUNDTEX BLACK                                | -                                                                   | SEE RCPS. COORDINATE WITH MEP FIXTURES                                                                                                                                                                         | EPD                                             |
| BF1             | BAFFLES                            | LONGBOARD                        | DAUNTLESS BAFFLE CEILING SYSTEM                                                                                | BEECHWOOD                                                | 6" HIGH BAFFLE                                                      | SEE RCPS. COORDINATE WITH MEP FIXTURES                                                                                                                                                                         | EPD                                             |
| FLOOR           |                                    |                                  |                                                                                                                |                                                          |                                                                     |                                                                                                                                                                                                                |                                                 |
| CP1             | CARPET TILE                        | MILLIKEN                         | COLLECTION: LOW COUNTRY, PATTERN: SALT MARSH                                                                   | SLM13 FRIPP                                              | 9.85"X39.4"                                                         | 33% OFFSET ASHLAR INSTALLATION                                                                                                                                                                                 | EPD, DECLARE, C2C                               |
| CP2             | CARPET TILE                        | MILLIKEN                         | COLLECTION: LOW COUNTRY, PATTERN: SEA RISE                                                                     | SRS196-13 INDIGO PLANT                                   | 9.85"X39.4"                                                         | 33% OFFSET ASHLAR INSTALLATION                                                                                                                                                                                 | EPD, DECLARE, C2C                               |
| CP3             | CARPET TILE                        | MILLIKEN                         | COLLECTION: LOW COUNTRY, PATTERN: WATERWAY                                                                     | WAT196-13 INDIGO PLANT                                   | 9.85"X39.4"                                                         | 33% OFFSET ASHLAR INSTALLATION                                                                                                                                                                                 | EPD, DECLARE, C2C                               |
| EM1             | ENTRY WALK OFF CARPET              | MILLIKEN                         | OBEX BAR TRANSITIONS RECESSED                                                                                  | DARK GREY                                                | 10.87"X39.37"                                                       | COORDINATE WITH STRUCTURE                                                                                                                                                                                      | INDOOR AIR ADVANTAGE GOLD                       |
| EM2             | ENTRY WALK OFF CARPET              | MILLIKEN                         | WALK OFF OBEX CARPET TILE                                                                                      | CUT FIZZ, DARK GREY                                      | 19.68X19.68                                                         | COORDINATE WITH STRUCTURE                                                                                                                                                                                      | INDOOR AIR ADVANTAGE GOLD                       |
| ES1             | ELECTRIC STATIC FLOOR              | STATIOWORK                       | AMERIWORX CLASSIC EDS SOLID VINYL TILE                                                                         | ADIRONDACK RIDGE                                         | 12X12                                                               | COORDINATE GROUNDING FOR COPPER WIRE WITH ELECTRICAL                                                                                                                                                           | FLOORSORE, RECYCLED CONTENT                     |
| RT1             | RESILIENT FLOORING                 | TARKETT                          | COLLECTION: COLOR WEAVE                                                                                        | THUNDER                                                  | 18X18                                                               | GLUE DOWN                                                                                                                                                                                                      | EPD, FLOORSORE, CRADLE TO GATE                  |
| SC1             | SEALED CONCRETE                    | SHERWIN WILLIAMS                 | H&C CLARISHIELD WATER-BASED CONCRETE SEALER                                                                    | NATURAL LOOK                                             | -                                                                   | -                                                                                                                                                                                                              | -                                               |
| TF1             | TILE FLOOR                         | EMSER                            | MOOD                                                                                                           | RIVER GRAY                                               | 12X23                                                               | TO BE INSTALLED WITH LATICRETE SPECTRALOCK EPOXY GROUT COLOR78 STERLING SILVER. TO BE USED WITH UNCOUPLING MEMBRANE AND EXPANSION JOINTS AS RECOMMENDED                                                        | HPD, RED LIST FREE                              |
| TF2             | TILE FLOOR                         | FLORIDA TILE                     | CANAL STREET COLLECTION                                                                                        | BLACK BAYOU                                              | 24X48                                                               | TO BE INSTALLED WITH LATICRETE SPECTRALOCK EPOXY GROUT COLOR78 STERLING SILVER. TO BE USED WITH UNCOUPLING MEMBRANE AND EXPANSION JOINTS AS RECOMMENDED                                                        | EPD, HPD, GREENGUARD                            |
| MILLWORK        |                                    |                                  |                                                                                                                |                                                          |                                                                     |                                                                                                                                                                                                                |                                                 |
| FB1             | FABRIC UPHOLSTERY                  | ANZEA                            | KAPOW COLLECTION                                                                                               | SWISH                                                    | SEE ELEVATIONS AND RENDERING FOR DESIGN INTENT                      | SEAT CUSHION. GC TO PROVIDE SHOP DRAWINGS FOR FINAL APPROVAL                                                                                                                                                   | HPD, REDLIST FREE                               |
| FB2             | FABRIC UPHOLSTERY                  | LUUM                             | EQUILUX 4060                                                                                                   | BLUE HOUR                                                | SEE ELEVATIONS AND RENDERING FOR DESIGN INTENT                      | BACK CUSHION. GC TO PROVIDE SHOP DRAWINGS FOR FINAL APPROVAL                                                                                                                                                   | HEAVY METAL FREE                                |
| HD1             | HARDWARE: MODULAR CASEWORK         | CAROLINA MILEMARKER              | GRIP CABINET PULL, ADA COMPLIANT                                                                               | SATIN NICKEL                                             | -                                                                   | TO BE INSTALLED WITH MODULAR CASEWORK, CONTACT: Jared.B@cdcollective.com WITH CONTRACT DESIGN                                                                                                                  | -                                               |
| PL1             | PLASTIC LAMINATE: CUSTOM MILLWORK  | WILSONART                        | HPL BLOND ECHO LINEARITY FINISH                                                                                | 7939K-18                                                 | -                                                                   | ALL MILLWORK SURFACES TO BE MATCHING WOOD GRAIN LOOK, NO MELAMINE                                                                                                                                              | HPD, INDOOR AIR ADVANTAGE GOLD, GREENGUARD GOLD |
| PL2             | PLASTIC LAMINATE: MODULAR CASEWORK | CAROLINA-OFS                     | HPL LINEN (WOOD LOOK)                                                                                          | OFS STANDARD LAMINATE                                    | -                                                                   | ALL MILLWORK SURFACES TO BE MATCHING WOOD GRAIN LOOK, NO MELAMINE, CONTACT: Jared.B@cdcollective.com WITH CONTRACT DESIGN                                                                                      | INDOOR AIR ADVANTAGE GOLD                       |
| PL3             | PLASTIC LAMINATE: CUSTOM MILLWORK  | WILSONART                        | HPL LINEN (WHITE)                                                                                              | D427-60 MATTE FINISH                                     | -                                                                   | ALL MILLWORK SURFACES TO BE MATCHING WOOD GRAIN LOOK, NO MELAMINE                                                                                                                                              | HPD, INDOOR AIR ADVANTAGE GOLD, GREENGUARD GOLD |
| OZ1             | QUARTZ SURFACE                     | EVERO QUARTZ BY BRADLEY          | GEO SERIES                                                                                                     | ANDORRA                                                  | SEE PLUMBING SPECIFICATIONS                                         | RESTROOM TROUGH SINK. SEE PLUMBING FOR DETAILS                                                                                                                                                                 | GREENGUARD GOLD                                 |
| SS1             | SOLID SURFACE: MODULAR CASEWORK    | CAROLINA-OFS                     | LIVINGSTONE SURFACES, SNOWFALL                                                                                 | L213                                                     | -                                                                   | MITERED CORNERS, EASED EDGES, CONTACT: Jared.B@cdcollective.com WITH CONTRACT DESIGN                                                                                                                           | HPD, GREENGUARD                                 |
| SS2             | SOLID SURFACE: MODULAR CASEWORK    | GC TO PROVIDE/ CUSTOM MILLWORKER | LIVINGSTONE SURFACES, SNOWFALL                                                                                 | L213                                                     | -                                                                   | MITERED CORNERS, EASED EDGES, CONTACT: Jared.B@cdcollective.com WITH CONTRACT DESIGN                                                                                                                           | HPD, GREENGUARD                                 |
| MISC.           |                                    |                                  |                                                                                                                |                                                          |                                                                     |                                                                                                                                                                                                                |                                                 |
| AC2             | ACOUSTIC ARCHITECTURAL ELEMENT     | TURF DESIGNS                     | ARCHITECTURAL ELEMENT: PATTERN FRACTAL, CLASS A                                                                | SHELL HOUSING COLOR: DAMASCAS 09, INSERTS: LIGHT 04 GREY | MODULAR CLOUD, 36"X36"                                              | SEE RCP, DETAILS, AND ELEVATIONS FOR DESIGN INTENT. COORDINATE WITH MECHANICAL, ELECTRICAL AND STRUCTURAL SYSTEMS. INSTALLER TO USE RECOMMENDED THREADED ROD CONNECTION. CONTACT: jordan@absolute-resource.com | HPD, DECLARE                                    |
| AP1             | ACOUSTIC PRODUCTS                  | KIREI                            | SOLID WALL PANEL                                                                                               | 442 GREY                                                 | SHEET SIZE 9'X4'X1/2"THICK                                          | Z-CLIP MOUNT. SEE ELEVATIONS FOR DESIGN INTENT AND SIZING                                                                                                                                                      | HPD                                             |
| AP1.1           | ACOUSTIC PRODUCTS                  | KIREI                            | SOLID WALL PANEL                                                                                               | 660 CORONET                                              | SHEET SIZE 9'X4'X1/2"THICK                                          | Z-CLIP MOUNT. SEE ELEVATIONS FOR DESIGN INTENT AND SIZING                                                                                                                                                      | HPD                                             |
| AP2             | ACOUSTIC PRODUCTS                  | MOMENTUM TEXTILES                | NUFELT MANCHESTER ACOUSTIC WALLCOVERING. PATTERN TO RUN VERTICAL, MATCH SEAMS.                                 | WISHFUL THINKING                                         | 0.12" THICK X 63" WIDE ROLL                                         | ADHESIVE MOUNT. PROVIDE METAL TRANSITION ON ALL EXPOSED EDGES.GC TO PROVIDE SHOP DRAWINGS FOR FINAL APPROVAL                                                                                                   | HPD, GREENGUARD, RECYCLED CONTENT               |
| AP3             | ACOUSTIC PRODUCTS                  | KIREI                            | GROOVY 3.0 PANELS                                                                                              | NAVY 365                                                 | SHEET SIZE: 110 X 44 NOOKS                                          | SEE ELEVATIONS AND DETAILS FOR DESIGN INTENT. COORDINATE FITTING WITH ELECTRICAL AND FIRE PROTECTION. TO BE USED WITH TRANSITION EDGE #LVT908EBRZ                                                              | EPD, HPD, DECLARE, RECYCLED CONTENT             |
| AP4             | ACOUSTIC PRODUCTS                  | ACOUFELT                         | FRACTURE TWO-TONE: RAINDROP PANEL                                                                              | PANEL COLOR: MARINE, REVEAL COLOR: POPCORN               | ANNODIZED                                                           | SEE ELEVATIONS AND DETAILS FOR DESIGN INTENT. COORDINATE FITTING WITH ELECTRICAL AND FIRE PROTECTION                                                                                                           | DECLARE, SCS INDOOR ADVANTAGE GOLD              |
| AP4.1           | ACOUSTIC PRODUCTS                  | ACOUFELT                         | FRACTURE TWO-TONE: RAINDROP PANEL                                                                              | PANEL COLOR: GREY 442, REVEAL COLOR: 447 SLATE           | ANNODIZED                                                           | SEE ELEVATIONS AND DETAILS FOR DESIGN INTENT. COORDINATE FITTING WITH ELECTRICAL AND FIRE PROTECTION                                                                                                           | DECLARE, SCS INDOOR ADVANTAGE GOLD              |
| CC1             | CUBICLE CURTAIN                    | KNOLL                            | FABRIC PATTERN SIGNAL, MESH: WHITE, ACCESSORIES AND TRACK PROVIDED BY GC                                       | FABRIC: COASTLINE, MESH: WHITE, GROMMETS:WHITE OR CLEAR  | SEE ELEVATIONS AND RENDERING FOR DESIGN INTENT                      | OMBRE STRIPES TO RUN HORIZONTAL. GC TO PROVIDE SHOP DRAWINGS FOR FINAL APPROVAL. SEE RCP AND DETAILS FOR HANGING STRUCTURE                                                                                     | FREE OF INTENTIONALLY ADDED PFAS                |
| LK1             | LOCKERS                            | CAROLINA MILEMARKER              | 2 TIER STORAGE LOCKER, BATTERY OPERATED LOCKS, PULL: RECESSED. INCLUDE 2 PRONG COAT HOOKS                      | HPL LINEN (WOOD LOOK), PULL: SATIN NICKEL                | SEE ELEVATIONS                                                      | -                                                                                                                                                                                                              | INDOOR AIR ADVANTAGE GOLD                       |
| LK1.1           | LOCKERS                            | CAROLINA MILEMARKER              | OPEN CUBBIES                                                                                                   | HPL LINEN (WOOD LOOK), PULL: SATIN NICKEL                | SEE ELEVATIONS                                                      | CONFIRM QTY AND SIZE OF OPEN CUBBIES WITH CLIENT PRIOR TO APPROVAL                                                                                                                                             | INDOOR AIR ADVANTAGE GOLD                       |
| WF1             | PRIVACY WINDOW FILM                | TAKEFORM                         | DUAL FADE FROSTED CUSTOM PATTERN                                                                               | FROSTED                                                  | 60 INCH BAND TO START 2FT FROM BOTTOM OF DOOR                       | GC TO PROVIDE SHOP DRAWINGS FOR APPROVAL. GC TO PROVIDE MOCKUP PRIOR TO ORDERING.                                                                                                                              | -                                               |
| WH1             | WHITEBOARD                         | CLARUS                           | FLOAT : BACKPAINTED MAGNETIC GLASSBOARD                                                                        | WHITE                                                    | SEE ELEVATIONS                                                      | REFER TO DETAIL FOR INSTALLATION. INCLUDE MARKERS, HANGERS, AND ALL ACCESSORIES                                                                                                                                | EPD, DECLARE                                    |
| WS1             | WINDOW SHADES                      | LUTRON                           | MANUAL ROLLER SHADES: CONTRACT ROLLER MANUAL                                                                   | FASCIA: TBD, FABRIC: 1% OPEN WEAVE, COLOR: TBD           | FIELD VERIFY ON SITE                                                | -                                                                                                                                                                                                              | -                                               |
| WS3             | WINDOW SHADES                      | LUTRON                           | MANUAL DUAL ROLLER SHADE: CONTRACT ROLLER MANUAL                                                               | FASCIA: TBD, FABRIC: 1% OPEN WEAVE, COLOR: TBD           | FIELD VERIFY ON SITE                                                | -                                                                                                                                                                                                              | -                                               |
| TRANSITIONS     |                                    |                                  |                                                                                                                |                                                          |                                                                     |                                                                                                                                                                                                                |                                                 |
| TR1             | TRANSITION PROFILE                 | SCHLUTER SYSTEMS                 | CARPET TO TILE: SCHIENE                                                                                        | STAINLESS STEEL                                          | GC TO CONFIRM SIZES WITH MATERIAL THICKNESS                         | SEE ARCHITECTURAL DETAIL.                                                                                                                                                                                      | RECYCLED CONTENT, NON-EMITTING SOURCE OF VOCs   |
| TR2             | TRANSITION PROFILE                 | FUTURA TRANSITIONS               | CARPET TO RESILIENT: CARPET TO LVT PROFILE                                                                     | ETCHED ALUMINUM                                          | GC TO CONFIRM SIZES WITH MATERIAL THICKNESS                         | SEE ARCHITECTURAL DETAIL.                                                                                                                                                                                      | REACH / ROHS COMPLIANT                          |
| TR3             | TRANSITION PROFILE                 | FUTURA TRANSITIONS               | CARPET TO CONCRETE: DELUXE BINDER BAR                                                                          | ETCHED ALUMINUM                                          | GC TO CONFIRM SIZES WITH MATERIAL THICKNESS                         | SEE ARCHITECTURAL DETAIL.                                                                                                                                                                                      | REACH / ROHS COMPLIANT                          |
| TR4             | TRANSITION PROFILE                 | SCHLUTER SYSTEMS                 | RESILIENT TO TILE: RENO-U                                                                                      | STAINLESS STEEL                                          | GC TO CONFIRM SIZES WITH MATERIAL THICKNESS                         | SEE ARCHITECTURAL DETAIL.                                                                                                                                                                                      | RECYCLED CONTENT, NON-EMITTING SOURCE OF VOCs   |
| TR5             | TRANSITION PROFILE                 | FUTURA TRANSITIONS               | RESILIENT TO CONCRETE: COVING CAP                                                                              | ETCHED ALUMINUM                                          | GC TO CONFIRM SIZES WITH MATERIAL THICKNESS                         | SEE ARCHITECTURAL DETAIL.                                                                                                                                                                                      | REACH / ROHS COMPLIANT                          |
| TR6             | TRANSITION PROFILE                 | FUTURA TRANSITIONS               | TILE TO CONCRETE: CERAMIC REDUCER EDGETEK U SHAPED                                                             | ETCHED ALUMINUM                                          | GC TO CONFIRM SIZES WITH MATERIAL THICKNESS                         | SEE ARCHITECTURAL DETAIL.                                                                                                                                                                                      | REACH / ROHS COMPLIANT                          |
| TR7             | TRANSITION PROFILE                 | FUTURA TRANSITIONS               | FELT METAL EDGE FOR AP3                                                                                        | #LVT 908 EBLK                                            | GC TO CONFIRM SIZES WITH MATERIAL THICKNESS                         | -                                                                                                                                                                                                              | REACH / ROHS COMPLIANT                          |
| TR8             | TRANSITION PROFILE                 | FUTURA TRANSITIONS               | FELT METAL EDGE FOR AP2: BEVEL CAP                                                                             | 4MM, #LVT 906 EBLK                                       | GC TO CONFIRM SIZES WITH MATERIAL THICKNESS                         | -                                                                                                                                                                                                              | REACH / ROHS COMPLIANT                          |
| TR9             | TRANSITION PROFILE                 | TBD                              | WALL PROTECTION EDGE -LABS                                                                                     | STAINLESS STEEL                                          | GC TO CONFIRM SIZES WITH MATERIAL THICKNESS                         | -                                                                                                                                                                                                              | -                                               |
| TR10            | TRANSITION PROFILE                 | SCHLUTER SYSTEMS                 | WALL TILE EDGE + CORNERS: FINEC-SQ - ALL EXPOSED EDGES, OUTSIDE CORNERS                                        | STAINLESS STEEL                                          | GC TO CONFIRM SIZES WITH MATERIAL THICKNESS                         | -                                                                                                                                                                                                              | RECYCLED CONTENT, NON-EMITTING SOURCE OF VOCs   |
| TR11            | TRANSITION PROFILE                 | FUTURA TRANSITIONS               | VENEER PLYWOOD EDGE - NOOKS: COVING CAP 1/8" OR 3/32"                                                          | EBLK                                                     | GC TO CONFIRM SIZES WITH MATERIAL THICKNESS                         | -                                                                                                                                                                                                              | REACH / ROHS COMPLIANT                          |
| TR12            | TRANSITION PROFILE                 | VARIES                           | STAIR TREAD TRANSITION                                                                                         | STAINLESS STEEL                                          | GC TO CONFIRM SIZES WITH MATERIAL THICKNESS                         | -                                                                                                                                                                                                              | -                                               |
| WALL            |                                    |                                  |                                                                                                                |                                                          |                                                                     |                                                                                                                                                                                                                |                                                 |
| EP1             | EPOXY PAINT                        | SHERWIN WILLIAMS                 | PRO-INDUSTRIAL WATERBASED CATALYZED EPOXY                                                                      | SW7566 WESTHIGHLAND WHITE                                | CEILINGS: FLAT FINISH, WALLS EG-SHEL FINISH                         | GC TO PROVIDE LOW/NO VOC PAINT                                                                                                                                                                                 | -                                               |
| EP2             | PAINT                              | SHERWIN WILLIAMS                 | PRO-INDUSTRIAL WATERBASED CATALYZED EPOXY                                                                      | SW7609 GEORGIAN REVIVAL BLUE                             | CEILINGS: FLAT FINISH, WALLS EG-SHEL FINISH                         | GC TO PROVIDE LOW/NO VOC PAINT                                                                                                                                                                                 | -                                               |
| P1              | PAINT                              | SHERWIN WILLIAMS                 | ZERO VOC HARMONY INTERIOR LATEX PAINT                                                                          | SW7566 WESTHIGHLAND WHITE                                | CEILINGS: FLAT FINISH, WALLS EG-SHEL FINISH                         | GC TO PROVIDE LOW/NO VOC PAINT                                                                                                                                                                                 | -                                               |
| P2              | PAINT                              | SHERWIN WILLIAMS                 | ZERO VOC HARMONY INTERIOR LATEX PAINT                                                                          | SW7609 GEORGIAN REVIVAL BLUE                             | CEILINGS: FLAT FINISH, WALLS EG-SHEL FINISH                         | GC TO PROVIDE LOW/NO VOC PAINT                                                                                                                                                                                 | -                                               |
| P3              | PAINT                              | SHERWIN WILLIAMS                 | ZERO VOC HARMONY INTERIOR LATEX PAINT                                                                          | SW7506 VAST SKY                                          | CEILINGS: FLAT FINISH, WALLS EG-SHEL FINISH                         | GC TO PROVIDE LOW/NO VOC PAINT                                                                                                                                                                                 | -                                               |
| P4              | PAINT                              | SHERWIN WILLIAMS                 | ZERO VOC HARMONY INTERIOR LATEX PAINT                                                                          | SW7072 ONLINE                                            | CEILINGS: FLAT FINISH, WALLS EG-SHEL FINISH                         | GC TO PROVIDE LOW/NO VOC PAINT                                                                                                                                                                                 | -                                               |
| P5              | PAINT                              | SHERWIN WILLIAMS                 | ZERO VOC HARMONY INTERIOR LATEX PAINT                                                                          | SW7075 WEB GRAY                                          | CEILINGS: FLAT FINISH, WALLS EG-SHEL FINISH                         | GC TO PROVIDE LOW/NO VOC PAINT                                                                                                                                                                                 | -                                               |
| SP1             | SPECIALITY PAINT/COATING           | GC SIGNAGE VENDOR TO PROVIDE     | CUSTOM GRAPHIC ON TYPE III TERRALON VINYL                                                                      | CUSTOM IMAGERY                                           | SEE ELEVATIONS AND RENDERING FOR DESIGN INTENT                      | WALLS RECEIVING GRAPHIC TO HAVE A LEAST 50% GYP FINISH. PROVIDE MOCKUP TO DESIGNER FOR APPROVAL. GC TO PROVIDE DESIGN INTENT                                                                                   | -                                               |
| TW1             | TILE WALL                          | EMSER                            | COUNCIL                                                                                                        | GRAY                                                     | 12X24                                                               | TO BE INSTALLED WITH LATICRETE SPECTRALOCK EPOXY GROUT COLOR78 STERLING SILVER                                                                                                                                 | HPD, RED LIST FREE                              |
| TW2             | TILE WALL                          | UNITED TILE                      | PORTOBELLO MIX OF LIGHTHOUSE SEA 70% AND LIGHTHOUSE STAIRS SEA 30%                                             | SEA                                                      | 2X10                                                                | NOURISHMENT. TO BE INSTALLED WITH LATICRETE SPECTRALOCK EPOXY GROUT IN COLOR53 TWILIGHT BLUE                                                                                                                   | -                                               |
| TW3             | TILE WALL                          | DALTILE                          | REVALIA REMIX RECTANGULAR RIPPLE                                                                               | RIPPLE WHITE                                             | 2X8                                                                 | TO BE INSTALLED WITH LATICRETE SPECTRALOCK EPOXY GROUT COLOR78 STERLING SILVER                                                                                                                                 | DECLARE, LBC RED LIST FREE                      |
| WC1             | WALLCOVERING                       | P3TEC                            | STELLAR                                                                                                        | P3T-60128 WHITE OUT                                      | 4' ROLL                                                             | INSTALL ABOVE WALL BASE. TO BE USED IN CONJUNCTION WITH MANUFACTURERS STANDARD TOP CAP AND MATCHING CORNER GUARDS. ARCHITECT TO SELECT COLOR FROM STANDARD RANGE                                               | EPD,HPD                                         |
| WDW1            | WOOD WALL & SOFFIT                 | GC TO PROVIDE/ CUSTOM MILLWORKER | RIFT SAWN WHITE OAK, POLYURETHANE FINISH, TO MATCH ARCHITECTS SAMPLE IN SPECIEIS, STAIN, GRAINING, AND TEXTURE | GC TO PROVIDE A RANGE OF SAMPLES                         | -                                                                   | SEE DETAILS, ELEVATIONS, AND SECTIONS FOR DESIGN INTENT                                                                                                                                                        | -                                               |
| WALL PROTECTION |                                    |                                  |                                                                                                                |                                                          |                                                                     |                                                                                                                                                                                                                |                                                 |
| CG1             | CORNER GUARD                       | C.S. ACROVYN                     | SSM-20                                                                                                         | WHITE, SUEDE FINISH                                      | 2" WINGS, FULL HEIGHT                                               | CG1 TO START AT TOP OF BASE.                                                                                                                                                                                   | EPD                                             |
| CH1             | CHAIR RAIL                         | CS ACROVYN                       | SCR-40 SURFACE MOUNTED                                                                                         | WHITE, SUEDE FINISH                                      | 4" HIGH                                                             | SEE ELEVATIONS FOR DESIGN INTENT AND SIZING                                                                                                                                                                    | EPD                                             |
| FRP1            | FIBERGLASS REINFORCED PANEL        | MARLITE                          | STANDARD FRP                                                                                                   | WHITE, PEBBLE FINISH                                     | 4'X8'                                                               | FRP TO START AT TOP OF BASE                                                                                                                                                                                    | GREENGUARD GOLD                                 |
| WP1             | WALL PROTECTION                    | CONSTRUCTION SPECIALTIES         | ACROVYN WALL PROTECTION RIGID SHEET                                                                            | WHITE, SUEDE FINISH                                      | 4'X8'                                                               | INSTALL ABOVE FINISHED FLOOR; WALL BASE TO BE INSTALLED ON TOP OF WP#1 PANEL.                                                                                                                                  | EPD, CRADLE TO CRADLE                           |

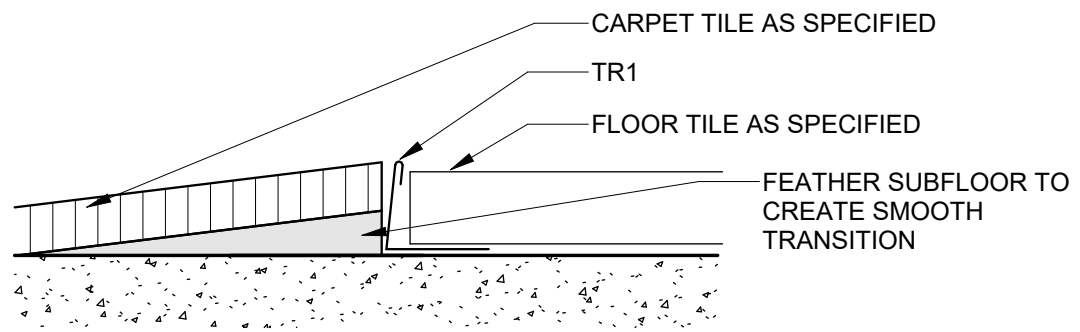


1  
A503  
12" = 1'-0"

INTERIOR DETAIL - TR1 CARPET TO FLOOR TILE

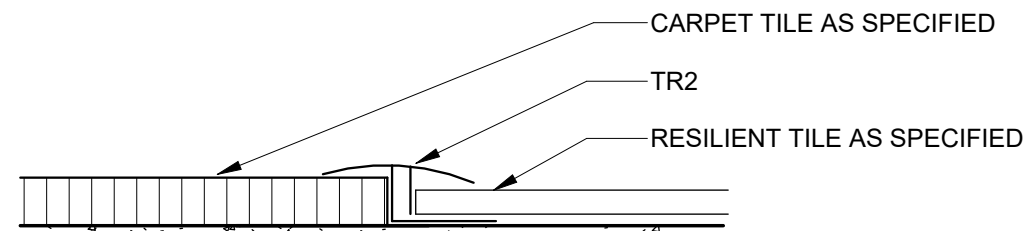


2  
A503  
12" = 1'-0"

INTERIOR DETAIL - TR2 CARPET TO RESILIENT

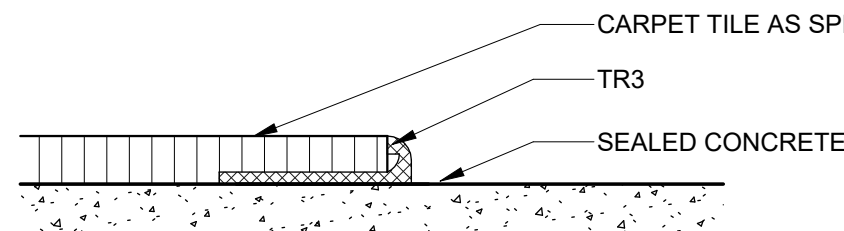


3  
A503  
12" = 1'-0"

INTERIOR DETAIL - TR3 CARPET TO CONCRETE

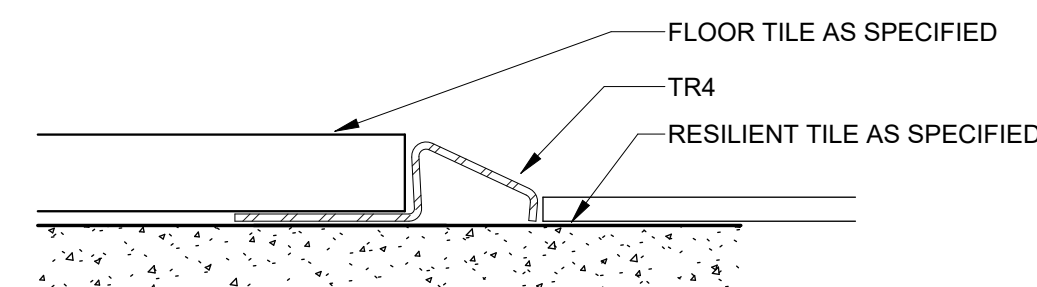


4  
A503  
12" = 1'-0"

INTERIOR DETAIL - TR4 RESILIENT TO FLOOR TILE

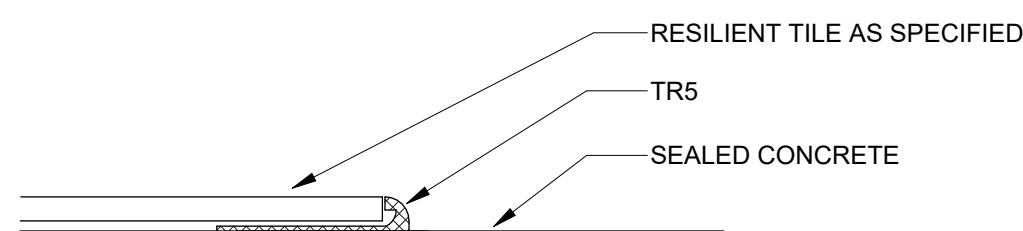


5  
A503  
12" = 1'-0"

INTERIOR DETAIL - TR5 RESILIENT TO CONCRETE

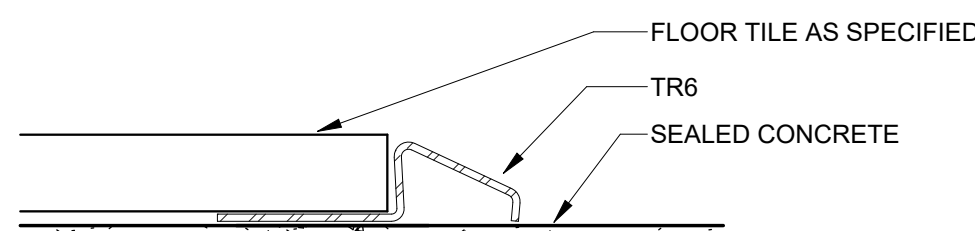


6  
A503  
12" = 1'-0"

INTERIOR DETAIL - TR6 FLOOR TILE TO CONCRETE

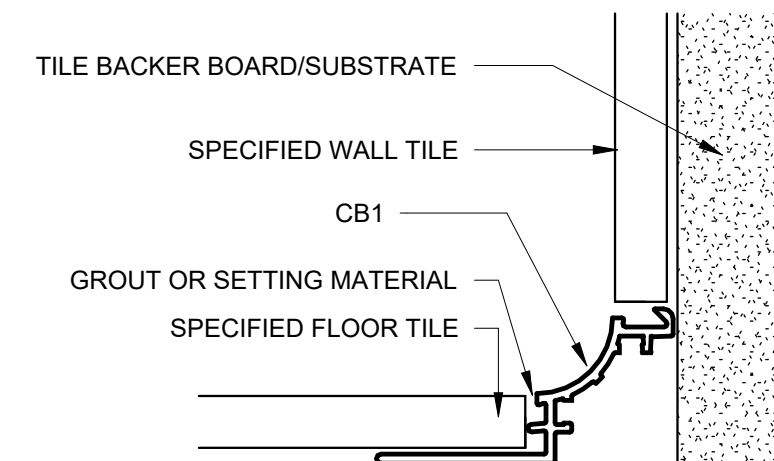

7  
A503  
12" = 1'-0"

INTERIOR DETAIL - TILE COVE BASE

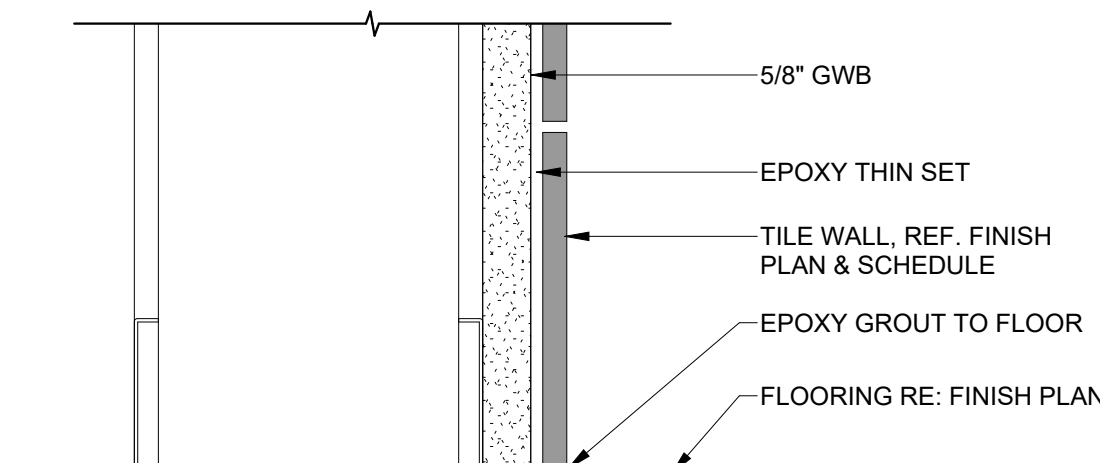


8  
A503  
6\"/>



MARK & ROBYN JONES COLLEGE  
OF NURSING - BOZEMAN  
MONTANA STATE UNIVERSITY

Cushing  
Terrell  
co ARCHITECTS

|              |             |          |
|--------------|-------------|----------|
| DRAWN BY:    |             | LD       |
| REVIEWED BY: |             | MH       |
| REV.         | DESCRIPTION | DATE     |
| 1            | ADD-02      | 04.26.24 |
| 7            | PR-01       | 08.07.24 |
| 13           | PR05        | 10.04.24 |
|              |             |          |
|              |             |          |

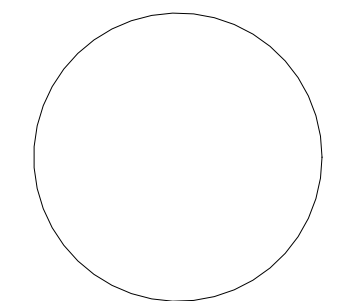

PPA#21-0167


A/E#: 2022-02-09-01

SHEET TITLE  
INTERIOR MATERIAL  
LIST AND DETAILS

SHEET  
A503

DATE  
03.22.2024



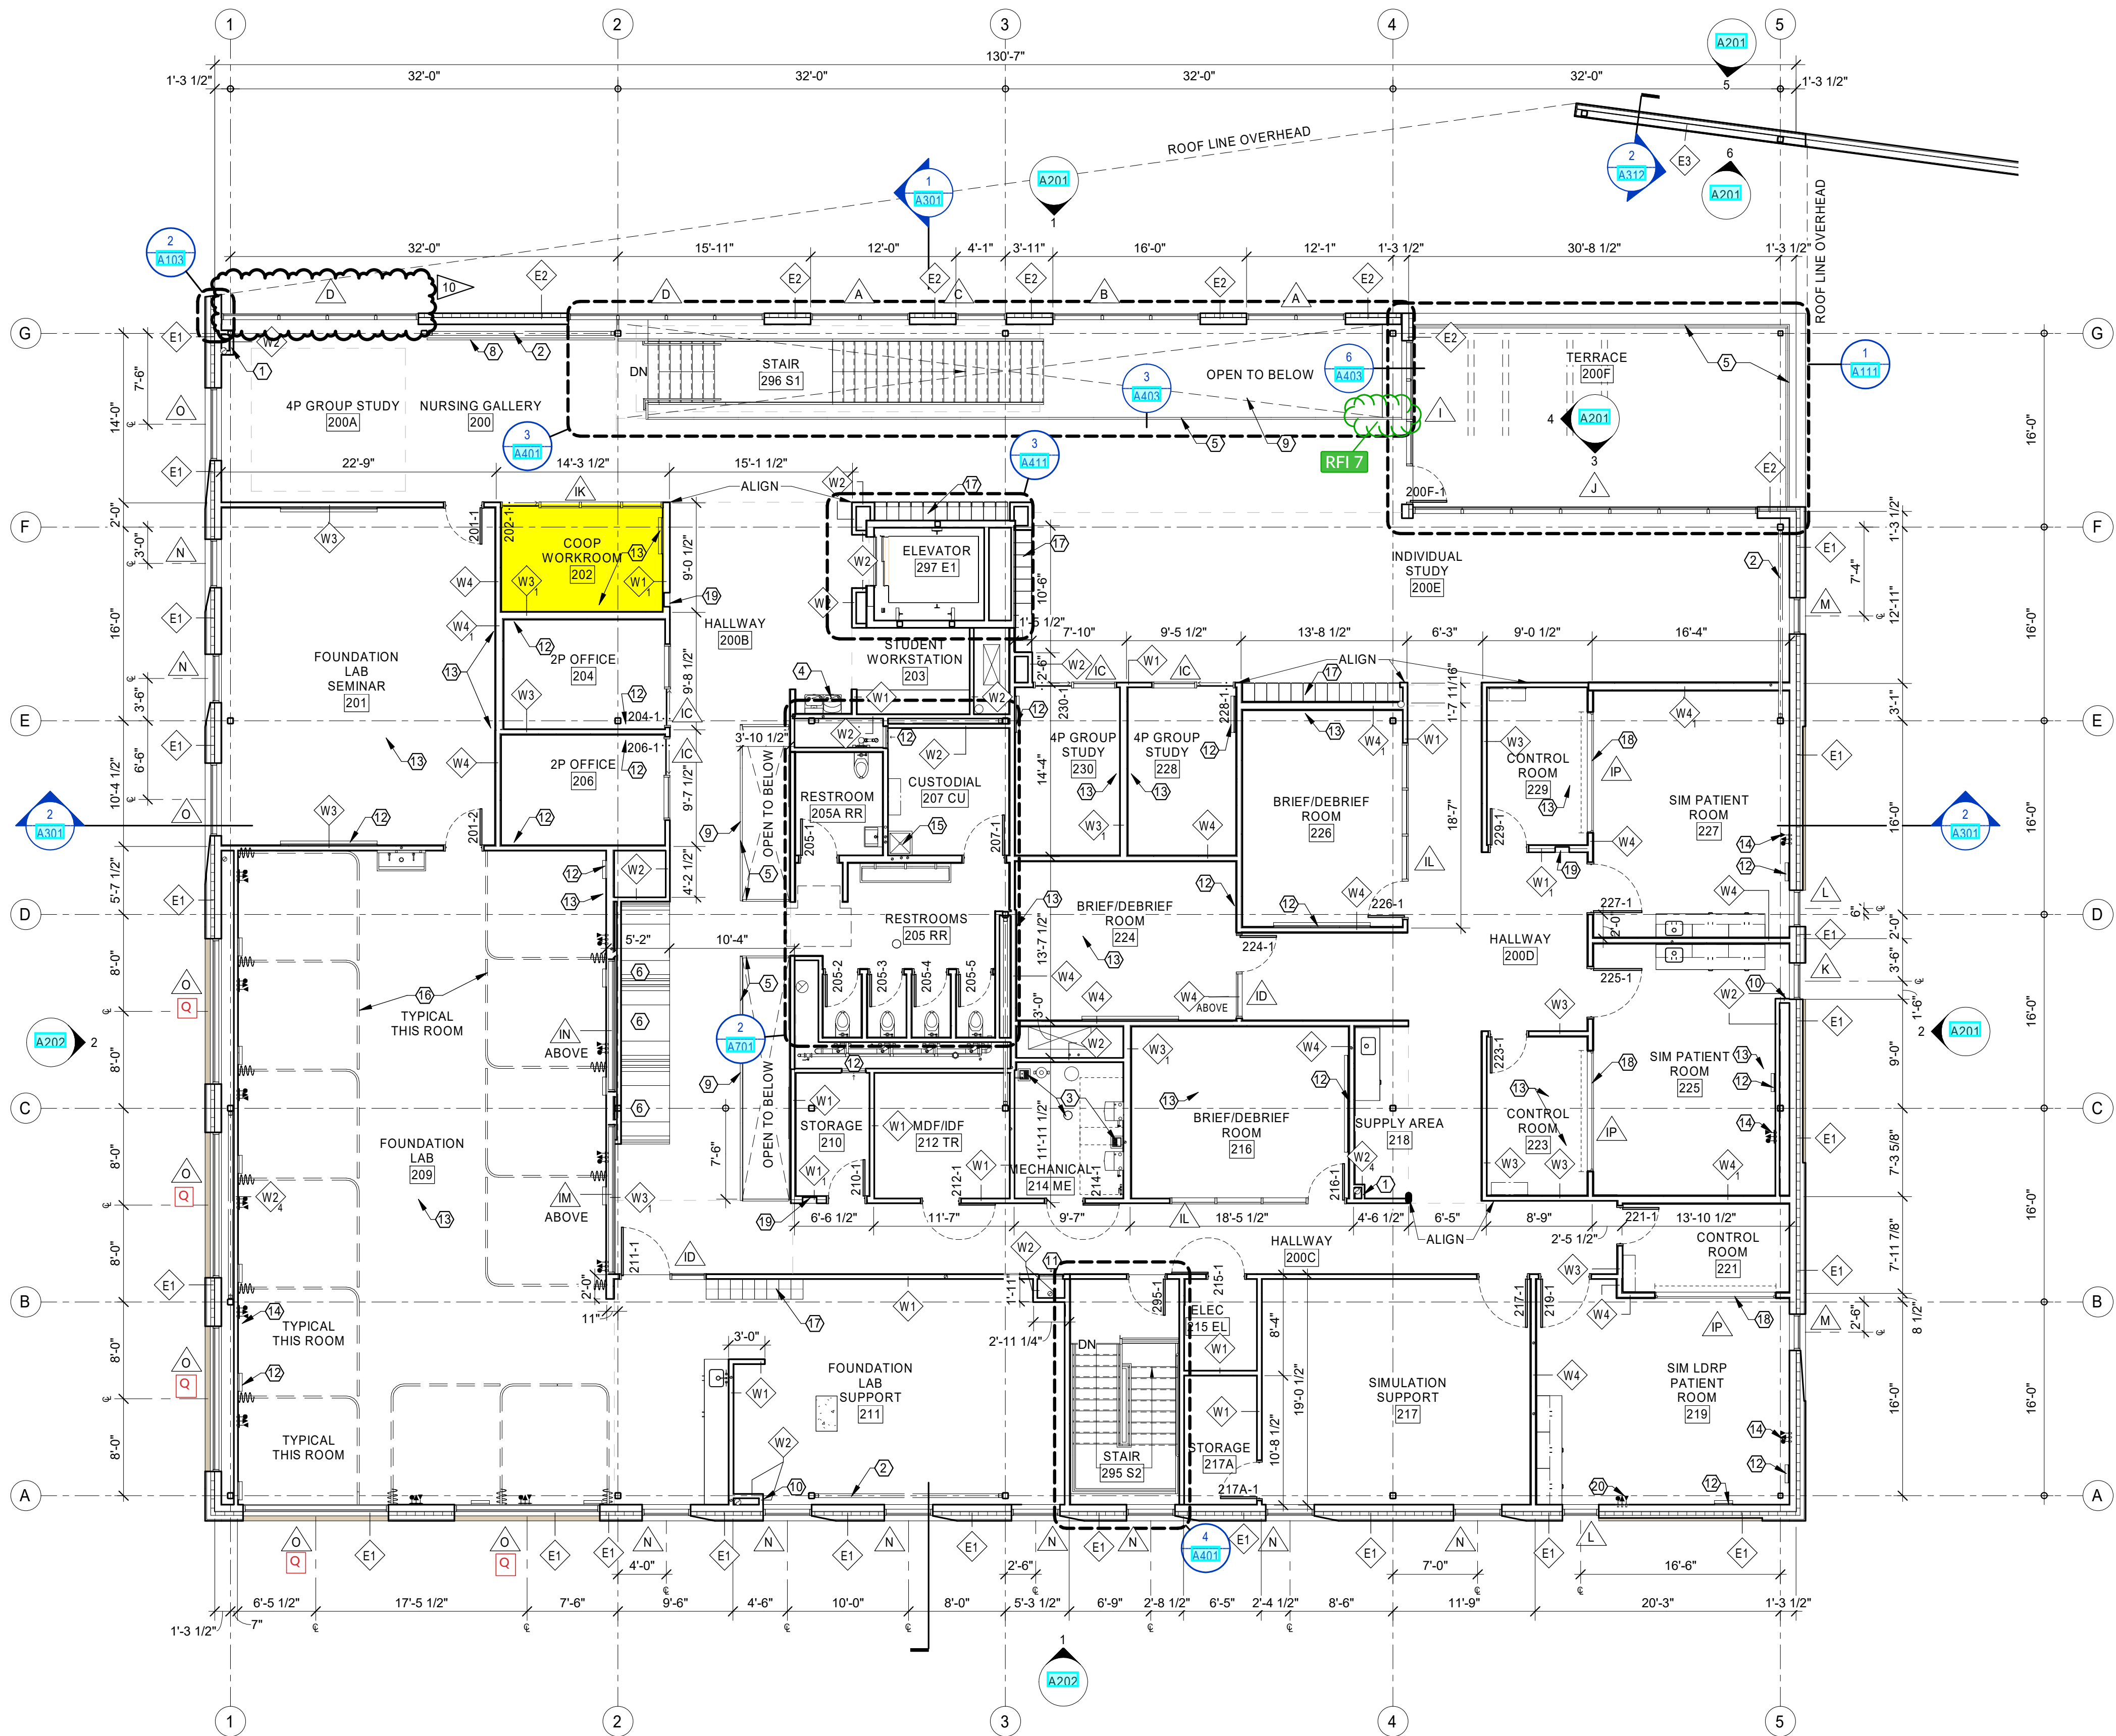

1 SECOND FLOOR  
A102 1/8" = 1'-0"



PLAN LEGEND

- W## ASSEMBLY TYPE (SEE ASSEMBLIES SHEET)
- NAME ROOM NAME AND NUMBER
- X WINDOW TYPE (SEE A600s)
- X KEYNOTE
- 1 SIM DIRECTION OF VIEW, IF APPLICABLE
- 1 DRAWING NUMBER
- X000 SHEET WHERE DRAWN
- 101-1 DOOR NUMBER (SEE SHEET A601)
- DIMENSION TO FACE OF FRAMING
- DIMENSION TO GRID LINE
- DIMENSION TO CENTER LINE

GENERAL PLAN NOTES

- A. INTERIOR ELEVATION MARKERS CAN BE FOUND ON SHEETS A501 AND A502.
- B. SEE A500 SHEETS FOR ALL FINISH REQUIREMENTS & SPECIFICATIONS.
- C. SEE A600 SHEETS FOR WINDOW AND DOOR SCHEDULES
- D. SEE A700 SHEETS FOR INTERIOR ELEVATIONS
- E. COORDINATE WITH BUILDING SECTIONS AND STRUCTURAL DRAWINGS FOR FINISH FLOOR ELEVATIONS
- F. SEE G100 SHEETS REGARDING BUILDING CODE REQUIREMENTS.
- G. SEE SHEET A602 FOR TYPICAL EXTERIOR AND INTERIOR WALL TYPE ASSEMBLIES
- H. SEE A800 SHEETS FOR REFLECTED CEILING PLANS AND DETAILS
- I. PROVIDE FIRE RETARDANT TREATED BLOCKING IN WALL FOR ALL MOUNTED EQUIPMENT, MILLWORK, AND HARDWARE PER SPECIFICATIONS DIVISION 6, SECTION "MISCELLANEOUS ROUGH CARPENTRY"
- J. FIELD VERIFY ALL CASEWORK AND BUILT IN COMPONENTS PRIOR TO FABRICATION.
- K. COORDINATE ALL PLUMBING FIXTURES LOCATIONS WITH PLUMBING DRAWINGS
- L. SEE G007 FOR INTERIOR PERSPECTIVE VIEWS.
- M. PROVIDE BLOCKING IN WALLS AS NEEDED FOR ALL WALL-MOUNTED EQUIPMENT, CASEWORK, AND ACCESSORIES.

KEYNOTES


- 1. FRAME TIGHT TO CONTENTS.
- 2. CROSS BRACING, TYPICAL. PAINT, SEE STRUCTURAL.
- 3. FLOOR SINK / DRAIN. SEE PLUMBING.
- 4. DRINKING FOUNTAIN. SEE PLUMBING.
- 5. METAL GUARDRAIL. SEE 4/A402 FOR DETAIL. SAME AS STAIR 1 GUARDRAIL.
- 6. CUSTOM BUILT-IN SEATING TABLE NOOK. SEE 9/A403 FOR DETAILS.
- 7. ADD EXTRA LAYER OF GYPSUM BOARD THIS SIDE OF WALL TO ALIGN WITH ADJACENT WALL.
- 8. CANE DETECTION RAIL. 1/A103
- 9. OPENING IN FLOOR. SEE RCP FOR DIMENSIONS AND DETAILS 3/A403 AND 6/A403.
- 10. ALIGN WALL WITH WINDOW OPENING PER 3/A103.
- 11. 24"x24" ACCESS PANEL, MOUNT FLUSH WITHIN WALL 5' TO CENTERLINE OF PANEL. PAINT TO MATCH ADJACENT WALL.
- 12. WHITEBOARD, TYPICAL. SEE FINISH DRAWINGS.
- 13. AV COMPONENTS. SEE AV DRAWINGS.
- 14. "HEADWALL" COMPONENTS, TYPICAL. SEE 9/A708, FINISH AND MEP DRAWINGS.
- 15. MOP SINK. SEE PLUMBING.
- 16. CUBICLE TRACKS, TYPICAL. SEE FINISH DRAWINGS.
- 17. CUBBIES / LOCKERS. TYPICAL. SEE 1/A600 DRAWINGS.
- 18. ONE-WAY GLASS IN HM FRAME. SEE
- 19. RECESSED FIRE EXTINGUISHER CABINET.
- 20. "HEADWALL" COMPONENTS, TYPICAL. SEE 8/A708, FINISH AND MEP DRAWINGS.

BID SET

MARK & ROBYN JONES COLLEGE  
OF NURSING - BILLINGS  
MONTANA STATE UNIVERSITY

Cushing  
Terrell  
co ARCHITECTS

|              |             |          |
|--------------|-------------|----------|
| DRAWN BY:    |             | AV       |
| REVIEWED BY: |             | RC       |
| REV.         | DESCRIPTION | DATE     |
| 10           | PR-07       | 12.4.24  |
| A            | ADD-01      | 04.30.24 |

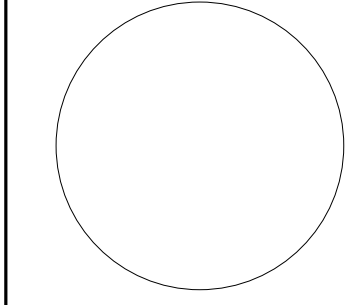

PPA#21-0169  
A/E# 2022-02-09-03

SHEET TITLE  
SECOND FLOOR PLAN


SHEET  
A102

DATE  
04.05.2024





- 1 MOTORIZED AND CONTROLLED ROLLER SHADES 'WS1' TO BE  
INSTALLED ON EXTERIOR WINDOWS IN THIS ROOM. REFER TO  
MATERIAL FINISH LIST FOR PRODUCT SPECIFICATIONS,  
COORDINATE POWER AND AUTOMATION WITH ELECTRICAL.
- 2 MANUAL ROLLER SHADES 'WS2' ON EXTERIOR WINDOWS IN THIS  
ROOM. REFER TO MATERIAL FINISH LIST FOR PRODUCT  
SPECIFICATIONS.
- 4 INSTALL PRIVACY WINDOW FILM 'WF1' ON GLAZING IN THIS ROOM.  
REFER TO MATERIAL FINISH LIST FOR PRODUCT SPECIFICATIONS,  
REFER TO DOOR SCHEDULE FOR MOUNTING HEIGHTS.
- 5 ELEVATOR CAB FINISHES TO BE SELECTED BY ARCHITECT FROM  
VENDORS FULL RANGE; INCLUDING WALL PANELS, HAND RAILS AND  
FLOORING.
- 6 INSTALL "FRP1" ON ALL WALLS IN THIS ROOM. 4FT HIGH TO START AT  
TOP OF BASE
- 7 CUSTOM BOOTH SEATING AND TABLES. SEE ELEVATIONS,  
RENDERINGS AND DETAILS FOR CONSTRUCTION AND DESIGN  
INTENT. REFER TO MATERIAL FINISH LIST FOR UPHOLSTERY.
- 8 SEE ISOMETRICS, ELEVATIONS, RENDERINGS FOR DESIGN AND  
MATERIAL INTENT.
- 9 SEE MATERIAL FINISH LIST 'LK1' AND 'LK1.1' FOR LOCKER  
SPECIFICATION. VENDOR PROVIDED, VENDOR INSTALLED.
- 10 CUSTOM MILLWORK. SEE ELEVATION FOR DETAILS.
- 11 PAINT DOOR AND FRAME WITH 'PS; BOTH SIDES
- 12 INSTALL 'WF1 ON ALL WALLS IN THIS ROOM 4FT HIGH TO START AT  
TOP OF FINISHED FLOOR. INSTALL WALL BASE ON TOP OF WPK
- 13 WHITEBOARD LOCATED ON THIS WALL. REFER TO MATERIAL FINISH  
LIST FOR PRODUCT SPECIFICATIONS, SIZE AND LOCATION.
- 14 LEVEL 5 WALL FINISH FOR FUTURE ART INSTALLATION.

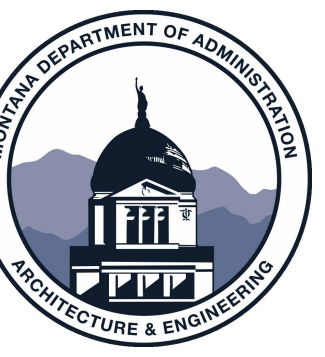

**BID SET**

---

**MARK & ROBYN JONES COLLEGE  
OF NURSING - BILLINGS  
MONTANA STATE UNIVERSITY**

**Cushing  
Terrell**  
CO ARCHITECTS

|              |             |      |
|--------------|-------------|------|
| DRAWN BY:    |             | LAST |
| REVIEWED BY: |             | LAST |
| REV.         | DESCRIPTION | DATE |

PPA#21-0169

A/E#: 2022-02-09-03

**SHEET TITLE**  
SECOND FLOOR  
FINISH PLAN


SHEET

# A502


DATE \_\_\_\_\_

04.05.2024




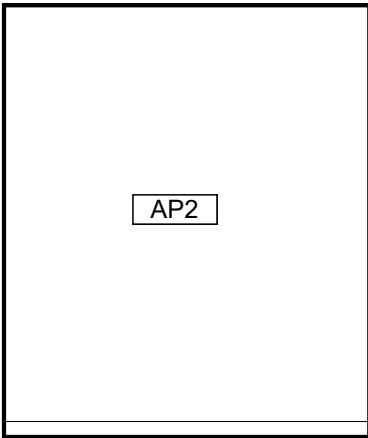


1 TYP. PRIVATE MEET - EAST  
1/4" = 1'-0" TYPICAL AT 110, 126, 128, 134, 136

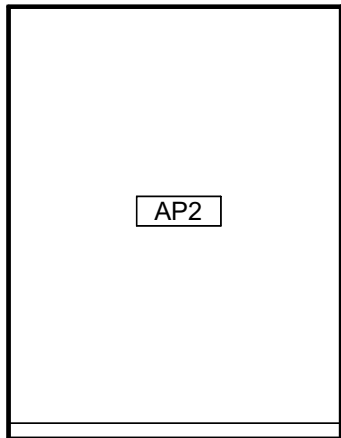


2 TYP. PRIVATE MEET - SOUTH  
1/4" = 1'-0" TYPICAL AT 110, 126, 128, 134, 136

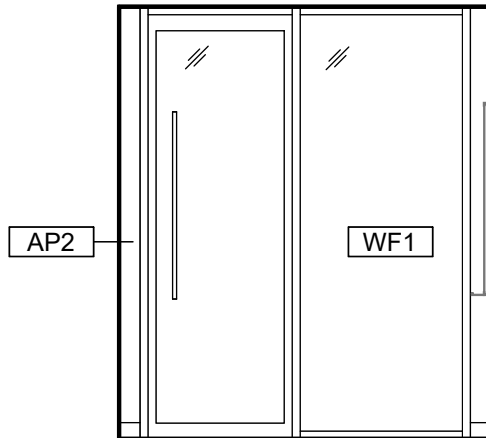


3 TYP. PRIVATE MEET - WEST  
1/4" = 1'-0" TYPICAL AT 110, 126, 128, 134, 136

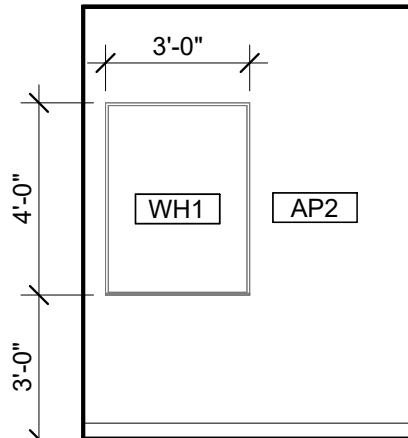


4 TYP. PRIVATE MEET - NORTH  
1/4" = 1'-0" TYPICAL AT 110, 126, 128, 134, 136

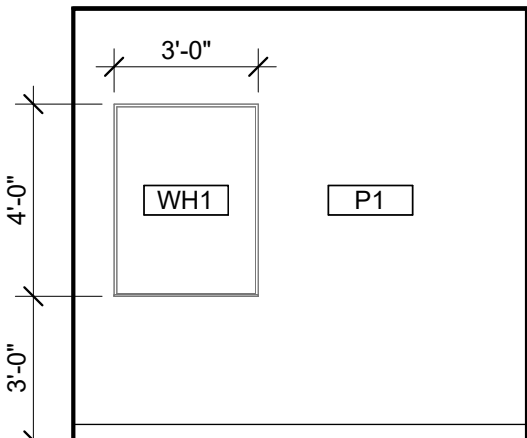


5 TYP. PRIVATE OFFICE - EAST  
1/4" = 1'-0" TYPICAL AT 114, 116, 118, 120, 122, 124

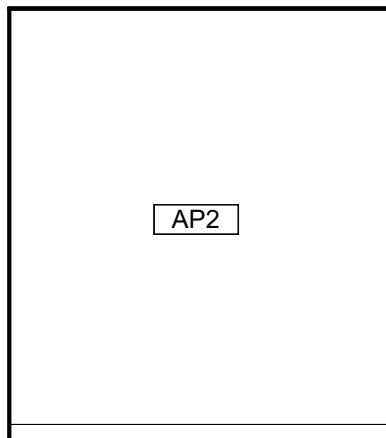


6 TYP. PRIVATE OFFICE - SOUTH  
1/4" = 1'-0" TYPICAL AT 114, 116, 118, 120, 122, 124

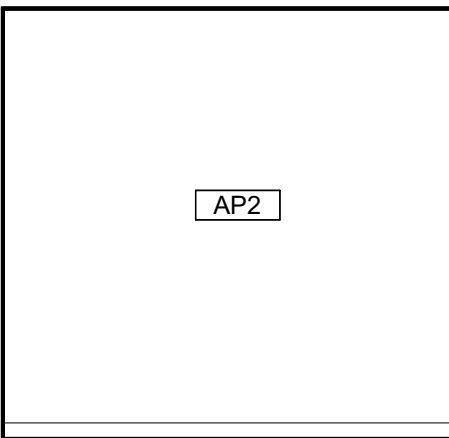


7 TYP. PRIVATE OFFICE - WEST  
1/4" = 1'-0" TYPICAL AT 114, 116, 118, 120, 122, 124

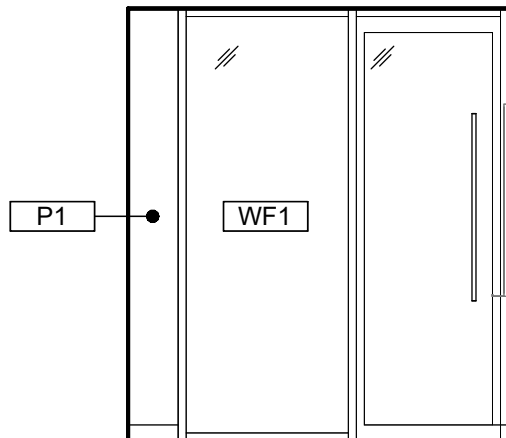


8 TYP. PRIVATE OFFICE - NORTH  
1/4" = 1'-0" TYPICAL AT 114, 116, 118, 120, 122, 124

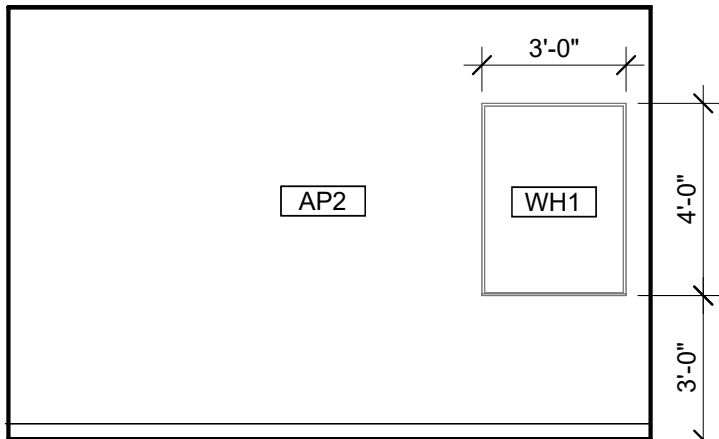


9 TYP. 2P OFFICE - EAST  
1/4" = 1'-0" TYPICAL AT 204, 206

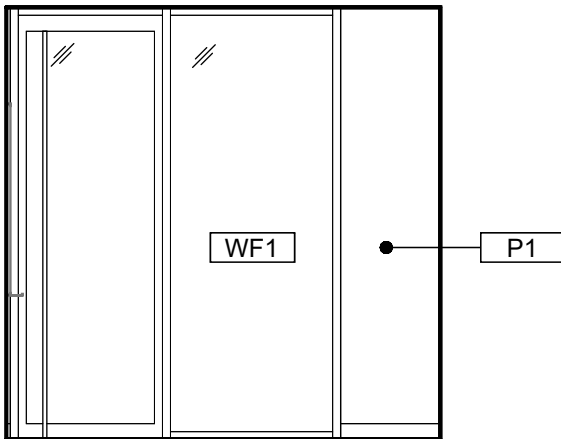


10 TYP. 2P OFFICE - SOUTH  
1/4" = 1'-0" TYPICAL AT 204, 206

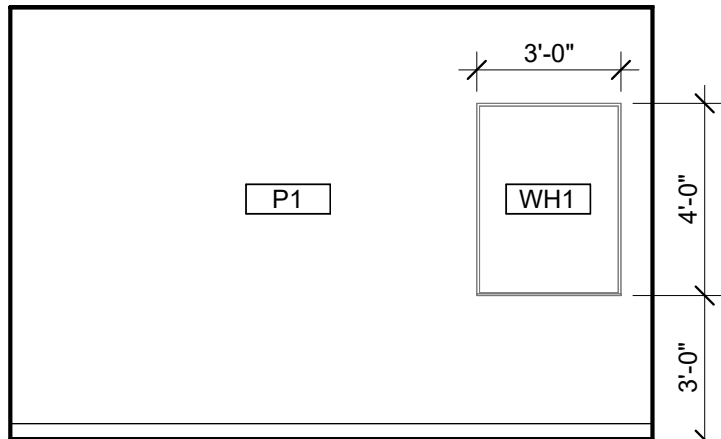


11 TYP. 2P OFFICE - WEST  
1/4" = 1'-0" TYPICAL AT 204, 206

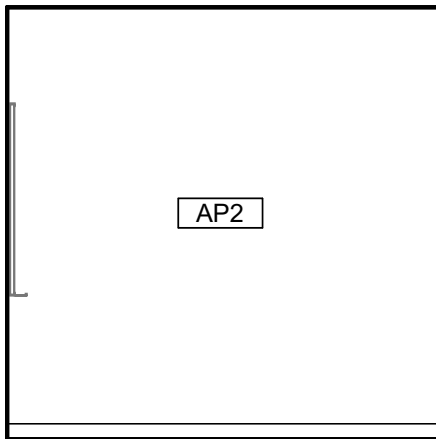


12 TYP. 2P OFFICE - NORTH  
1/4" = 1'-0" TYPICAL AT 204, 206

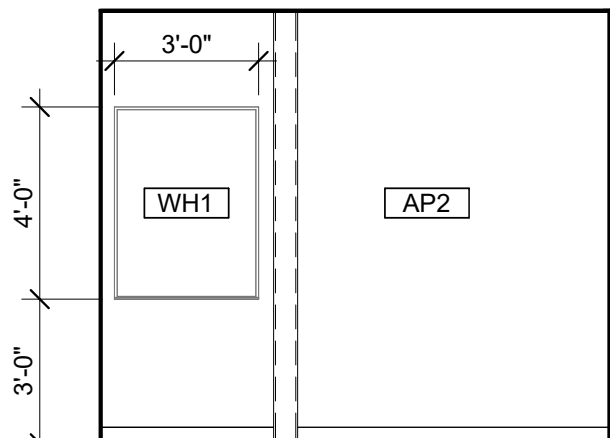


13 TYP. 4P HUDDLE SPACE - EAST  
1/4" = 1'-0" TYPICAL AT 112, 228, 230

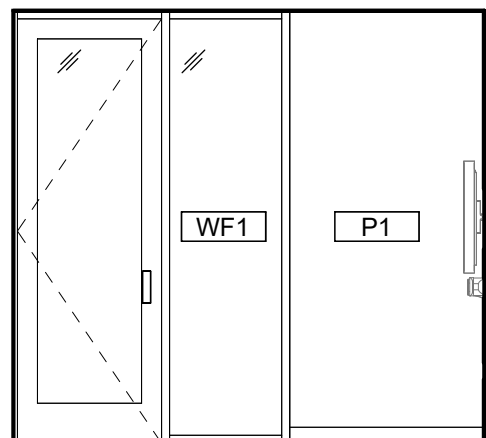


14 TYP. 4P HUDDLE SPACE - SOUTH  
1/4" = 1'-0" TYPICAL AT 112, 228, 230

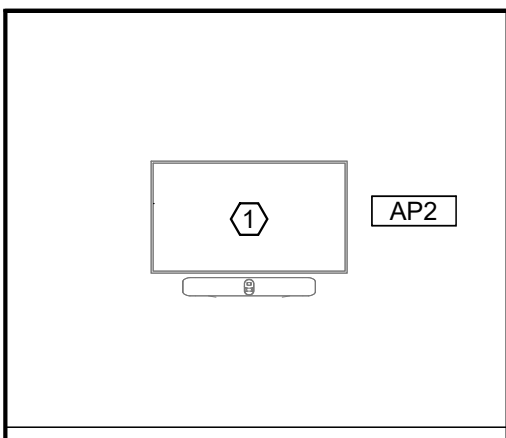


15 TYP. 4P HUDDLE SPACE - WEST  
1/4" = 1'-0" TYPICAL AT 112, 228, 230

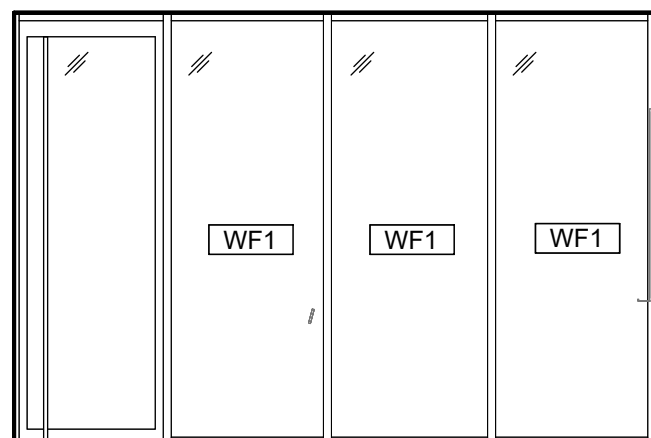

16 CO OP WORKROOM 202 - EAST  
1/4" = 1'-0"

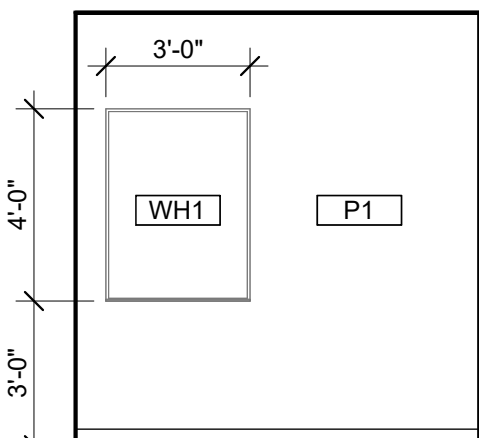

17 CO OP WORKROOM 202 - SOUTH  
1/4" = 1'-0"

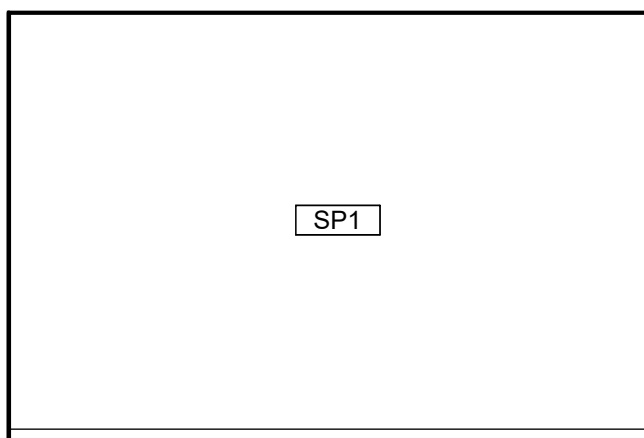

18 CO OP WORKROOM 202 - WEST  
1/4" = 1'-0"

GENERAL INTERIOR ELEVATION NOTES

A. SEE A701 FOR TOILET AND LAV ACCESSORY SCHEDULE.  
B. SEE A503 FOR MATERIAL/FINISH ABBREVIATION LIST.  
C. PAINT ALL EXPOSED STRUCTURAL STEEL COLUMNS, CROSS BRACING, ETC. WITH 'P1' SEMI-GLOSS FINISH. UNLESS NOTED OTHERWISE.

KEYNOTES


1 AV MONITOR. REFER TO AV DRAWINGS FOR MOUNTING HEIGHTS.

BID SET

MARK & ROBYN JONES COLLEGE  
OF NURSING - BILLINGS  
MONTANA STATE UNIVERSITY

Cushing  
Terrell  
ARCHITECTS

|              |             |      |      |
|--------------|-------------|------|------|
| DRAWN BY:    |             | LAST |      |
| REVIEWED BY: |             | LAST |      |
| REV.         | DESCRIPTION | NAME | DATE |
|              |             |      |      |
|              |             |      |      |
|              |             |      |      |
|              |             |      |      |

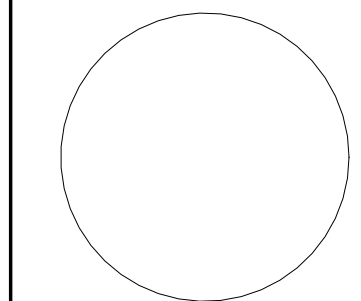

PPA#21-0169

A/E#: 2022-02-09-03

SHEET TITLE  
INTERIOR ELEVATIONS


SHEET  
A707

DATE  
04.05.2024




MATERIALS LIST - BASIS OF DESIGN

| ITEM NO         | PRODUCT TYPE                       | MANUFACTURER                     | DESCRIPTION                                                                                                    | COLOR                                                               | SIZE                                                                | NOTES                                                                                                                                                                                                          | Sustainability Notes                            |
|-----------------|------------------------------------|----------------------------------|----------------------------------------------------------------------------------------------------------------|---------------------------------------------------------------------|---------------------------------------------------------------------|----------------------------------------------------------------------------------------------------------------------------------------------------------------------------------------------------------------|-------------------------------------------------|
| BASE            |                                    |                                  |                                                                                                                |                                                                     |                                                                     |                                                                                                                                                                                                                |                                                 |
| CB1             | COVE BASE                          | SCHLUTER SYSTEMS                 | DILEX-AHK COVE BASE                                                                                            | STAINLESS STEEL                                                     | GC TO CONFIRM SIZE WITH TILE ASSEMBLY                               | TO BE INSTALLED WITH LATICRETE SPECTRALOCK EPOXY GROUT COLOR 78 STERLING SILVER. TO BE USED WITH SCHLUTER UNCOUPLING MEMBRANE AND EXPANSION JOINTS AS RECOMMENDED                                              | RECYCLED CONTENT, NON-EMITTING SOURCE OF VOCs   |
| RB1             | RESILIENT BASE                     | JOHNSONITE                       | MILLWORK PROFILE MONUMENT                                                                                      | PEWTER, GC TO CONFIRM FINAL SELECTION WITH OWNER                    | 4" HIGH                                                             | MITER CORNER                                                                                                                                                                                                   | EPD, FLOORSORE, CRADLE TO GATE                  |
| RB2             | RESILIENT BASE                     | JOHNSONITE                       | THERMOSET THERMOPLASTIC RUBBER COVE BASE                                                                       | PEWTER, GC TO CONFIRM FINAL SELECTION WITH OWNER                    | 4" HIGH                                                             | MITER CORNERS, ROLLED GOODS                                                                                                                                                                                    | EPD, FLOORSORE, CRADLE TO GATE                  |
| CEILING         |                                    |                                  |                                                                                                                |                                                                     |                                                                     |                                                                                                                                                                                                                |                                                 |
| AC1             | ACOUSTIC CEILING                   | ARMSTRONG                        | CALLA MINERAL FIBER                                                                                            | WHITE                                                               | 2X2GRID, PRELUDE XL 15/16 SUSPENSION SYSTEM IN COLOR BLIZZARD WHITE | -                                                                                                                                                                                                              | EPD, HPD, DECLARE, GREENGUARD                   |
| AC3             | ACOUSTIC CEILING                   | FSORB                            | FSORB ACOUSTIC PANELING                                                                                        | WHITE                                                               | 1"THICK, 48"X96"                                                    | SEE RCPS. COORDINATE WITH MEP FIXTURES                                                                                                                                                                         | EPD, HPD, DECLARE, GREENGUARD                   |
| AC4             | ACOUSTIC CEILING                   | ARMSTRONG                        | CALLA MINERAL FIBER                                                                                            | BLACK                                                               | 2X2GRID, PRELUDE XL 15/16 SUSPENSION SYSTEM IN COLOR CHARCOAL       | CONTROL ROOMS ONLY. SEE RCPS.COORDINATE WITH MEP FIXTURES                                                                                                                                                      | EPD, HPD, DECLARE, GREENGUARD                   |
| AL              | ALUMINUM CEILING                   | LONGBOARD                        | ENDURA LINEAR DIRECT MOUNT CEILING. 6INCH V GROOVE PLANK.                                                      | BEECHWOOD                                                           | -                                                                   | SEE RCPS.                                                                                                                                                                                                      | EPD                                             |
| ALP             | ALUMINUM CEILING                   | LONGBOARD                        | ENDURA LINEAR DIRECT MOUNT CEILING. 6INCH V GROOVE PERFORATED PLANK. SOUNDTEX ACOUSTIC LINER                   | BEECHWOOD. SOUNDTEX BLACK                                           | -                                                                   | SEE RCPS. COORDINATE WITH MEP FIXTURES                                                                                                                                                                         | EPD                                             |
| BF1             | BAFFLES                            | LONGBOARD                        | DAUNTLESS BAFFLE CEILING SYSTEM                                                                                | BEECHWOOD                                                           | 6" HIGH BAFFLE                                                      | SEE RCPS. COORDINATE WITH MEP FIXTURES                                                                                                                                                                         | EPD                                             |
| FLOOR           |                                    |                                  |                                                                                                                |                                                                     |                                                                     |                                                                                                                                                                                                                |                                                 |
| CP1             | CARPET TILE                        | MILLIKEN                         | COLLECTION: LOW COUNTRY, PATTERN: SALT MARSH                                                                   | SLM13 FRIPP                                                         | 9.85"X39.4"                                                         | 33% OFFSET ASHLAR INSTALLATION                                                                                                                                                                                 | EPD, DECLARE, C2C                               |
| CP2             | CARPET TILE                        | MILLIKEN                         | COLLECTION: LOW COUNTRY, PATTERN: SEA RISE                                                                     | SRS196-13 INDIGO PLANT                                              | 9.85"X39.4"                                                         | 33% OFFSET ASHLAR INSTALLATION                                                                                                                                                                                 | EPD, DECLARE, C2C                               |
| CP3             | CARPET TILE                        | MILLIKEN                         | COLLECTION: LOW COUNTRY, PATTERN: WATERWAY                                                                     | WAT196-13 INDIGO PLANT                                              | 9.85"X39.4"                                                         | 33% OFFSET ASHLAR INSTALLATION                                                                                                                                                                                 | EPD, DECLARE, C2C                               |
| EM1             | ENTRY WALK OFF CARPET              | MILLIKEN                         | OBEX BAR TRANSITIONS RECESSED                                                                                  | DARK GREY                                                           | 10.87"X39.37"                                                       | COORDINATE WITH STRUCTURE                                                                                                                                                                                      | INDOOR AIR ADVANTAGE GOLD                       |
| EM2             | ENTRY WALK OFF CARPET              | MILLIKEN                         | WALK OFF OBEX CARPET TILE                                                                                      | CUT FIZZ, DARK GREY                                                 | 19.68X19.68                                                         | -                                                                                                                                                                                                              | INDOOR AIR ADVANTAGE GOLD                       |
| ES1             | ELECTRIC STATIC FLOOR              | STATICWORX                       | AMERIWORX CLASSIC EDS SOLID VINYL TILE                                                                         | ADIRONDACK RIDGE                                                    | 12X12                                                               | COORDINATE GROUNDING FOR COPPER WIRE WITH ELECTRICAL                                                                                                                                                           | FLOORSORE, RECYCLED CONTENT                     |
| RT1             | RESILIENT FLOORING                 | TARKETT                          | COLLECTION: COLOR WEAVE                                                                                        | THUNDER                                                             | 18X18                                                               | GLUE DOWN                                                                                                                                                                                                      | EPD, FLOORSORE, CRADLE TO GATE                  |
| SC1             | SEALED CONCRETE                    | SHERWIN WILLIAMS                 | H&C CLARISHIELD WATER-BASED CONCRETE SEALER                                                                    | NATURAL LOOK                                                        | -                                                                   | -                                                                                                                                                                                                              | -                                               |
| TF1             | TILE FLOOR                         | EMSER                            | MOOD                                                                                                           | RIVER GRAY                                                          | 12X23                                                               | TO BE INSTALLED WITH LATICRETE SPECTRALOCK EPOXY GROUT COLOR 78 STERLING SILVER. TO BE USED WITH SCHLUTER UNCOUPLING MEMBRANE AND EXPANSION JOINTS AS RECOMMENDED                                              | HPD, RED LIST FREE                              |
| TF2             | TILE FLOOR                         | FLORIDA TILE                     | CANAL STREET COLLECTION                                                                                        | BLACK BAYOU                                                         | 24X48                                                               | TO BE INSTALLED WITH LATICRETE SPECTRALOCK EPOXY GROUT COLOR 78 STERLING SILVER. TO BE USED WITH SCHLUTER UNCOUPLING MEMBRANE AND EXPANSION JOINTS AS RECOMMENDED                                              | EPD, HPD, GREENGUARD                            |
| MILLWORK        |                                    |                                  |                                                                                                                |                                                                     |                                                                     |                                                                                                                                                                                                                |                                                 |
| FB1             | FABRIC UPHOLSTERY                  | ANZEA                            | KAPOW COLLECTION                                                                                               | SWISH                                                               | SEE ELEVATIONS AND RENDERING FOR DESIGN INTENT                      | SEAT CUSHION. GC TO PROVIDE SHOP DRAWINGS FOR FINAL APPROVAL                                                                                                                                                   | HPD, REDLIST FREE                               |
| FB2             | FABRIC UPHOLSTERY                  | DESIGNTEX                        | TACK CLOTH                                                                                                     | MARINER 3749-404                                                    | SEE ELEVATIONS AND RENDERING FOR DESIGN INTENT                      | BACK CUSHION. GC TO PROVIDE SHOP DRAWINGS FOR FINAL APPROVAL                                                                                                                                                   | HPD                                             |
| HD1             | HARDWARE: MODULAR CASEWORK         | CAROLINA MILEMARKER              | GRIP CABINET PULL, ADA COMPLIANT                                                                               | SATIN NICKEL                                                        | -                                                                   | TO BE INSTALLED WITH MODULAR CASEWORK. CONTACT: Jared.B@cdcollective.com WITH CONTRACT DESIGN                                                                                                                  | -                                               |
| PL1             | PLASTIC LAMINATE: CUSTOM MILLWORK  | WILSONART                        | HPL BLONDE ECHO LINEARITY FINISH                                                                               | 7939K-18                                                            | -                                                                   | ALL MILLWORK SURFACES TO BE MATCHING WOOD GRAIN LOOK, NO MELAMINE                                                                                                                                              | HPD, INDOOR AIR ADVANTAGE GOLD, GREENGUARD GOLD |
| PL2             | PLASTIC LAMINATE: MODULAR CASEWORK | CAROLINA-OFS                     | HPL LINEN (WOOD LOOK)                                                                                          | OFS STANDARD LAMINATE                                               | -                                                                   | ALL MILLWORK SURFACES TO BE MATCHING WOOD GRAIN LOOK, NO MELAMINE. CONTACT: Jared. B@cdcollective.com WITH CONTRACT DESIGN                                                                                     | INDOOR AIR ADVANTAGE GOLD                       |
| PL3             | PLASTIC LAMINATE: CUSTOM MILLWORK  | WILSONART                        | HPL LINEN (WHITE)                                                                                              | D427-60 MATTE FINISH                                                | -                                                                   | ALL MILLWORK SURFACES TO BE MATCHING WOOD GRAIN LOOK, NO MELAMINE                                                                                                                                              | HPD, INDOOR AIR ADVANTAGE GOLD, GREENGUARD GOLD |
| QZ1             | QUARTZ SURFACE                     | EVERO QUARTZ BY BRADLEY          | GEO SERIES                                                                                                     | ANDORRA L213                                                        | SEE PLUMBING SPECIFICATIONS                                         | RESTROOM TROUGH SINK. SEE PLUMBING FOR DETAILS                                                                                                                                                                 | GREENGUARD GOLD                                 |
| SS1             | SOLID SURFACE: MODULAR CASEWORK    | CAROLINA-OFS                     | LIVINGSTONE SURFACES. SNOWFALL                                                                                 | -                                                                   | -                                                                   | MITERED CORNERS, EASED EDGES, CONTACT: Jared.B@cdcollective.com WITH CONTRACT DESIGN                                                                                                                           | HPD, GREENGUARD                                 |
| MISC.           |                                    |                                  |                                                                                                                |                                                                     |                                                                     |                                                                                                                                                                                                                |                                                 |
| AC2             | ACOUSTIC ARCHITECTURAL ELEMENT     | TURF DESIGNS                     | ARCHITECTURAL ELEMENT: PATTERN FRACTAL, CLASS A                                                                | SHELL HOUSING COLOR: DAMASCAS 09, INSERTS: LIGHT 04 GREY            | MODULAR CLOUD, 36"X36"                                              | SEE RCP. DETAILS, AND ELEVATIONS FOR DESIGN INTENT. COORDINATE WITH MECHANICAL, ELECTRICAL AND STRUCTURAL SYSTEMS. INSTALLER TO USE RECOMMENDED THREADED ROD CONNECTION. CONTACT: jordan@absolute-resource.com | HPD, DECLARE                                    |
| AP1             | ACOUSTIC PRODUCTS                  | KIREI                            | SOLID WALL PANEL                                                                                               | 442 GREY                                                            | SHEET SIZE 9'X4'X1/2"THICK                                          | Z-CLIP MOUNT. SEE ELEVATIONS FOR DESIGN INTENT AND SIZING                                                                                                                                                      | HPD                                             |
| AP1.1           | ACOUSTIC PRODUCTS                  | KIREI                            | SOLID WALL PANEL                                                                                               | 660 CORONET                                                         | SHEET SIZE 9'X4'X1/2"THICK                                          | Z-CLIP MOUNT. SEE ELEVATIONS FOR DESIGN INTENT AND SIZING                                                                                                                                                      | HPD                                             |
| AP2             | ACOUSTIC PRODUCTS                  | MOMENTUM TEXTILES                | NUFELT BOWTIE ACOUSTIC WALLCOVERING. PATTERN TO RUN VERTICAL. MATCH SEAMS.                                     | WISFUL THINKING                                                     | 0.12" THICK X 63" WIDE ROLL                                         | ADHESIVE MOUNT. PROVIDE METAL TRANSITION ON ALL EXPOSED EDGES.GC TO PROVIDE SHOP DRAWINGS FOR FINAL APPROVAL.                                                                                                  | HPD, GREENGUARD, RECYCLED CONTENT               |
| AP3             | ACOUSTIC PRODUCTS                  | KIREI                            | GROOVY 3.0 PANELS                                                                                              | 442 GREY                                                            | SHEET SIZE: 110 X 44 NOOKS                                          | SEE ELEVATIONS AND DETAILS FOR DESIGN INTENT. COORDINATE FITTING WITH ELECTRICAL AND FIRE PROTECTION. TO BE USED WITH TRANSITION EDGE #LVT908EBRZ                                                              | EPD, HPD, DECLARE, RECYCLED CONTENT             |
| AP4             | ACOUSTIC PRODUCTS                  | MDC ZINTRA                       | ETCH TETRIS                                                                                                    | PANEL COLOR: CADET, REVEAL COLOR: SUNSHINE                          | SHEET SIZE 9'X4'X1/2"THICK                                          | SEE ELEVATIONS AND DETAILS FOR DESIGN INTENT. COORDINATE FITTING WITH ELECTRICAL AND FIRE PROTECTION                                                                                                           | REDLIST FREE, RECYCLED CONTENT                  |
| AP4.1           | ACOUSTIC PRODUCTS                  | MDC ZINTRA                       | ETCH TETRIS                                                                                                    | PANEL COLOR: PEWTER, REVEAL COLOR: SLATE                            | SHEET SIZE 9'X4'X1/2"THICK                                          | SEE ELEVATIONS AND DETAILS FOR DESIGN INTENT. COORDINATE FITTING WITH ELECTRICAL AND FIRE PROTECTION                                                                                                           | REDLIST FREE, RECYCLED CONTENT                  |
| CC1             | CUBICLE CURTAIN                    | KNOLL                            | FABRIC PATTERN SIGNAL, MESH: WHITE. ACCESSORIES AND TRACK PROVIDED BY GC                                       | FABRIC: COASTLINE, MESH: WHITE. GROMMETS:WHITE OR CLEAR ANNOXIDIZED | SEE ELEVATIONS AND RENDERING FOR DESIGN INTENT                      | OMBRE STRIPES TO RUN HORIZONTALLY. GC TO PROVIDE SHOP DRAWINGS FOR FINAL APPROVAL. SEE RCP AND DETAILS FOR HANGING STRUCTURE                                                                                   | FREE OF INTENTIONALLY ADDED PFAS                |
| LK1             | LOCKERS                            | CAROLINA MILEMARKER              | 2 TIER STORAGE LOCKER. BATTERY OPERATED LOCKS. PULL: RECESSED. INCLUDE 2 PRONG COAT HOOKS                      | HPL LINEN (WOOD LOOK) PULL: STAIN NICKLE                            | SEE ELEVATIONS                                                      | -                                                                                                                                                                                                              | INDOOR AIR ADVANTAGE GOLD                       |
| LK1.1           | LOCKERS                            | CAROLINA MILEMARKER              | OPEN CUBBIES                                                                                                   | HPL LINEN (WOOD LOOK) PULL: STAIN NICKLE                            | SEE ELEVATIONS                                                      | CONFIRM QTY AND SIZE OF OPEN CUBBIES WITH CLIENT PRIOR TO APPROVAL                                                                                                                                             | INDOOR AIR ADVANTAGE GOLD                       |
| WF1             | PRIVACY WINDOW FILM                | TAKEFORM                         | DUAL FADE FROSTED CUSTOM PATTERN                                                                               | FROSTED                                                             | 60 INCH BAND TO START 2FT FROM BOTTOM OF DOOR FRAME                 | GC TO PROVIDE SHOP DRAWINGS FOR APPROVAL. GC TO PROVIDE MOCKUP PRIOR TO ORDERING FOR OWNER APPROVAL                                                                                                            | -                                               |
| WH1             | WHITEBOARD                         | CLARUS                           | FLOAT : BACKPAINTED MAGNETIC GLASSBOARD                                                                        | WHITE                                                               | SEE ELEVATIONS                                                      | INCLUDE MARKERS, HANGERS AND ALL ACCESSORIES                                                                                                                                                                   | EPD, DECLARE                                    |
| WS1             | WINDOW SHADES                      | LUTRON                           | MOTORIZED ROLLER SHADES: CONTRACT ROLLER QS WIRELESS                                                           | FASCIA: TBD, FABRIC: 1% OPEN, COLOR: MSCREEN CHARCOAL/GREY          | FIELD VERIFY ON SITE                                                | COORDINATE WITH ELECTRICAL                                                                                                                                                                                     | -                                               |
| WS2             | WINDOW SHADES                      | LUTRON                           | MANUAL ROLLER SHADES: CONTRACT ROLLER MANUAL                                                                   | FASCIA: TBD, FABRIC: 1% OPEN, COLORMSCREEN CHARCOAL/GREY            | FIELD VERIFY ON SITE                                                | -                                                                                                                                                                                                              | -                                               |
| TRANSITIONS     |                                    |                                  |                                                                                                                |                                                                     |                                                                     |                                                                                                                                                                                                                |                                                 |
| TR1             | TRANSITION PROFILE                 | SCHLUTER SYSTEMS                 | CARPET TO TILE: SCHIENE                                                                                        | TBD                                                                 | GC TO CONFIRM SIZES WITH MATERIAL THICKNESS                         | SEE ARCHITECTURAL DETAIL.                                                                                                                                                                                      | RECYCLED CONTENT, NON-EMITTING SOURCE OF VOCs   |
| TR2             | TRANSITION PROFILE                 | FUTURA TRANSITIONS               | CARPET TO RESILIENT: CARPET TO LVT PROFILE                                                                     | ETCHED ALUMINUM                                                     | GC TO CONFIRM SIZES WITH MATERIAL THICKNESS                         | SEE ARCHITECTURAL DETAIL.                                                                                                                                                                                      | REACH / ROHS COMPLIANT                          |
| TR3             | TRANSITION PROFILE                 | FUTURA TRANSITIONS               | CARPET TO CONCRETE: DELUXE BINDER BAR                                                                          | ETCHED ALUMINUM                                                     | GC TO CONFIRM SIZES WITH MATERIAL THICKNESS                         | SEE ARCHITECTURAL DETAIL.                                                                                                                                                                                      | REACH / ROHS COMPLIANT                          |
| TR4             | TRANSITION PROFILE                 | SCHLUTER SYSTEMS                 | RESILIENT TO TILE: RENO-U                                                                                      | TBD                                                                 | GC TO CONFIRM SIZES WITH MATERIAL THICKNESS                         | SEE ARCHITECTURAL DETAIL.                                                                                                                                                                                      | RECYCLED CONTENT, NON-EMITTING SOURCE OF VOCs   |
| TR5             | TRANSITION PROFILE                 | FUTURA TRANSITIONS               | RESILIENT TO CONCRETE: COVING CAP                                                                              | ETCHED ALUMINUM                                                     | GC TO CONFIRM SIZES WITH MATERIAL THICKNESS                         | SEE ARCHITECTURAL DETAIL.                                                                                                                                                                                      | REACH / ROHS COMPLIANT                          |
| TR6             | TRANSITION PROFILE                 | FUTURA TRANSITIONS               | TILE TO CONCRETE: CERAMIC REDUCER EDGE/TEK U SHAPED                                                            | ETCHED ALUMINUM                                                     | GC TO CONFIRM SIZES WITH MATERIAL THICKNESS                         | SEE ARCHITECTURAL DETAIL.                                                                                                                                                                                      | REACH / ROHS COMPLIANT                          |
| TR7             | TRANSITION PROFILE                 | FUTURA TRANSITIONS               | FELT METAL EDGE FOR AP3, AP4                                                                                   | #LVT 908 EBLK                                                       | GC TO CONFIRM SIZES WITH MATERIAL THICKNESS                         | SEE ARCHITECTURAL DETAIL.                                                                                                                                                                                      | REACH / ROHS COMPLIANT                          |
| TR8             | TRANSITION PROFILE                 | FUTURA TRANSITIONS               | FELT METAL EDGE FOR AP2: BEVEL CAP                                                                             | 4MM, #LVT 906 EBLK                                                  | GC TO CONFIRM SIZES WITH MATERIAL THICKNESS                         | SEE ARCHITECTURAL DETAIL.                                                                                                                                                                                      | REACH / ROHS COMPLIANT                          |
| TR9             | TRANSITION PROFILE                 | TBD                              | WALL PROTECTION EDGE -LABS                                                                                     | TBD                                                                 | GC TO CONFIRM SIZES WITH MATERIAL THICKNESS                         | SEE ARCHITECTURAL DETAIL.                                                                                                                                                                                      | -                                               |
| TR10            | TRANSITION PROFILE                 | SCHLUTER SYSTEMS                 | WALL TILE EDGE + CORNERS: FINEC-SQ - ALL EXPOSED EDGES, OUTSIDE CORNERS                                        | TBD                                                                 | GC TO CONFIRM SIZES WITH MATERIAL THICKNESS                         | SEE ARCHITECTURAL DETAIL.                                                                                                                                                                                      | RECYCLED CONTENT, NON-EMITTING SOURCE OF VOCs   |
| TR11            | TRANSITION PROFILE                 | FUTURA TRANSITIONS               | VENEER PLYWOOD EDGE - NOOKS: COVING CAP 1/8" OR 3/32"                                                          | EBLK                                                                | GC TO CONFIRM SIZES WITH MATERIAL THICKNESS                         | SEE ARCHITECTURAL DETAIL.                                                                                                                                                                                      | REACH / ROHS COMPLIANT                          |
| TR12            | TRANSITION PROFILE                 | VARIES                           | STAIR TREAD TRANSITION                                                                                         | TBD                                                                 | GC TO CONFIRM SIZES WITH MATERIAL THICKNESS                         | SEE ARCHITECTURAL DETAIL.                                                                                                                                                                                      | -                                               |
| WALL            |                                    |                                  |                                                                                                                |                                                                     |                                                                     |                                                                                                                                                                                                                |                                                 |
| EP1             | EPOXY PAINT                        | SHERWIN WILLIAMS                 | PRO-INDUSTRIAL WATERBASED CATALYZED EPOXY                                                                      | SW7566 WESTHIGHLAND WHITE                                           | CEILINGS: FLAT FINISH, WALLS EG-SHEL FINISH                         | GC TO PROVIDE LOW/NO VOC PAINT                                                                                                                                                                                 | -                                               |
| EP2             | EPOXY PAINT                        | SHERWIN WILLIAMS                 | ZERO VOC HARMONY INTERIOR LATEX PAINT                                                                          | SW7609 GEORGIAN REVIVAL BLUE                                        | CEILINGS: FLAT FINISH, WALLS EG-SHEL FINISH                         | GC TO PROVIDE LOW/NO VOC PAINT                                                                                                                                                                                 | -                                               |
| P1              | PAINT                              | SHERWIN WILLIAMS                 | ZERO VOC HARMONY INTERIOR LATEX PAINT                                                                          | SW7566 WESTHIGHLAND WHITE                                           | CEILINGS: FLAT FINISH, WALLS EG-SHEL FINISH                         | GC TO PROVIDE LOW/NO VOC PAINT                                                                                                                                                                                 | -                                               |
| P2              | PAINT                              | SHERWIN WILLIAMS                 | ZERO VOC HARMONY INTERIOR LATEX PAINT                                                                          | SW7609 GEORGIAN REVIVAL BLUE                                        | CEILINGS: FLAT FINISH, WALLS EG-SHEL FINISH                         | GC TO PROVIDE LOW/NO VOC PAINT                                                                                                                                                                                 | -                                               |
| P3              | PAINT                              | SHERWIN WILLIAMS                 | ZERO VOC HARMONY INTERIOR LATEX PAINT                                                                          | SW7506 VAST SKY                                                     | CEILINGS: FLAT FINISH, WALLS EG-SHEL FINISH                         | GC TO PROVIDE LOW/NO VOC PAINT                                                                                                                                                                                 | -                                               |
| P4              | PAINT                              | SHERWIN WILLIAMS                 | ZERO VOC HARMONY INTERIOR LATEX PAINT                                                                          | SW7072 ONLINE                                                       | CEILINGS: FLAT FINISH, WALLS EG-SHEL FINISH                         | GC TO PROVIDE LOW/NO VOC PAINT                                                                                                                                                                                 | -                                               |
| P5              | PAINT                              | SHERWIN WILLIAMS                 | ZERO VOC HARMONY INTERIOR LATEX PAINT                                                                          | SW7075 WEB GRAY                                                     | CEILINGS: FLAT FINISH, WALLS EG-SHEL FINISH                         | GC TO PROVIDE LOW/NO VOC PAINT                                                                                                                                                                                 | -                                               |
| SP1             | SPECIALTY PAINT/COATING            | GC/ SIGNAGE VENDOR TO PROVIDE    | CUSTOM GRAPHIC ON TYPE III TERRALON VINYL                                                                      | CUSTOM IMAGERY                                                      | SEE ELEVATIONS AND RENDERING FOR DESIGN INTENT                      | WALLS RECEIVING GRAPHIC TO HAVE A LEVEL 5 GYP FINISH, PROVIDE MOCKUP TO DESIGNER FOR APPROVAL, CO/CT TO PROVIDE DESIGN INTENT                                                                                  | -                                               |
| TW1             | TILE WALL                          | EMSER                            | COUNCIL                                                                                                        | GRAY                                                                | 12X24                                                               | TO BE INSTALLED WITH LATICRETE SPECTRALOCK EPOXY GROUT COLOR 78 STERLING SILVER                                                                                                                                | HPD, RED LIST FREE                              |
| TW2             | TILE WALL                          | DALTILE                          | STAGECRAFT KALEIDOSCOPE                                                                                        | GALAXY 1469                                                         | 6X6                                                                 | TO BE INSTALLED WITH LATICRETE SPECTRALOCK EPOXY GROUT COLOR 78 STERLING SILVER                                                                                                                                | RECYCLED CONTENT                                |
| TW3             | TILE WALL                          | DALTILE                          | STAGECRAFT KALEIDOSCOPE                                                                                        | ARCTIC WHITE 0190                                                   | 6X6                                                                 | TO BE INSTALLED WITH LATICRETE SPECTRALOCK EPOXY GROUT COLOR 78 STERLING SILVER                                                                                                                                | RECYCLED CONTENT                                |
| WC1             | WALLCOVERING                       | P3TEC                            | STELLAR                                                                                                        | P3T-60128 WHITE OUT                                                 | 4' ROLL                                                             | INSTALL ABOVE WALL BASE. METAL TRIM CAP.                                                                                                                                                                       | EPD,HPD                                         |
| WOW1            | WOOD WALL & SOFFIT                 | GC TO PROVIDE/ CUSTOM MILLWORKER | RIFT SAWN WHITE OAK, POLYURETHANE FINISH, TO MATCH ARCHITECTS SAMPLE IN SPECIEIS, STAIN, GRAINING, AND TEXTURE | GC TO PROVIDE A RANGE OF SAMPLES                                    | -                                                                   | SEE DETAILS, ELEVATIONS, AND SECTIONS FOR DESIGN INTENT                                                                                                                                                        | -                                               |
| WALL PROTECTION |                                    |                                  |                                                                                                                |                                                                     |                                                                     |                                                                                                                                                                                                                |                                                 |
| CG1             | CORNER GUARD                       | C.S. ACROVYN                     | SSM-20                                                                                                         | WHITE, SUEDE FINISH                                                 | 2" WINGS, FULL HEIGHT                                               | CG1 TO START AT TOP OF BASE.                                                                                                                                                                                   | EPD                                             |
| CH1             | CHAIR RAIL                         | C.S. ACROVYN                     | SCR-40 SURFACE MOUNTED                                                                                         | WHITE, SUEDE FINISH                                                 | 4" HIGH                                                             | SEE ELEVATIONS FOR DESIGN INTENT AND SIZING                                                                                                                                                                    | EPD                                             |
| FRP1            | FIBERGLASS REINFORCED PANEL        | CONSTRUCTION SPECIALTIES         | FRP ACROVYN WALL COVERING                                                                                      | WHITE, SUEDE FINISH                                                 | 4'X8'                                                               | FRP TO START AT TOP OF BASE                                                                                                                                                                                    | -                                               |
| WP1             | WALL PROTECTION                    | CONSTRUCTION SPECIALTIES         | ACROVYN WALL PROTECTION RIGID SHEET                                                                            | WHITE, SUEDE FINISH                                                 | 4'X8'                                                               | INSTALL ABOVE FINISHED FLOOR; WALL BASE TO BE INSTALLED ON TOP OF WP#1 PANEL.                                                                                                                                  | EPD, CRADLE TO CRADLE                           |

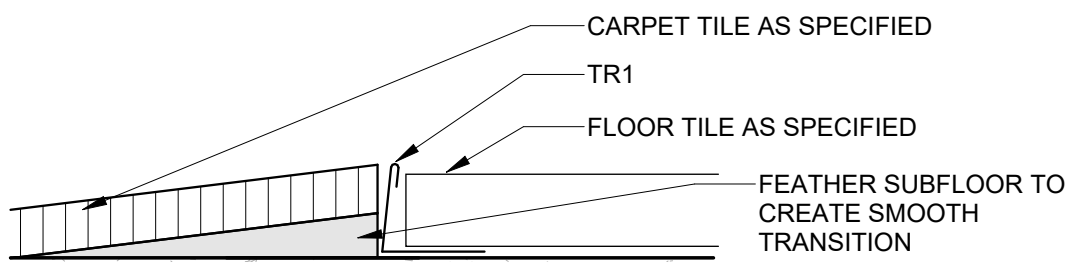


INTERIOR DETAIL - TR1 CARPET TO FLOOR TILE

12" = 1'-0"

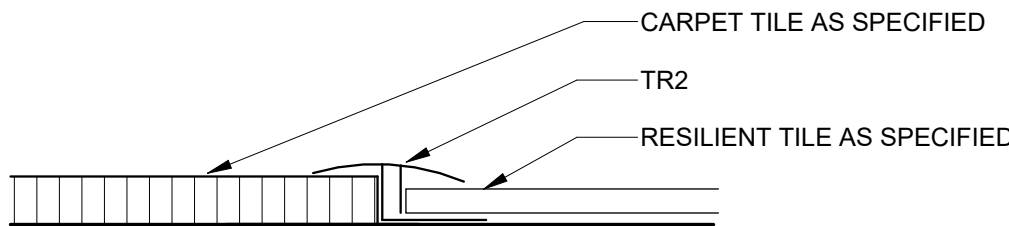


INTERIOR DETAIL - TR2 CARPET TO RESILIENT

12" = 1'-0"

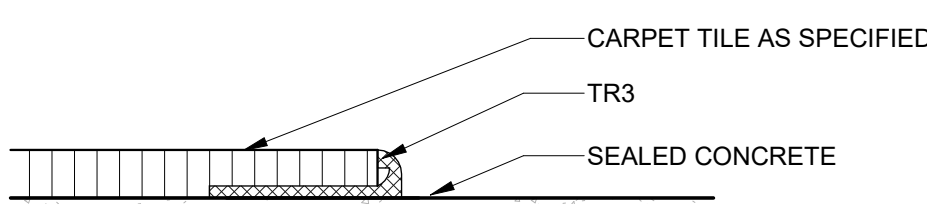


INTERIOR DETAIL - TR3 CARPET TO CONCRETE

12" = 1'-0"

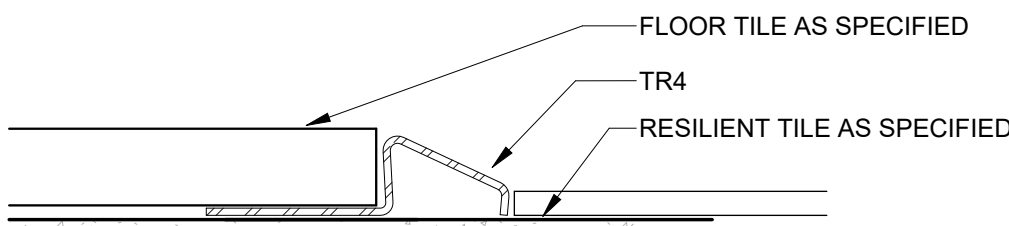


INTERIOR DETAIL - TR4 RESILIENT TO FLOOR TILE

12" = 1'-0"

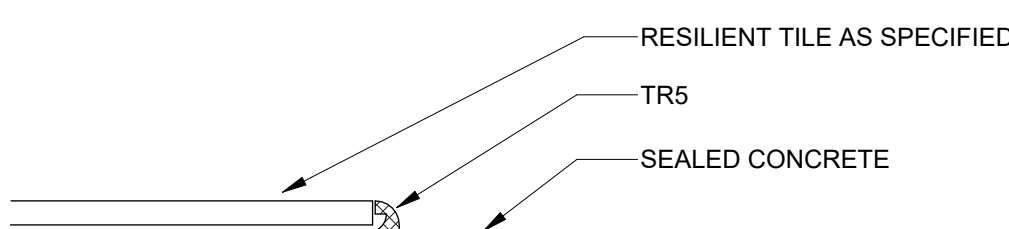


INTERIOR DETAIL - TR5 RESILIENT TO CONCRETE

12" = 1'-0"

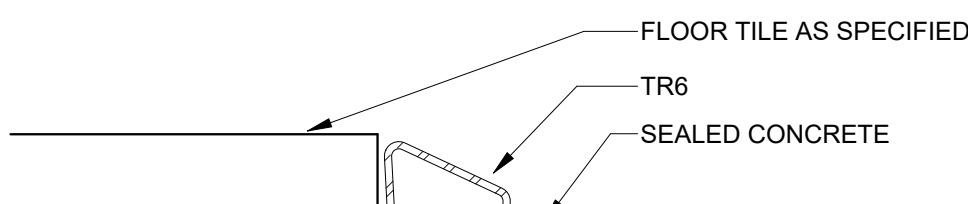

INTERIOR DETAIL - TR6 FLOOR TILE TO CONCRETE


12" = 1'-0"

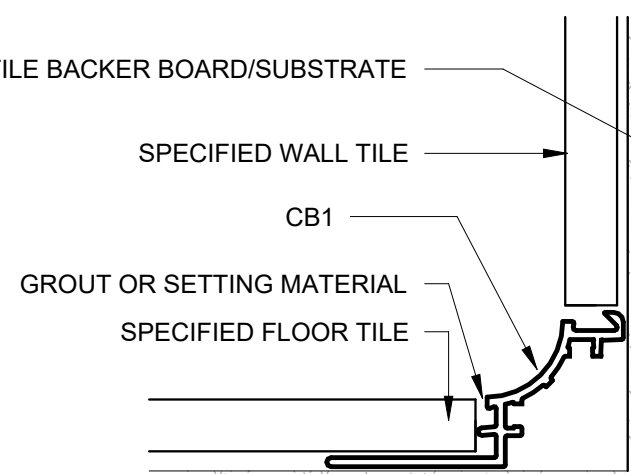

revised see Attachment A Page 3.


INTERIOR DETAIL - TILE COVE BASE

12" = 1'-0"

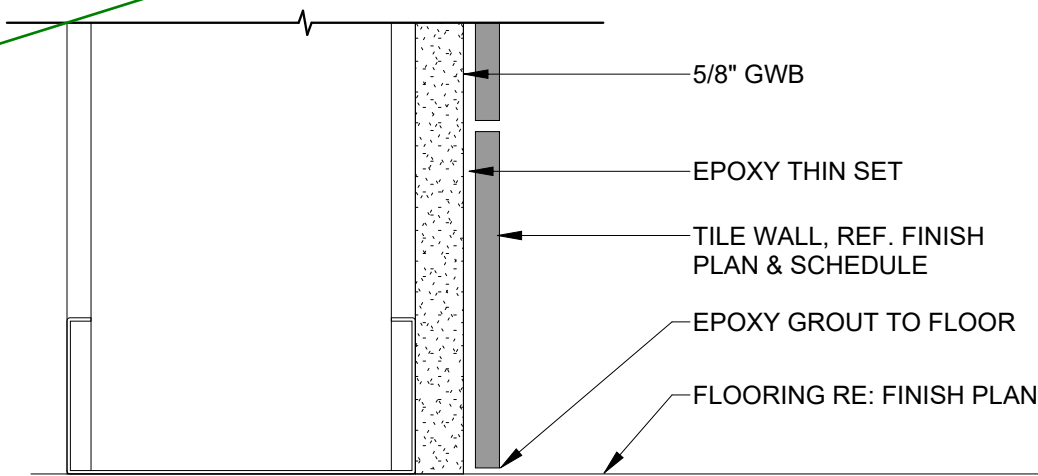

INTERIOR DETAIL - TILE WALL BASE


6" = 1'-0"

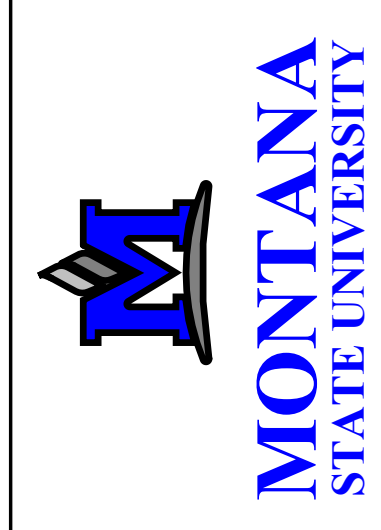

MARK & ROBYN JONES COLLEGE OF NURSING - BILLINGS MONTANA STATE UNIVERSITY


Cushing Terrell co ARCHITECTS

|              |             |
|--------------|-------------|
| DRAWN BY:    | LAST        |
| REVIEWED BY: | NARE        |
| REV.         | DESCRIPTION |
|              |             |
|              |             |
|              |             |

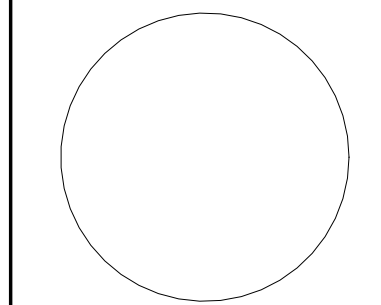

PPA#21-0169  
A/E#: 2022-02-09-03  
SHEET TITLE  
INTERIOR MATERIALS  
SCHEDULES AND  
DETAILS  
SHEET  
A503  
DATE  
04.05.2024



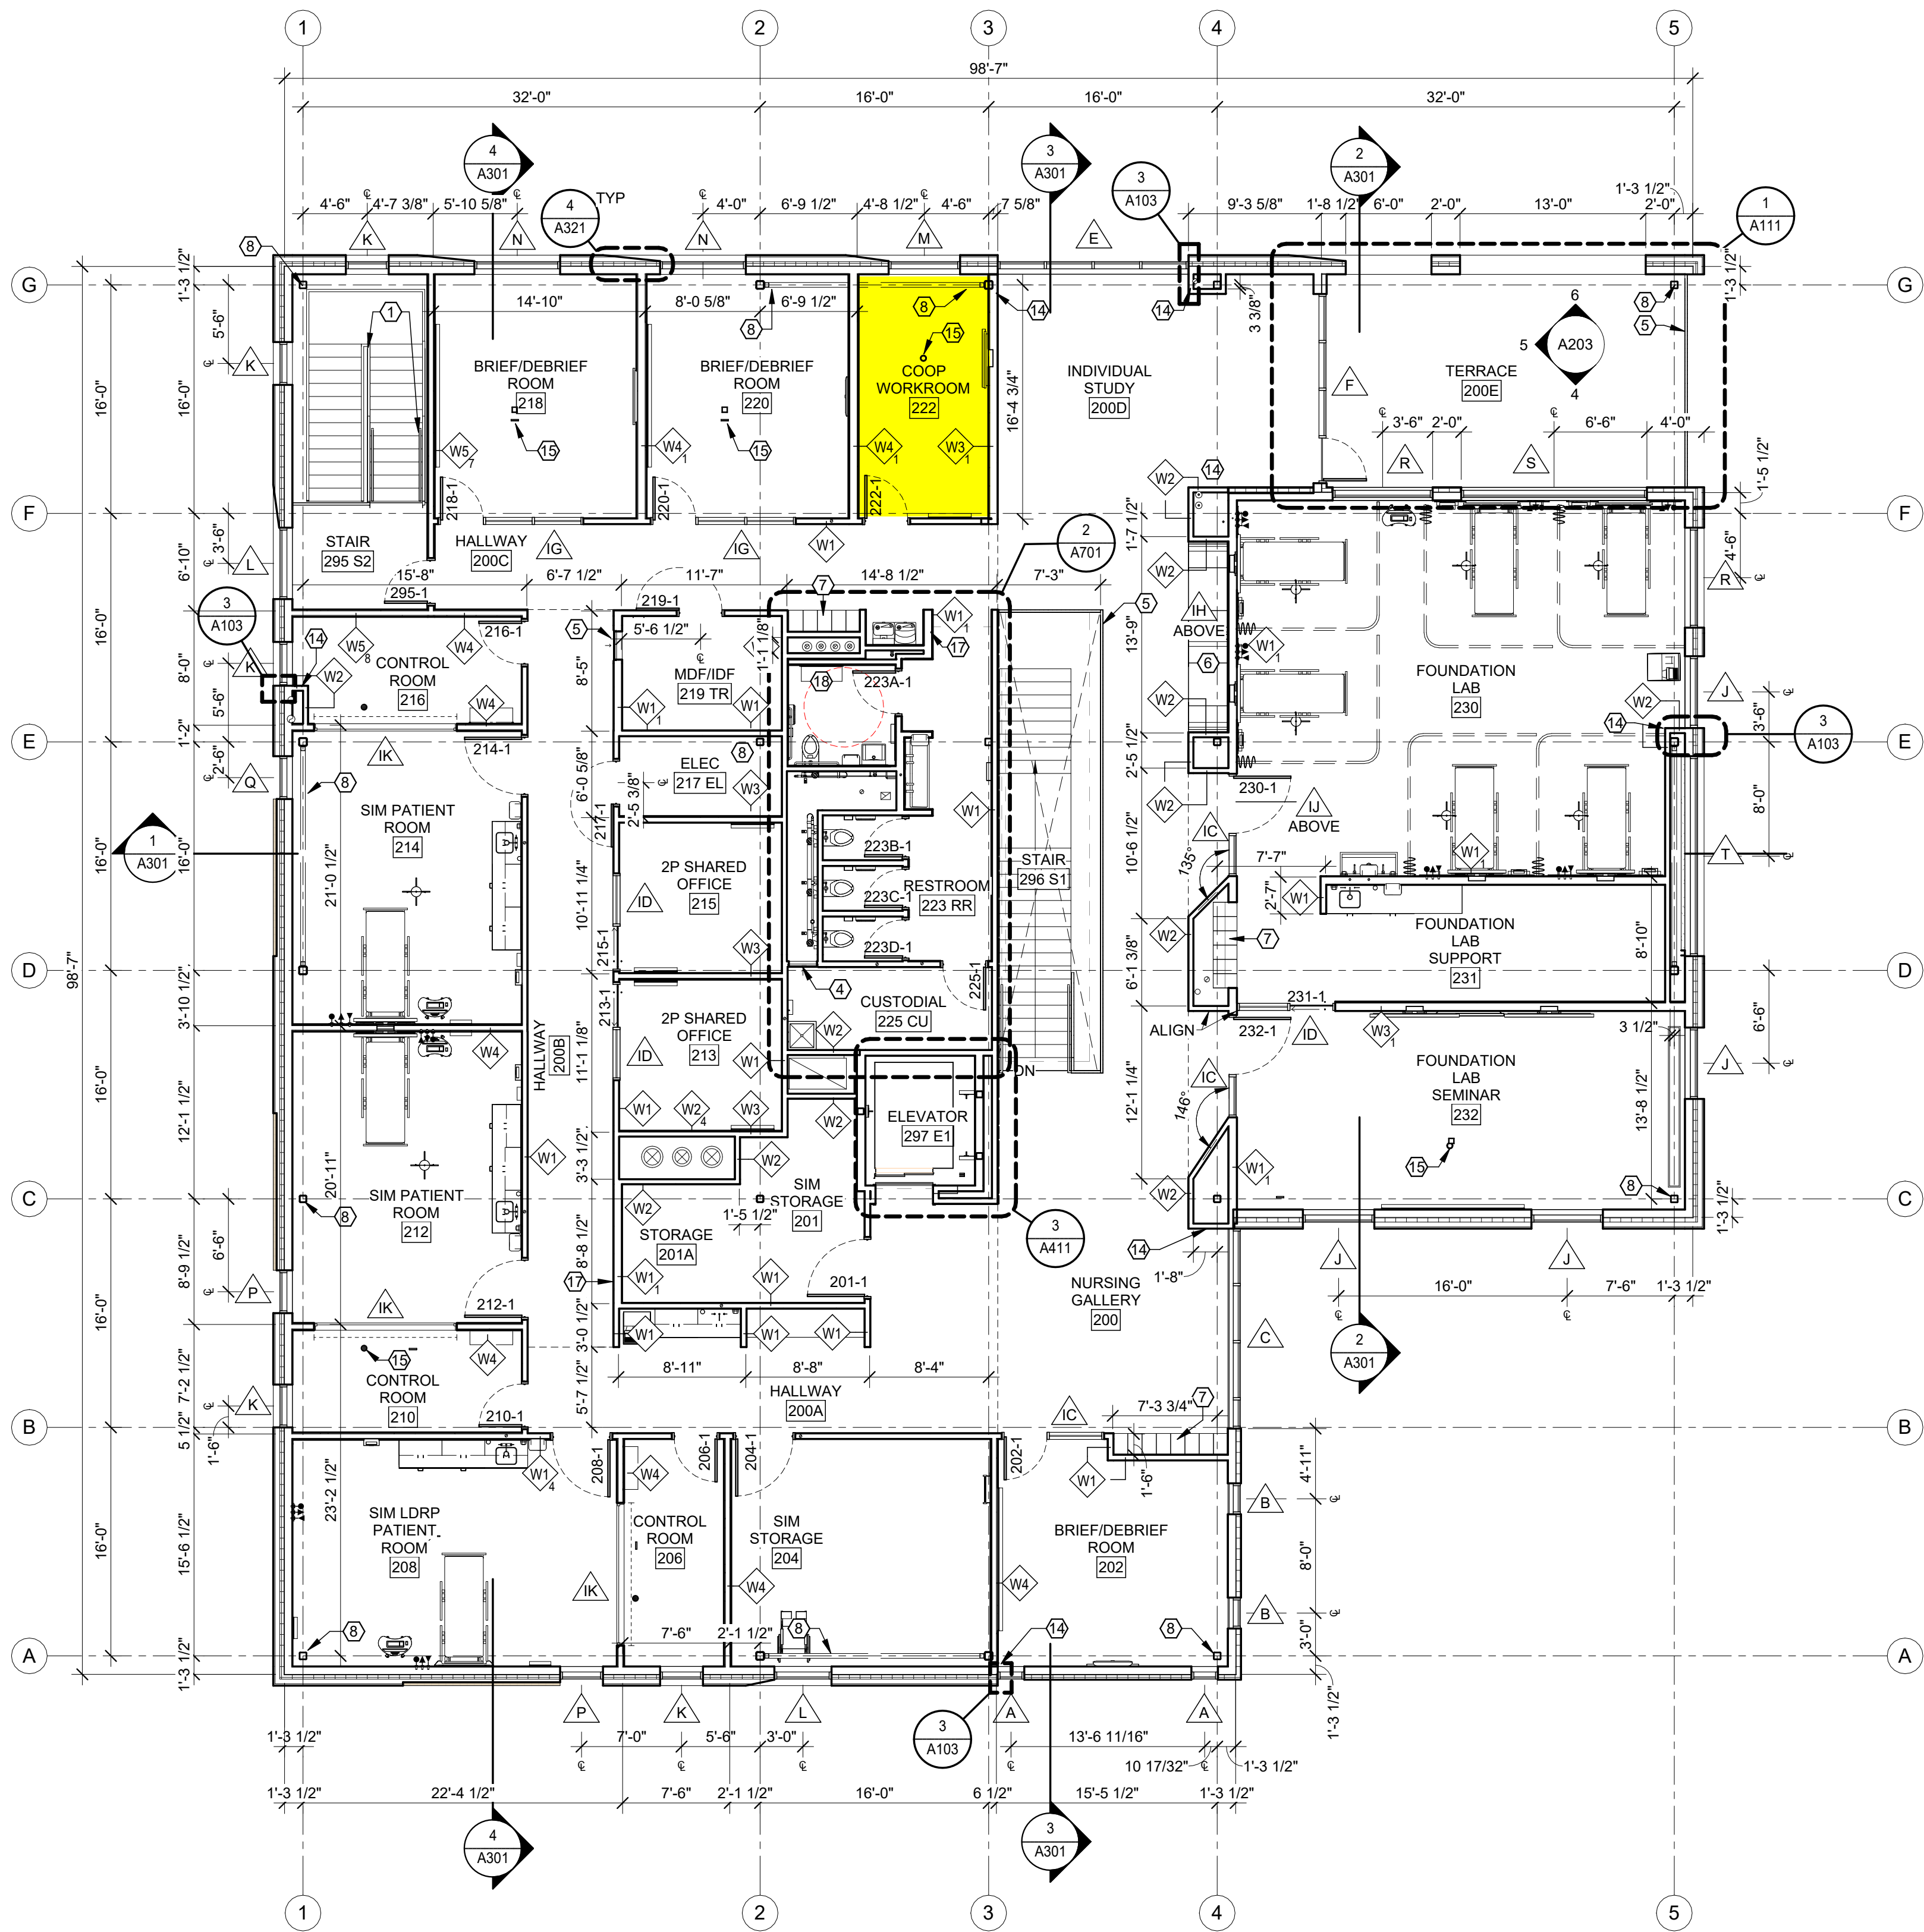

1 SECOND FLOOR PLAN  
1/8" = 1'-0"



## PLAN LEGEND

- W# — ASSEMBLY TYPE (SEE ASSEMBLIES SHEET)
- 1 — ASSEMBLY MODIFIER, PER TYPE
- NAME 101 — ROOM NAME AND NUMBER
- X — WINDOW TYPE (SEE A600s)
- (X) — KEYNOTE
- SIM — DIRECTION OF VIEW, IF APPLICABLE
- 1 — DRAWING NUMBER
- X000 — SHEET WHERE DRAWN
- 101-1 — DOOR NUMBER (SEE SHEET A601)
- DIMENSION TO FACE OF FRAMING
- DIMENSION TO GRID LINE
- DIMENSION TO CENTER LINE

## GENERAL PLAN NOTES

- A. SEE A500 SHEETS FOR ALL FINISH REQUIREMENTS & SPECIFICATIONS
- B. SEE A600 SHEETS FOR WINDOW AND DOOR SCHEDULES
- C. SEE A700 SHEETS FOR INTERIOR ELEVATIONS
- D. COORDINATE WITH BUILDING SECTIONS AND STRUCTURAL DRAWINGS FOR FINISH FLOOR ELEVATIONS
- E. SEE G100 SHEETS REGARDING BUILDING CODE REQUIREMENTS
- F. SEE SHEET A002 FOR TYPICAL EXTERIOR AND INTERIOR WALL TYPE ASSEMBLIES
- G. SEE A800 SHEETS FOR REFLECTED CEILING PLANS AND DETAILS
- H. PROVIDE FIRE RETARDANT TREATED BLOCKING IN WALL FOR ALL MOUNTED EQUIPMENT, MILLWORK, AND HARDWARE PER SPECIFICATION DIVISION 6, SECTION "MISCELLANEOUS ROUGH CARPENTRY"
- I. FIELD VERIFY ALL CASEWORK AND BUILT IN COMPONENTS PRIOR TO FABRICATION
- J. COORDINATE ALL PLUMBING FIXTURE LOCATIONS WITH PLUMBING DRAWINGS
- K. SEE G007 FOR INTERIOR PERSPECTIVE VIEWS
- L. PROVIDE BLOCKING IN WALLS AS NEEDED FOR ALL WALL-MOUNTED EQUIPMENT, CASEWORK, AND ACCESSORIES.

## # KEYNOTES

- 1. METAL GUARDRAIL. SEE A402 FOR DETAIL. SAME AS PRIMARY STAIR GUARDRAIL.
- 2. SOLID PANEL OPERABLE PARTITION WALL SYSTEM, SEE SPEC.
- 3. DOOR TO BE RECESSED INTO ADJACENT WALLS, SEE DOOR SCHEDULE AND DETAIL 3/A602, TYPICAL BOTH SIDES.
- 4. 24" x 48" ACCESS PANEL. MOUNT FLUSH WITHIN WALL 6" ABOVE FINISH FLOOR. PAINT TO MATCH ADJACENT WALL.
- 5. 24" x 24" ACCESS PANEL. MOUNT FLUSH WITHIN WALL 5' TO CENTERLINE OF PANEL. PAINT TO MATCH ADJACENT WALL.
- 6. CUSTOM BUILT-IN SEAT & TABLE NOOK. SEE A803.
- 7. LOCKERS. SEE FINISH PLANS.
- 8. EXPOSED STRUCTURE, TYPICAL. PAINT. SEE SEE STRUCTURAL AND FINISH PLANS.
- 9. CANE RAIL. SEE DETAIL 1/A103.
- 10. WALK OFF GRATE. SEE STRUCTURAL, LANDSCAPE, AND CIVIL.
- 11. KNOX BOX. SEE FIRE ALARM.
- 12. ADA COMPLIANT HEAVY DUTY TOWER PEDESTAL. BASIS OF DESIGN: INTERCOM ONLINE PD1054, 47 INCHES TALL, POWDER COATED BLACK, TWO SINGLE GANG BOX CUTOUTS (1) FOR CARD READER, COORDINATE WITH ACCESS CONTROLS (1) FOR ADA BUTTON. COORDINATE WITH AUTOMATIC OPERATORS.
- 13. WALL MOUNTED ADA OPERATOR DOOR ACTUATOR LOCATION, SEE HARDWARE SPEC AND COORDINATE WITH ELECTRICAL.
- 14. ALIGN WALL WITH WINDOW OPENING PER 3/A103.
- 15. A/V COMPONENTS. SEE A/V DRAWINGS.
- 16. FIRE DEPARTMENT CONNECTION. SEE FIRE PROTETION.
- 17. RECESSED FIRE EXTINGUISHER CABINET.
- 18. CHANGING TABLE, PROVIDE BLOCKING.



MARK & ROBYN JONES COLLEGE  
OF NURSING - KALISPELL  
MONTANA STATE UNIVERSITY

Cushing  
Terrell  
CO ARCHITECTS

|              |             |      |
|--------------|-------------|------|
| DRAWN BY:    |             | CO   |
| REVIEWED BY: |             | SP   |
| REV.         | DESCRIPTION | DATE |
|              |             |      |
|              |             |      |
|              |             |      |
|              |             |      |



PPA#21-0168


A/E#:2022-02-09-04

SHEET TITLE  
SECOND FLOOR PLAN

SHEET  
A102

DATE  
4.17.2024



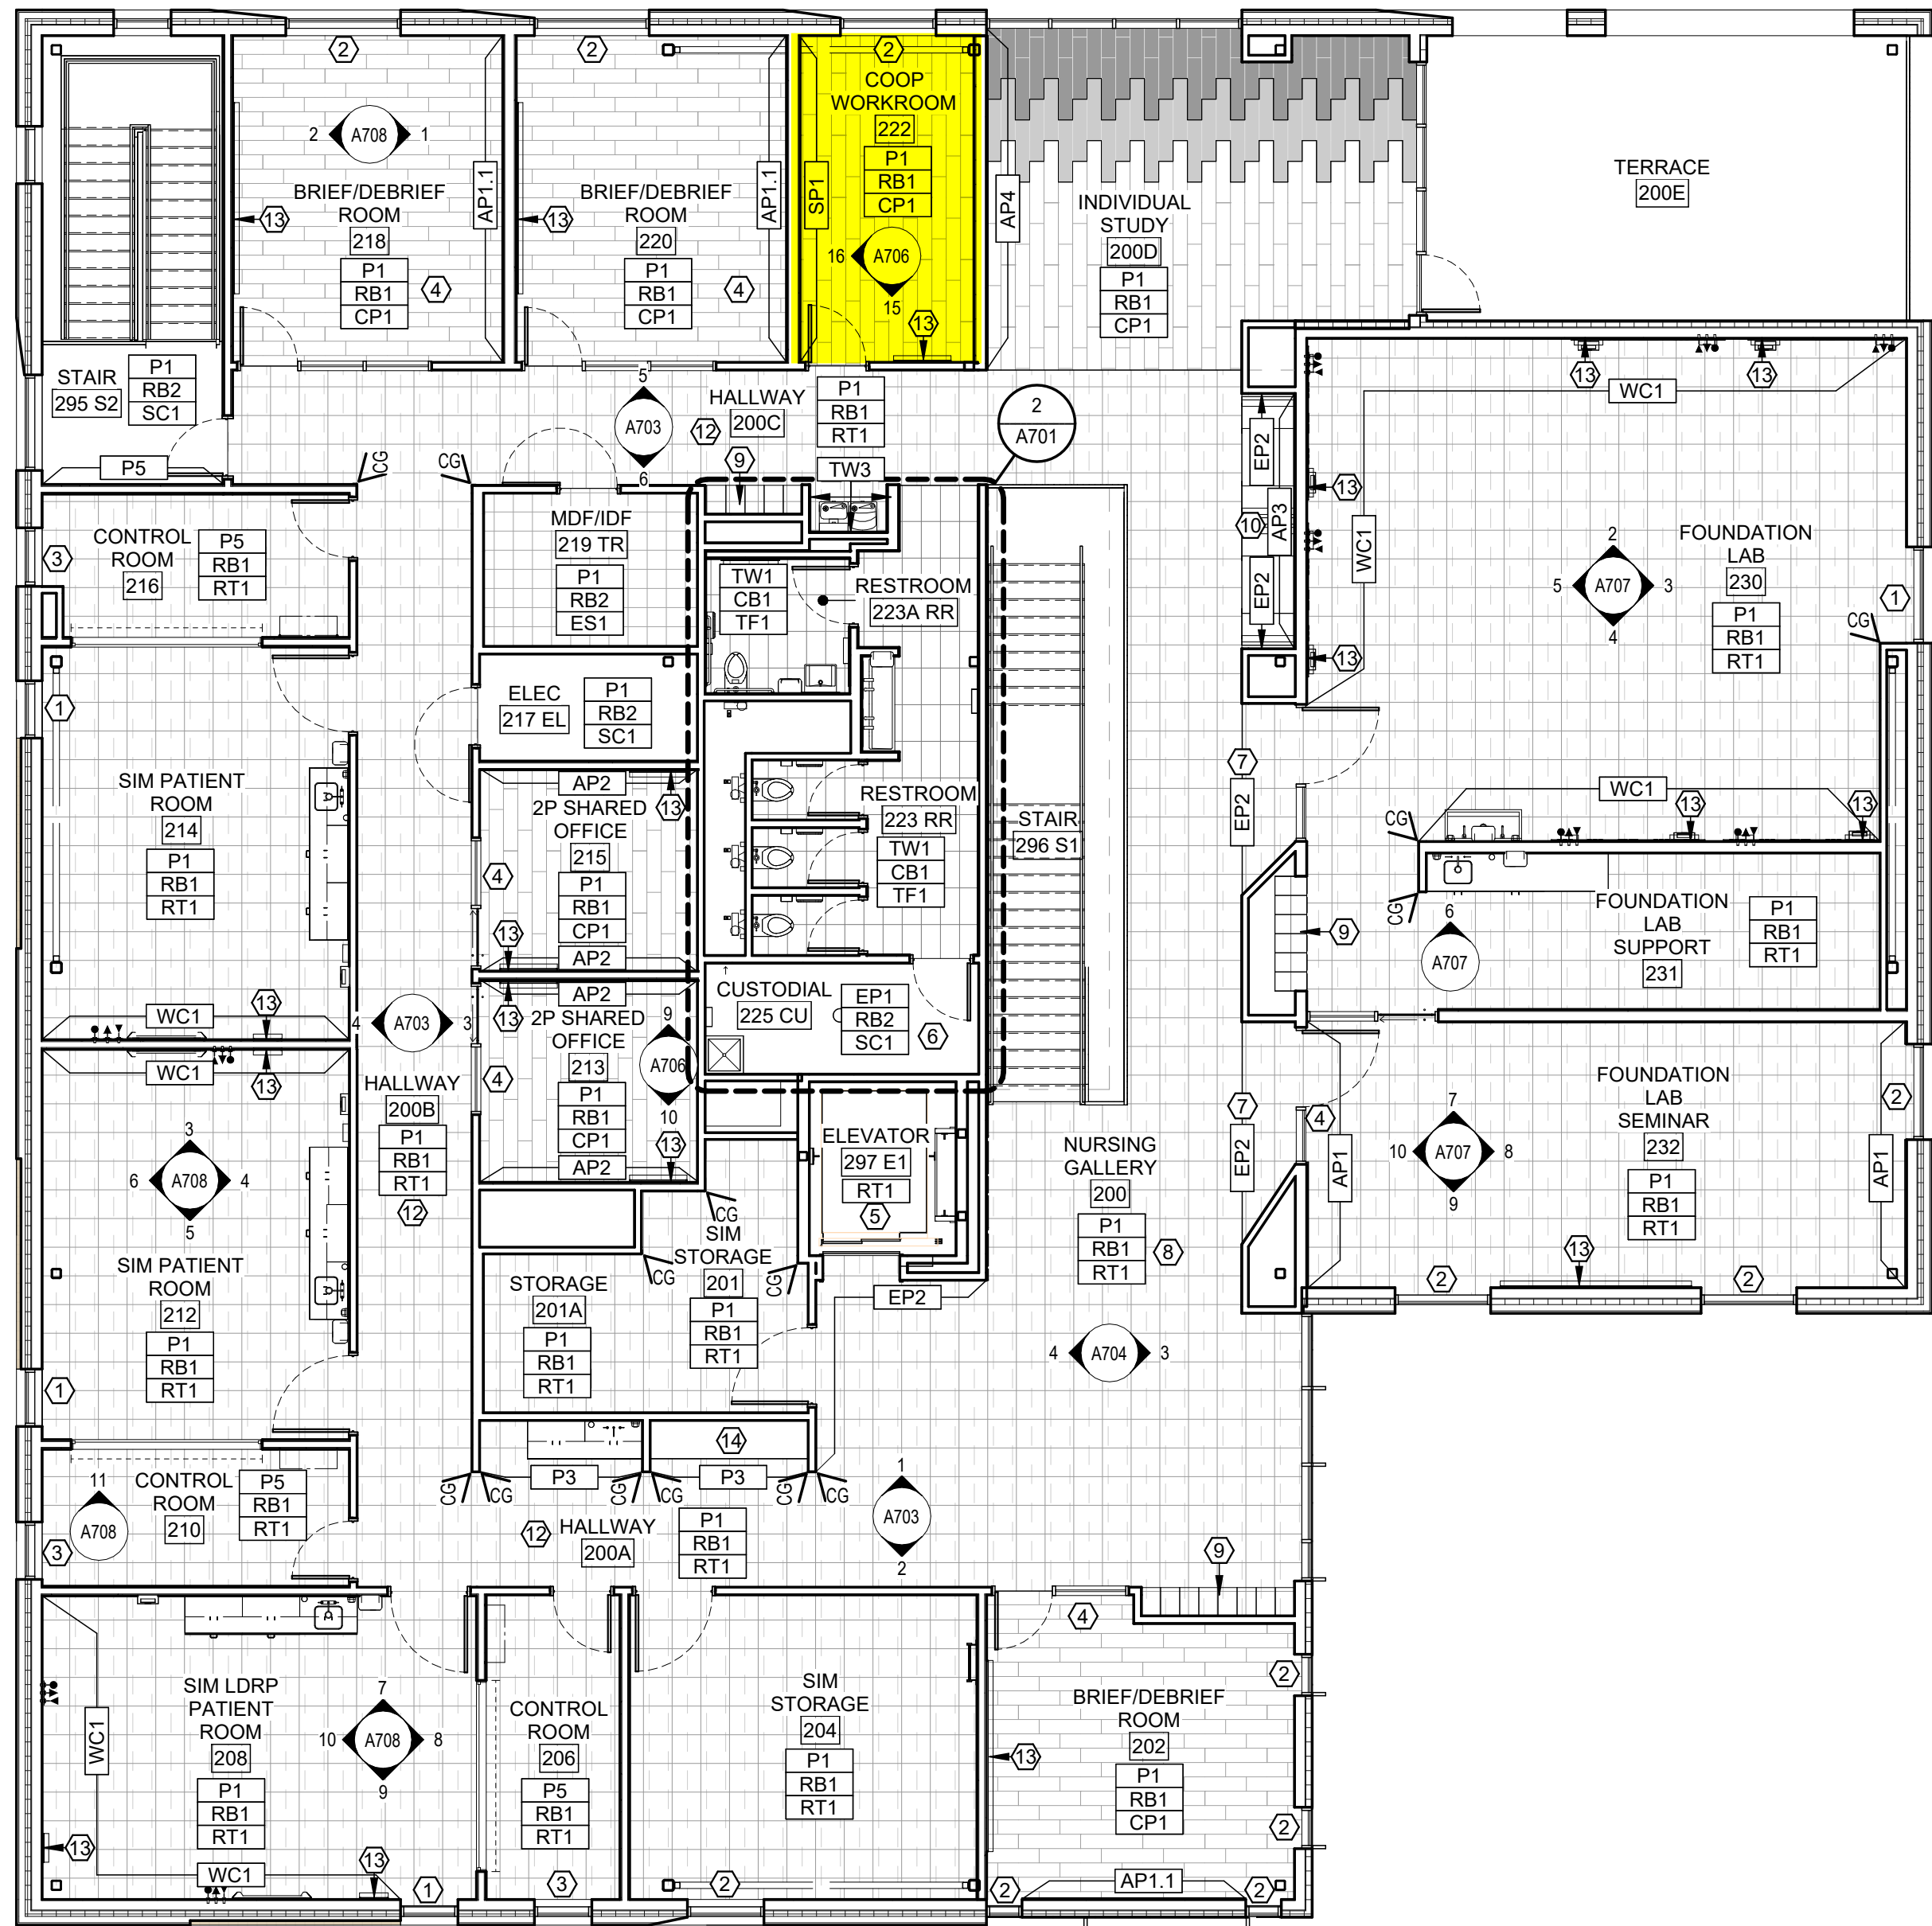

1 SECOND FLOOR FINISH PLAN  
1/8" = 1'-0"



## FINISH PLAN LEGEND

- NAME  
101 ROOM NAME AND NUMBER
- A8## # INTERIOR ELEVATION CALLOUT AND DIRECTION OF ELEVATION VIEW
- XX### FINISH TAG
- XX### EXTENT OF ACCENT PAINT OR WALL FINISHES

FINISH TAGS DISPLAYED IN GROUPING ON FINISH PLAN REPRESENT MAJORITY ROOM FINISH SELECTIONS. ORDER OF GROUPING DEFINED IN EXAMPLE BELOW:

- XX### MAJORITY WALL FINISH  
XX### MAJORITY BASE FINISH  
XX### MAJORITY FLOOR FINISH

CG LOCATION AND TYPE OF CORNER GUARDS

- FLOOR FINISH 'CP1' FLOOR FINISH 'RT1'
- FLOOR FINISH 'CP2' FLOOR FINISH 'SC1'
- FLOOR FINISH 'CP3' FLOOR FINISH 'TF1'
- FLOOR FINISH 'EM1' FLOOR FINISH 'TF2'
- FLOOR FINISH 'EM2'
- FLOOR FINISH 'ES1'

## GENERAL FINISH NOTES

- VERIFY ALL CONDITIONS AND DIMENSIONS IN FIELD PRIOR TO FABRICATION.
- ALL PRODUCTS ARE TO BE INSTALLED PER MANUFACTURER'S INSTRUCTIONS, USING MANUFACTURER'S ADHESIVES, TOOLS, AND METHODS.
- REFER TO SPECIFICATIONS AND MATERIAL FINISH LIST FOR ALL FINISH MATERIAL PRODUCT INFORMATION.
- FOR INTERIOR ELEVATIONS AND ADDITIONAL FINISHES, RE: A700'S.
- FOR CEILING HEIGHTS AND ADDITIONAL FINISHES RE: A900'S.
- COORDINATE ALL OWNER FURNISHED EQUIPMENT, ACCESSORIES, AND FURNITURE WITH OWNER AND/OR OWNER'S VENDOR.
- ALL FLOOR TRANSITIONS ARE TO OCCUR DIRECTLY BENEATH DOORS OR CENTERED IN OPENING UNLESS OTHERWISE NOTED. TRANSITIONS ARE TO BE ADA COMPLIANT.
- REFER TO FINISH PLAN FOR LOCATION OF CORNER GUARDS. INSTALL AT TOP OF WALL BASE.
- ALL GYPSUM WALLS TO BE PAINTED 'P1' UNLESS OTHERWISE NOTED.
- ALL GYPSUM CEILINGS AND SOFFITS TO BE PAINTED 'P1' UNLESS OTHERWISE NOTED ON REFLECTED CEILING PLAN.
- ALL WALL BASE TO BE 'RB1' UNLESS OTHERWISE NOTED.
- ALL HOLLOW METAL FRAMES TO BE PAINTED TO MATCH ADJACENT WALL COLOR IN SEMI-GLOSS FINISH, UNLESS OTHERWISE NOTED.
- ALL METAL ACCESS PANELS, COVER PLATES, VENTS, AND GRILLES TO BE PAINTED TO MATCH THE SURFACE IT IS LOCATED ON.
- ALL QUARTZ AND SOLID SURFACE COUNTERTOPS TO HAVE EASED EDGES. ADJACENT BACKSPLASH TO MATCH. UNLESS OTHERWISE NOTED.
- ALL WINDOW TREATMENTS ARE TO BE FIELD MEASURED, INSTALLED WITH ALL COMPONENTS, AND INSIDE MOUNTED, UNLESS OTHERWISE NOTED.
- ALL WALLS TO RECEIVE CUSTOM GRAPHIC TO HAVE A LEVEL 5 GYP FINISH.
- ALL LEARNING STUDIOS, LABS, CONFERENCE ROOMS, AND OFFICES TO RECEIVE 'WH1' WHITEBOARD. REFER TO MATERIAL FINISH LIST FOR PRODUCT SPECIFICATIONS AND ELEVATIONS FOR SIZING.
- FOR ALL FLOORING AND WALL TRANSITIONS REFER TO MATERIAL FINISH LIST FOR PRODUCT SPECIFICATIONS. GC IS RESPONSIBLE TO PROVIDE THE CORRECT SIZING FOR TRANSITIONS.
- SEE RCP FOR PAINTED DRYFALL SYSTEM AND ACOUSTIC SPRAY SYSTEM.
- PAINT ALL EXPOSED STRUCTURAL STEEL COLUMNS, CROSS BRACING, ETC. WITH 'P1' SEMI-GLOSS FINISH, UNLESS NOTED OTHERWISE.

## KEYNOTES


- MOTORIZED AND CONTROLLED ROLLER SHADES 'WS1' TO BE INSTALLED ON EXTERIOR WINDOWS IN THIS ROOM. REFER TO MATERIAL FINISH LIST FOR PRODUCT SPECIFICATIONS. COORDINATE POWER AND AUTOMATION WITH ELECTRICAL.
- MANUAL ROLLER SHADES 'WS2' ON EXTERIOR WINDOWS IN THIS ROOM. REFER TO MATERIAL FINISH LIST FOR PRODUCT SPECIFICATIONS.
- MANUAL ROLLER SHADES 'WS3' ON EXTERIOR WINDOWS IN THIS ROOM.
- INSTALL PRIVACY WINDOW FILM 'WF1' ON GLAZING IN THIS ROOM. REFER TO MATERIAL FINISH LIST FOR PRODUCT SPECIFICATIONS. REFER TO DOOR SCHEDULE FOR MOUNTING HEIGHTS.
- ELEVATOR CAB FINISHES TO BE SELECTED BY ARCHITECT FROM VENDORS FULL RANGE, INCLUDING WALL AND CEILING PANELS, HAND RAILS, AND FLOORING.
- INSTALL 'FRP1' ON ALL WALLS IN THIS ROOM. 4FT HIGH TO START AT TOP OF BASE.
- PAINT ALL WALLS WITHIN 'EP2'. CEILING TO BE CLAD WITH 'WDW1'.
- SEE ISOMETRICS, ELEVATIONS, RENDERINGS FOR DESIGN AND MATERIAL INTENT.
- SEE MATERIAL FINISH LIST 'LK1' AND 'LK1.1' FOR LOCKER SPECIFICATION. VENDOR PROVIDED, VENDOR INSTALLED.
- CUSTOM BOOTH SEATING AND TABLES. SEE ELEVATIONS, RENDERINGS AND DETAILS FOR CONSTRUCTION AND DESIGN INTENT. REFER TO MATERIAL FINISH LIST FOR UPHOLSTERY.
- INSTALL 'WP1' ON ALL WALLS IN THIS ROOM. 4FT HIGH TO START AT TOP OF FINISHED FLOOR. INSTALL WALL BASE ON TOP OF WP#.
- WHITEBOARD 'WH1' LOCATED ON THIS WALL. REFER TO MATERIAL FINISH LIST FOR PRODUCT SPECIFICATIONS, SIZE AND LOCATION.
- CUSTOM MILLWORK. SEE ELEVATION FOR DETAILS.



MARK & ROBYN JONES COLLEGE  
OF NURSING - KALISPELL  
MONTANA STATE UNIVERSITY

Cushing  
Terrell  
ARCHITECTS

DRAWN BY: LD  
REVIEWED BY: MH  
REV. DESCRIPTION DATE

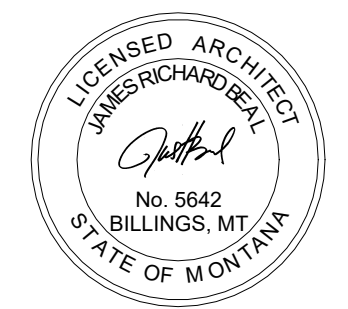

PPA#21-0168


A/E#2022-02-09-04

SHEET TITLE  
SECOND FLOOR  
FINISH PLAN


SHEET  
A502

DATE  
4.17.2024




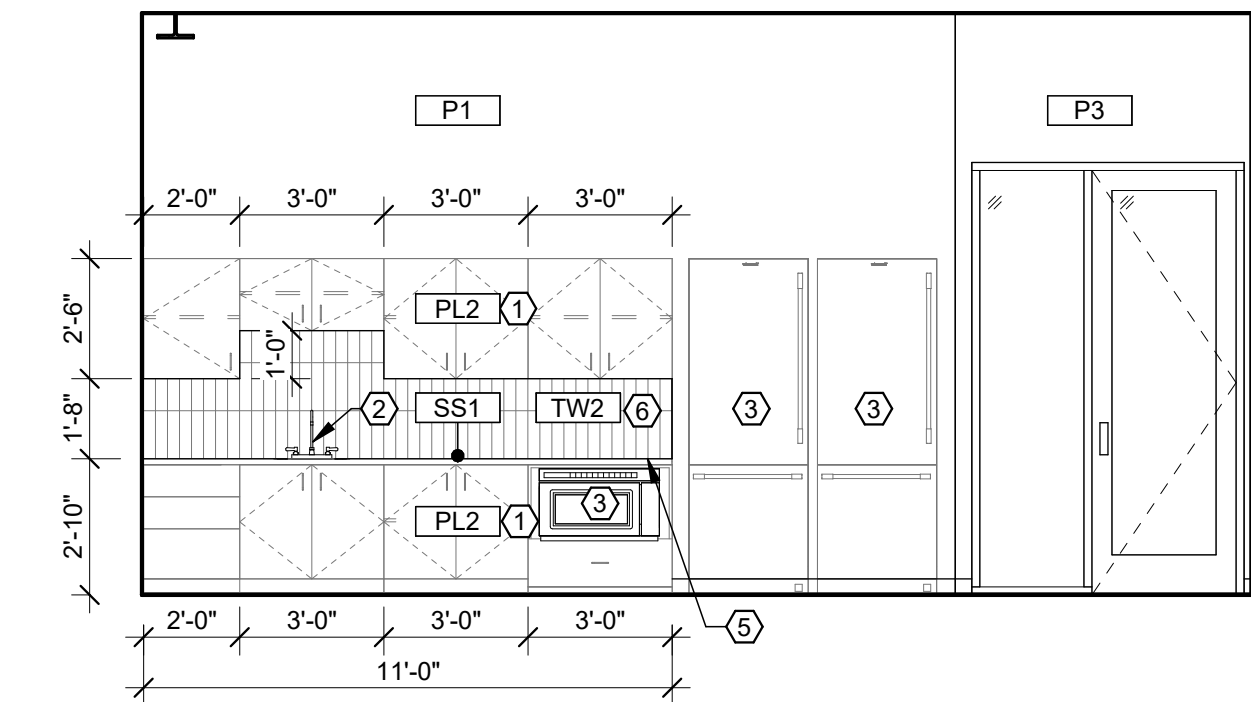


1 NOURISHMENT 104 - NORTH  
A706 1/4" = 1'-0"

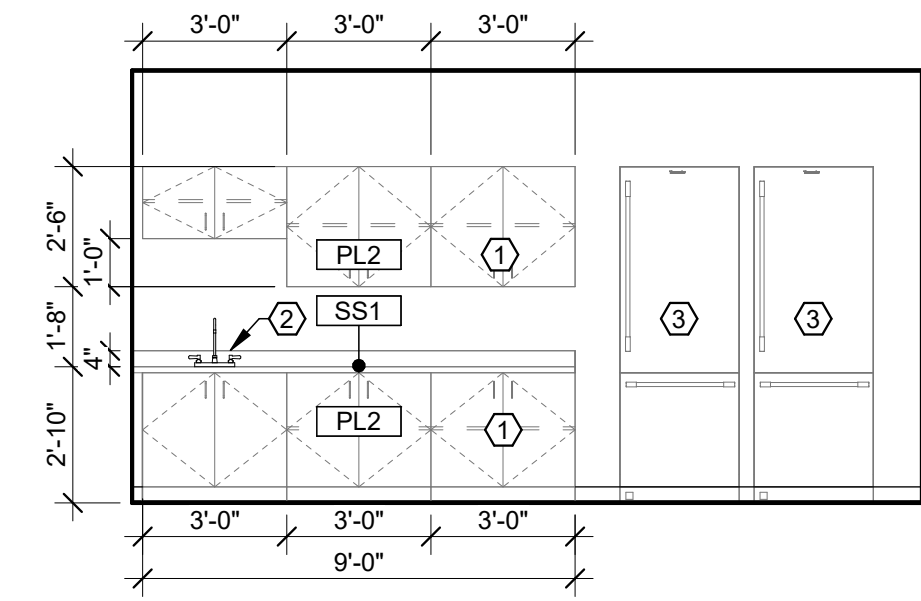


2 FACULTY LOUNGE 124 - WEST  
A706 1/4" = 1'-0"

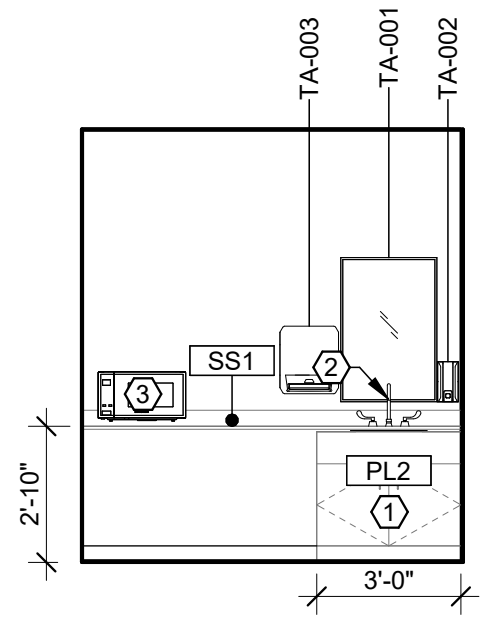


3 FAMILY CARE 126 - NORTH  
A706 1/4" = 1'-0"

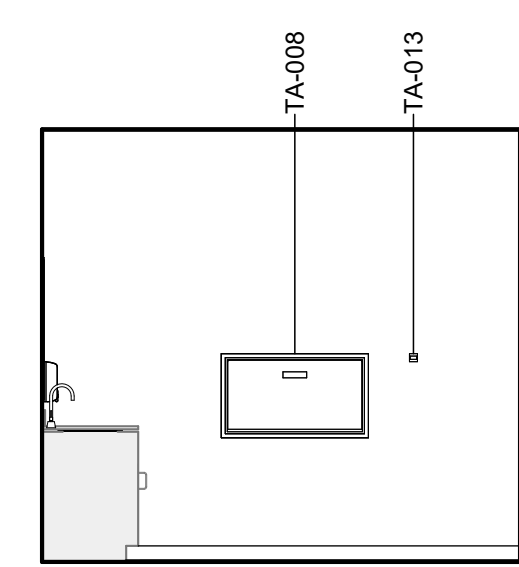


4 FAMILY CARE 126 - EAST  
A706 1/4" = 1'-0"

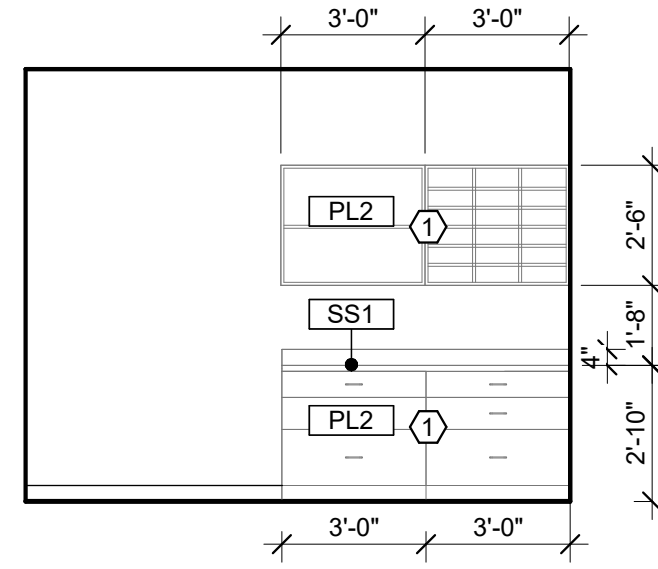


5 ADMIN SUPPORT 111 - NORTH  
A706 1/4" = 1'-0"

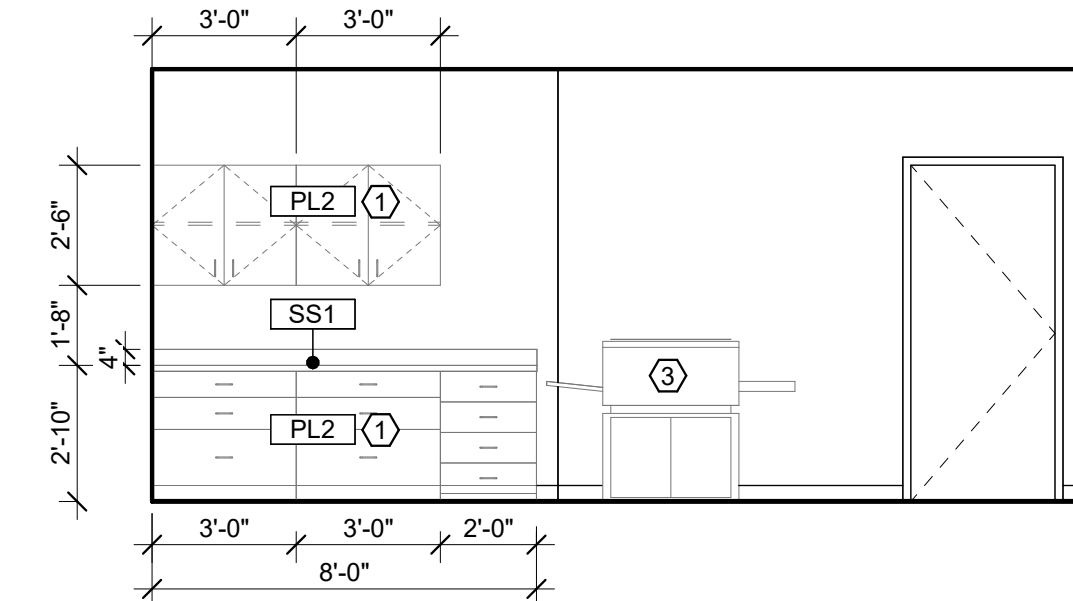


6 ADMIN SUPPORT 111 - WEST  
A706 1/4" = 1'-0"

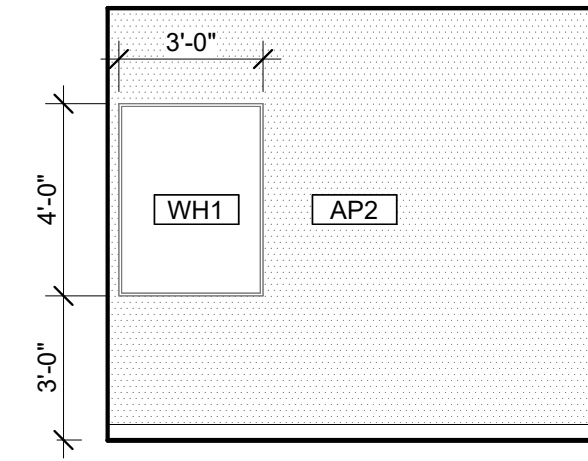


7 TYP. PRIVATE OFFICE - EAST  
A706 1/4" = 1'-0" TYPICAL AT 108, 114, 116, 118, 120

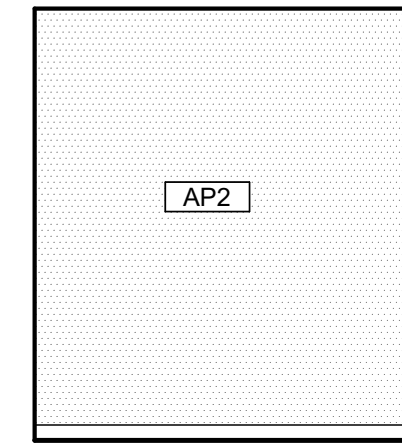


8 TYP. PRIVATE OFFICE - SOUTH  
A706 1/4" = 1'-0" TYPICAL AT 108, 114, 116, 118, 120

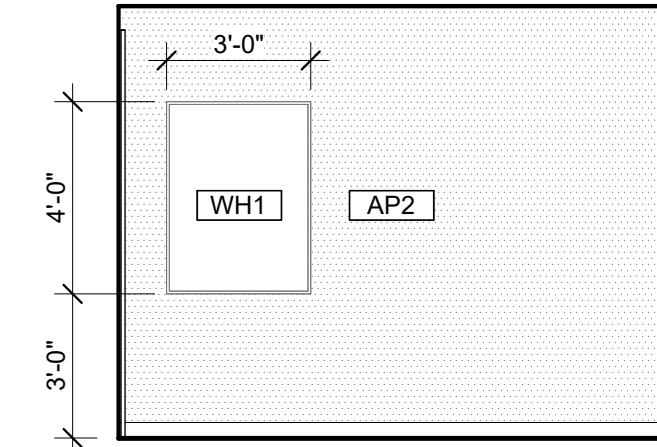


9 TYP. 2P OFFICE - NORTH  
A706 1/4" = 1'-0" TYPICAL AT 213, 215

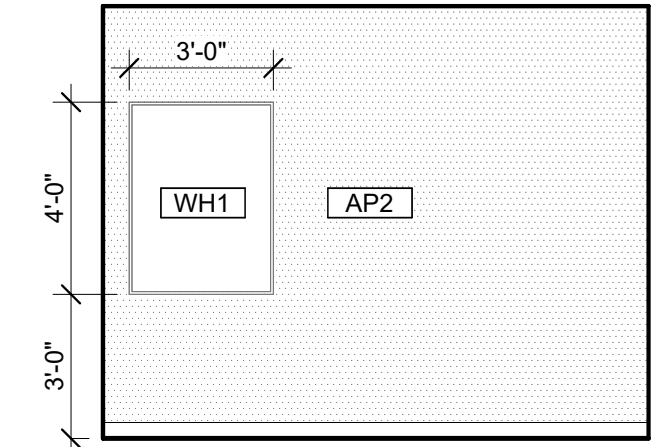


10 TYP. 2P OFFICE - SOUTH  
A706 1/4" = 1'-0" TYPICAL AT 213, 215

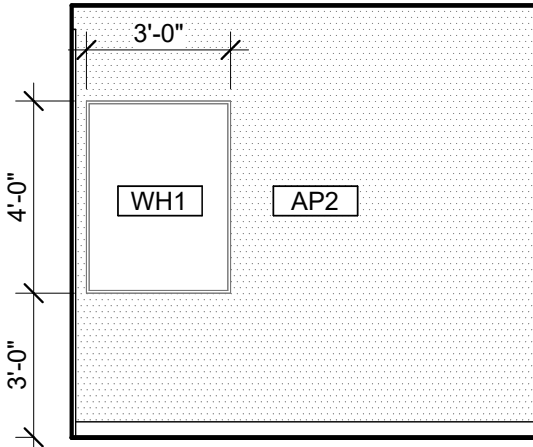


11 TYP. PRIVATE MEET - EAST  
A706 1/4" = 1'-0" TYPICAL AT 112, 113

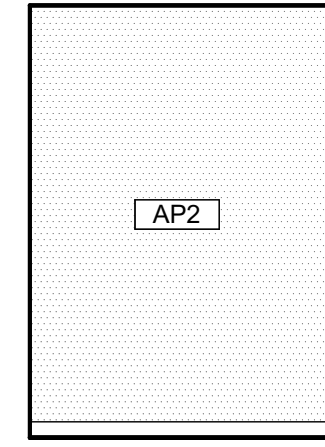


12 TYP. PRIVATE MEET - SOUTH  
A706 1/4" = 1'-0" TYPICAL AT 112, 113

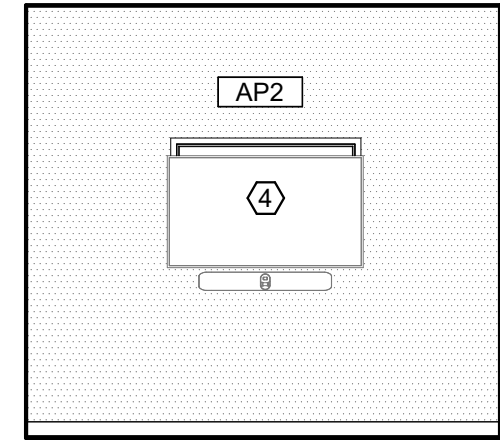


13 4P HUDDLE SPACE - EAST  
A706 1/4" = 1'-0"

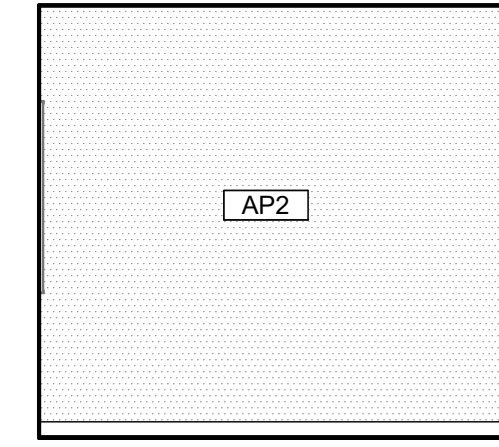


14 4P HUDDLE SPACE - WEST  
A706 1/4" = 1'-0"

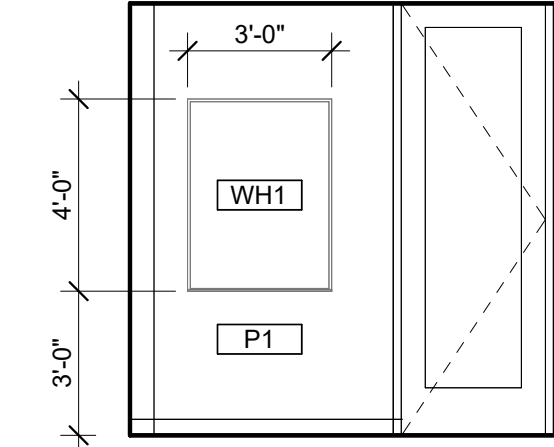


15 COOP WORKROOM 222 - SOUTH  
A706 1/4" = 1'-0"

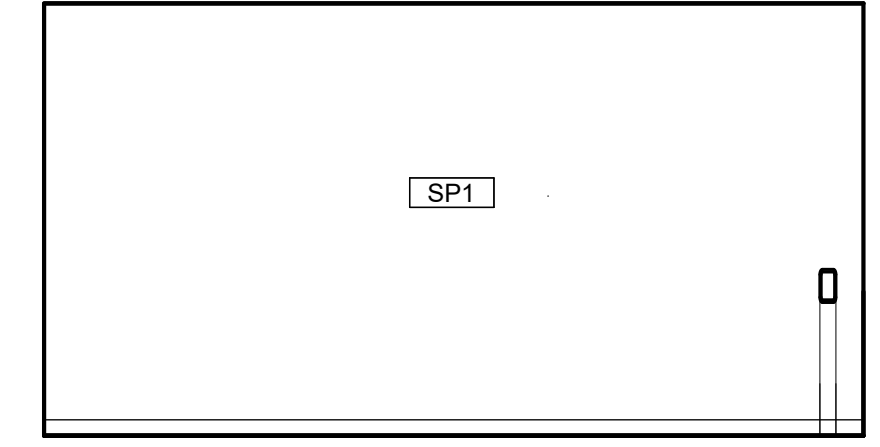


16 COOP WORKROOM 222 - WEST  
A706 1/4" = 1'-0"

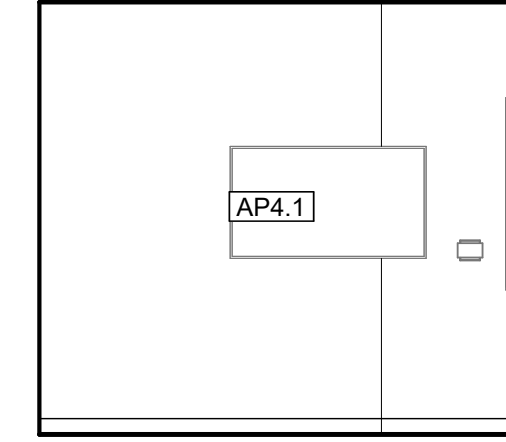

17 6P GROUP STUDY 102 - NORTH  
A706 1/4" = 1'-0"

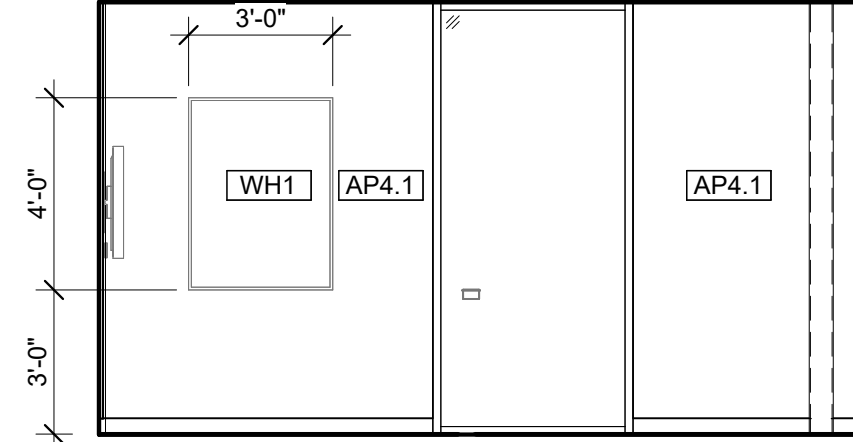

18 6P GROUP STUDY 102 - EAST  
A706 1/4" = 1'-0"

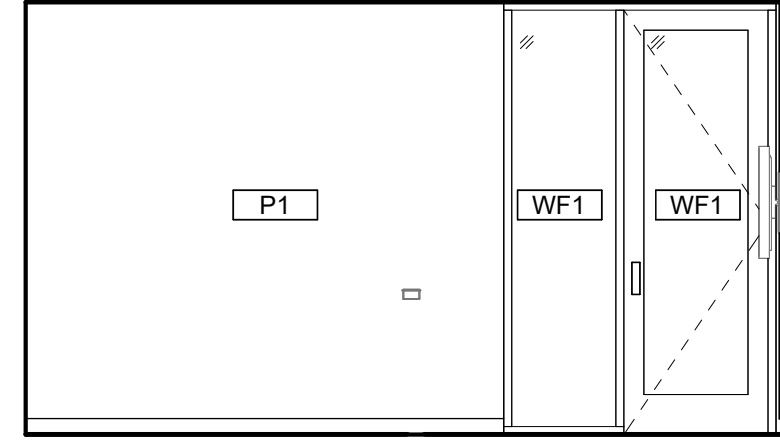

19 6P GROUP STUDY 102 - WEST  
A706 1/4" = 1'-0"

## GENERAL INTERIOR ELEVATION NOTES

- A. SEE A701 FOR TOILET AND LAV ACCESSORY SCHEDULE.  
B. SEE A503 FOR MATERIAL/FINISH ABBREVIATION LIST.  
C. PAINT ALL EXPOSED STRUCTURAL STEEL COLUMNS, CROSS BRACING, ETC. WITH 'P1' SEMI-GLOSS FINISH. UNLESS NOTED OTHERWISE.

## # KEYNOTES


- 1 MODULAR CASEWORK AND COUNTERTOP VENDOR PROVIDED. VENDOR INSTALLED. SEE SHEET A801 AND MATERIAL FINISH LIST FOR PRODUCT SPECIFICATIONS.  
2 FAUCET BY GC/PLUMBING SUB. COORDINATE WITH MODULAR CASEWORK VENDOR FOR INSTALLATION DIMENSIONS.  
3 EQUIPMENT NIC. REFER TO ELECTRICAL AND MECHANICAL PLANS FOR CONNECTIONS AND HEAT LOADS.  
4 AV MONITOR. REFER TO AV DRAWINGS FOR MOUNTING HEIGHTS.  
5 OMIT COUNTERTOP BACKSPLASH AT 'TW' LOCATIONS.  
6 TR10 AT ALL EXPOSED TILE OUTSIDE CORNERS.



MARK & ROBYN JONES COLLEGE  
OF NURSING - KALISPELL  
MONTANA STATE UNIVERSITY

Cushing  
Terrell  
ARCHITECTS

|              |             |      |
|--------------|-------------|------|
| DRAWN BY:    |             | LD   |
| REVIEWED BY: |             | MH   |
| REV.         | DESCRIPTION | DATE |
|              |             |      |
|              |             |      |
|              |             |      |

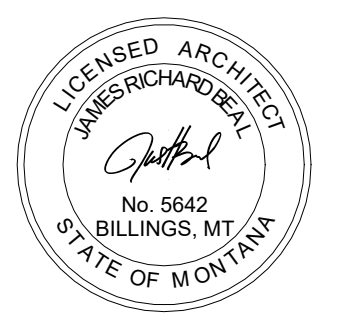

PPA#21-0168  
A/E#:2022-02-09-04

SHEET TITLE  
INTERIOR ELEVATIONS

SHEET  
A706

DATE  
4.17.2024



| MATERIALS LIST - BASIS OF DESIGN |                                    |                               |                                                                                                                |                                                                   |                                                                        |                                                                                                                                                                                                                |                                                 |
|----------------------------------|------------------------------------|-------------------------------|----------------------------------------------------------------------------------------------------------------|-------------------------------------------------------------------|------------------------------------------------------------------------|----------------------------------------------------------------------------------------------------------------------------------------------------------------------------------------------------------------|-------------------------------------------------|
| ITEM NO                          | PRODUCT TYPE                       | MANUFACTURER                  | DESCRIPTION                                                                                                    | COLOR                                                             | SIZE                                                                   | NOTES                                                                                                                                                                                                          | SUSTAINABILITY NOTES                            |
| BASE                             |                                    |                               |                                                                                                                |                                                                   |                                                                        |                                                                                                                                                                                                                |                                                 |
| CB1                              | INTEGRAL COVE BASE                 | SCHLUTER SYSTEMS              | DILEX-AHK COVE BASE                                                                                            | STAINLESS STEEL                                                   | GC TO CONFIRM SIZE WITH TILE ASSEMBLY                                  | TO BE USED WITH LATICRETE SPECTRALOCK EPOXY GROUT COLOR78 STERLING SILVER                                                                                                                                      | RECYCLED CONTENT, NON-EMITTING SOURCE OF VOCs   |
| RB1                              | RESILIENT BASE                     | JOHNSONITE                    | MILLWORK PROFILE MONUMENT                                                                                      | PEWTER CG                                                         | 4"HIGH                                                                 | MITER CORNER                                                                                                                                                                                                   | EPD, FLOORSORE, CRADLE TO GATE                  |
| RB2                              | RESILIENT BASE                     | JOHNSONITE                    | THERMOSET THERMOPLASTIC RUBBER COVE BASE                                                                       | PEWTER CG                                                         | 4"HIGH                                                                 | ROLLED GOODS                                                                                                                                                                                                   | EPD, FLOORSORE, CRADLE TO GATE                  |
| CEILING                          |                                    |                               |                                                                                                                |                                                                   |                                                                        |                                                                                                                                                                                                                |                                                 |
| AC1                              | ACOUSTIC CEILING                   | ARMSTRONG                     | CALLA MINERAL FIBER                                                                                            | WHITE                                                             | 2X2GRID, PRELUDE XL 15/16 SUSPENSION SYSTEM IN COLOR BLIZZARD WHITE    | -                                                                                                                                                                                                              | EPD, HPD, DECLARE, GREENGUARD                   |
| AC3                              | ACOUSTIC CEILING                   | FSORB                         | FSORB ACOUSTIC PANELING                                                                                        | WHITE                                                             | 1"THICK, 48"X96"                                                       | SEE RCPS. COORDINATE WITH MEP FIXTURES                                                                                                                                                                         | EPD, HPD, DECLARE, GREENGUARD                   |
| AC4                              | ACOUSTIC CEILING                   | ARMSTRONG                     | CALLA MINERAL FIBER                                                                                            | BLACK                                                             | 2X2GRID, PRELUDE XL 15/16 SUSPENSION SYSTEM IN COLOR CHARCOAL          | CONTROL ROOMS ONLY. SEE RCPS.COORDINATE WITH MEP FIXTURES                                                                                                                                                      | EPD, HPD, DECLARE, GREENGUARD                   |
| AL                               | ALUMINUM CEILING                   | LONGBOARD                     | ENDURA LINEAR DIRECT MOUNT CEILING. 6INCH V GROOVE PLANK                                                       | BEECHWOOD                                                         | -                                                                      | SEE RCPS.                                                                                                                                                                                                      | EPD                                             |
| ALP                              | ALUMINUM CEILING                   | LONGBOARD                     | ENDURA LINEAR DIRECT MOUNT CEILING. 6INCH V GROOVE PERFORATED PLANK. SOUNDTEX ACOUSTIC LINER                   | BEECHWOOD. SOUNDTEX BLACK                                         | -                                                                      | SEE RCPS. COORDINATE WITH MEP FIXTURES                                                                                                                                                                         | EPD                                             |
| BF1                              | BAFFLES                            | LONGBOARD                     | DAUNTLESS BAFFLE CEILING SYSTEM                                                                                | BEECHWOOD                                                         | 6" HIGH BAFFLE                                                         | SEE RCPS. COORDINATE WITH MEP FIXTURES                                                                                                                                                                         | EPD                                             |
| FLOOR                            |                                    |                               |                                                                                                                |                                                                   |                                                                        |                                                                                                                                                                                                                |                                                 |
| CP1                              | CARPET TILE                        | MILLIKEN                      | COLLECTION: LOW COUNTRY. PATTERN: SALT MARSH                                                                   | SLM13 FRIPP                                                       | 9.85"X39.4"                                                            | 33% OFFSET ASHLAR INSTALLATION                                                                                                                                                                                 | EPD, DECLARE, C2C                               |
| CP2                              | CARPET TILE                        | MILLIKEN                      | COLLECTION: LOW COUNTRY. PATTERN: SEA RISE                                                                     | SRS196-13 INDIGO PLANT                                            | 9.85"X39.4"                                                            | 33% OFFSET ASHLAR INSTALLATION                                                                                                                                                                                 | EPD, DECLARE, C2C                               |
| CP3                              | CARPET TILE                        | MILLIKEN                      | COLLECTION: LOW COUNTRY. PATTERN: WATERWAY                                                                     | WAT196-13 INDIGO PLANT                                            | 9.85"X39.4"                                                            | 33% OFFSET ASHLAR INSTALLATION                                                                                                                                                                                 | EPD, DECLARE, C2C                               |
| EM1                              | ENTRY WALK OFF CARPET              | MILLIKEN                      | OBEX BAR TRANSITIONS RECESSED                                                                                  | DARK GREY                                                         | 10.87"X39.37"                                                          | COORDINATE WITH STRUCTURE                                                                                                                                                                                      | INDOOR AIR ADVANTAGE GOLD                       |
| EM2                              | ENTRY WALK OFF CARPET              | MILLIKEN                      | WALK OFF OBEX CARPET TILE                                                                                      | CUT FIZZ, DARK GREY                                               | 19.68X19.68                                                            | -                                                                                                                                                                                                              | INDOOR AIR ADVANTAGE GOLD                       |
| ES1                              | ELECTRIC STATIC FLOOR              | STATICWORX                    | AMERIWORX CLASSIC EDS SOLID VINYL TILE                                                                         | ADIRONACK RIDGE                                                   | 12X12                                                                  | COORDINATE GROUNDING FOR COPPER WIRE WITH ELECTRICAL                                                                                                                                                           | FLOORSORE, RECYCLED CONTENT                     |
| RT1                              | RESILIENT FLOORING                 | TARKETT                       | COLLECTION: COLOR WEAVE                                                                                        | THUNDER                                                           | 18X18                                                                  | GLUE DOWN                                                                                                                                                                                                      | EPD, FLOORSORE, CRADLE TO GATE                  |
| SC1                              | SEALED CONCRETE                    | SHERWIN WILLIAMS              | H&C CLARISHIELD WATER-BASED CONCRETE SEALER                                                                    | NATURAL LOOK                                                      | -                                                                      | -                                                                                                                                                                                                              | -                                               |
| TF1                              | TILE FLOOR                         | EMSER                         | MOOD                                                                                                           | RIVER GREY                                                        | 12X23                                                                  | TO BE INSTALLED WITH LATICRETE SPECTRALOCK EPOXY GROUT COLOR78 STERLING SILVER. TO BE USED WITH UNCOUPLING MEMBRANE AND EXPANSION JOINTS AS RECOMMENDED                                                        | HPD, RED LIST FREE                              |
| TF2                              | TILE FLOOR                         | FLORIDA TILE                  | CANAL STREET COLLECTION                                                                                        | BLACK BAYOU                                                       | 24X48                                                                  | TO BE INSTALLED WITH LATICRETE SPECTRALOCK EPOXY GROUT COLOR78 STERLING SILVER. TO BE USED WITH UNCOUPLING MEMBRANE AND EXPANSION JOINTS AS RECOMMENDED                                                        | EPD, HPD, GREENGUARD                            |
| MILLWORK                         |                                    |                               |                                                                                                                |                                                                   |                                                                        |                                                                                                                                                                                                                |                                                 |
| FB1                              | FABRIC UPHOLSTERY                  | ANZEA                         | KAPOW COLLECTION                                                                                               | SLURP                                                             | -                                                                      | SEE ELEVATIONS AND RENDERING FOR DESIGN INTENT                                                                                                                                                                 | HPD, REDLIST FREE                               |
| FB2                              | FABRIC UPHOLSTERY                  | LUUM                          | SCALE FACTOR 4088                                                                                              | BASIS 4088-01                                                     | -                                                                      | SEE ELEVATIONS AND RENDERING FOR DESIGN INTENT                                                                                                                                                                 | HEAVY METAL FREE, RECYCLED CONTENT              |
| HD1                              | HARDWARE: MODULAR CASEWORK         | CAROLINA MILEMARKER           | GRIP CABINET PULL, ADA COMPLIANT                                                                               | SATIN NICKEL                                                      | -                                                                      | TO BE INSTALLED WITH MODULAR CASEWORK. CONTACT: Jared.B@cdcollective.com WITH CONTRACT DESIGN                                                                                                                  | HPD, REDLIST FREE                               |
| PL1                              | PLASTIC LAMINATE: CUSTOM MILLWORK  | WILSONART                     | HPL BLOND ECHO LINEARITY FINISH                                                                                | 7939K-18                                                          | -                                                                      | -                                                                                                                                                                                                              | HPD, INDOOR AIR ADVANTAGE GOLD, GREENGUARD GOLD |
| PL2                              | PLASTIC LAMINATE: MODULAR CASEWORK | CAROLINA-OFS                  | HPL LINEN (WOOD LOOK)                                                                                          | OFS STANDARD LAMINATE                                             | -                                                                      | -                                                                                                                                                                                                              | INDOOR AIR ADVANTAGE GOLD                       |
| PL3                              | PLASTIC LAMINATE: CUSTOM MILLWORK  | WILSONART                     | HPL LINEN (WHITE)                                                                                              | D427-60 MATTE FINISH                                              | -                                                                      | -                                                                                                                                                                                                              | HPD, INDOOR AIR ADVANTAGE GOLD, GREENGUARD GOLD |
| QZ1                              | QUARTZ SURFACE                     | EVERO QUARTZ BY BRADLEY       | GEO SERIES                                                                                                     | ANDORRA                                                           | -                                                                      | RESTROOM TROUGH SINK. SEE PLUMBING FOR DETAILS                                                                                                                                                                 | GREENGUARD GOLD                                 |
| SS1                              | SOLID SURFACE: MODULAR CASEWORK    | CAROLINA-OFS                  | LIVINGSTONE SURFACES, SNOWFALL                                                                                 | L213                                                              | -                                                                      | MITERED CORNERS, EASED EDGES, CONTACT: Jared.B@cdcollective.com WITH CONTRACT DESIGN                                                                                                                           | HPD, GREENGUARD                                 |
| MISC.                            |                                    |                               |                                                                                                                |                                                                   |                                                                        |                                                                                                                                                                                                                |                                                 |
| AC2                              | ACOUSTIC ARCHITECTURAL ELEMENT     | TURF DESIGNS                  | ARCHITECTURAL ELEMENT: PATTERN FRACTAL, CLASS A                                                                | SHELL HOUSING COLOR: DAMASCAS 09, INSERTS: LIGHT 04 GREY          | MODULAR CLOUD, 36"x36"                                                 | SEE RCP, DETAILS, AND ELEVATIONS FOR DESIGN INTENT. COORDINATE WITH MECHANICAL, ELECTRICAL AND STRUCTURAL SYSTEMS. INSTALLER TO USE RECOMMENDED THREADED ROD CONNECTION. CONTACT: jordan@absolute-resource.com | HPD, DECLARE                                    |
| AP1                              | ACOUSTIC PRODUCTS                  | KIREI                         | SOLID WALL PANEL                                                                                               | 442 GREY                                                          | SHEET SIZE 9'X4'X1/2"THICK                                             | Z-CLIP MOUNT. SEE ELEVATIONS FOR DESIGN INTENT AND SIZING                                                                                                                                                      | HPD                                             |
| AP1.1                            | ACOUSTIC PRODUCTS                  | KIREI                         | SOLID WALL PANEL                                                                                               | 660 CORONET                                                       | SHEET SIZE 9'X4'X1/2"THICK                                             | Z-CLIP MOUNT. SEE ELEVATIONS FOR DESIGN INTENT AND SIZING                                                                                                                                                      | HPD                                             |
| AP2                              | ACOUSTIC PRODUCTS                  | MOMENTUM TEXTILES             | NUFELT MANCHESTER ACOUSTIC WALLCOVERING. PATTERN TO RUN VERTICAL, MATCH SEAMS.                                 | WISHFUL THINKING                                                  | 0.12" THICK X 63" WIDE ROLL                                            | ADHESIVE MOUNT. PROVIDE METAL TRANSITION ON ALL EXPOSED EDGES.GC TO PROVIDE SHOP DRAWINGS FOR FINAL APPROVAL                                                                                                   | HPD, GREENGUARD, RECYCLED CONTENT               |
| AP3                              | ACOUSTIC PRODUCTS                  | KIREI                         | GROOVY 3.0 PANELS                                                                                              | NAVY 365                                                          | SHEET SIZE: 110 X 44 NOOKS. TO BE USED WITH TRANSITION EDGE #LVT908BRZ | SEE ELEVATIONS AND DETAILS FOR DESIGN INTENT. COORDINATE FITTING WITH ELECTRICAL AND FIRE PROTECTION                                                                                                           | EPD, HPD, DECLARE, RECYCLED CONTENT             |
| AP4                              | ACOUSTIC PRODUCTS                  | ACOUFELT                      | FRACTURE TWO-TONE: OPTICS PANEL                                                                                | PANEL COLOR: MARINE, REVEAL COLOR: POPCORN                        | SEE ELEVATIONS                                                         | SEE ELEVATIONS AND DETAILS FOR DESIGN INTENT. COORDINATE FITTING WITH ELECTRICAL AND FIRE PROTECTION                                                                                                           | REDLIST FREE, DECLARE                           |
| APA.1                            | ACOUSTIC PRODUCTS                  | ACOUFELT                      | FRACTURE TWO-TONE: OPTICS PANEL                                                                                | PANEL COLOR: GREY 442, REVEAL COLOR: 447 SLATE                    | SEE ELEVATIONS                                                         | SEE ELEVATIONS AND DETAILS FOR DESIGN INTENT. COORDINATE FITTING WITH ELECTRICAL AND FIRE PROTECTION                                                                                                           | REDLIST FREE, DECLARE                           |
| CC1                              | CUBICLE CURTAIN                    | KNOLL                         | FABRIC PATTERN SIGNAL, MESH: WHITE, ACCESSORIES AND TRACK PROVIDED BY GC                                       | FABRIC: COASTLINE, MESH: WHITE, GROMMETS:WHITE OR CLEAR ANNODIZED | SEE ELEVATIONS AND RENDERING FOR DESIGN INTENT                         | OMBRE STRIPES TO RUN HORIZONTAL. GC TO PROVIDE SHOP DRAWINGS FOR FINAL APPROVAL. SEE RCP AND DETAILS FOR HANGING STRUCTURE                                                                                     | FREE OF INTENTIONALLY ADDED PFAS                |
| LK1                              | LOCKERS                            | CAROLINA MILEMARKER           | 2 TIER STORAGE LOCKER. BATTERY OPERATED LOCKS. PULL: RECESSED. INCLUDE 2 PRONG COAT HOOKS                      | HPL LINEN (WOOD LOOK). PULL: SATIN NICKEL                         | SEE ELEVATIONS                                                         | -                                                                                                                                                                                                              | INDOOR AIR ADVANTAGE GOLD                       |
| LK1.1                            | LOCKERS                            | CAROLINA MILEMARKER           | OPEN CUBBIES                                                                                                   | HPL LINEN (WOOD LOOK). PULL: SATIN NICKEL                         | SEE ELEVATIONS                                                         | -                                                                                                                                                                                                              | INDOOR AIR ADVANTAGE GOLD                       |
| WF1                              | PRIVACY WINDOW FILM                | TAKEFORM                      | DUAL FADE FROSTED CUSTOM PATTERN                                                                               | FROSTED                                                           | 60 INCH BAND TO START 2FT FROM BOTTOM OF DOOR FRAME                    | GC TO PROVIDE SHOP DRAWINGS FOR APPROVAL. GC TO PROVIDE MOCKUP PRIOR TO ORDERING FOR OWNER APPROVAL                                                                                                            | -                                               |
| WH1                              | WHITEBOARD                         | CLARUS                        | FLOAT : BACKPAINTED MAGNETIC GLASSBOARD                                                                        | WHITE                                                             | SEE ELEVATIONS                                                         | INCLUDE MARKERS, HANGERS, AND ALL ACCESSORIES                                                                                                                                                                  | EPD, DECLARE                                    |
| WS1                              | WINDOW SHADES                      | LUTRON                        | MOTORIZED ROLLER SHADES: CONTRACT ROLLER QS WIRELESS                                                           | FASCIA: TBD, FABRIC: 1% OPEN WEAVE, COLOR: TBD                    | FIELD VERIFY ON SITE                                                   | COORDINATE WITH ELECTRICAL                                                                                                                                                                                     | -                                               |
| WS2                              | WINDOW SHADES                      | LUTRON                        | MANUAL ROLLER SHADES: CONTRACT ROLLER MANUAL                                                                   | FASCIA: TBD, FABRIC: 1% OPEN WEAVE, COLOR: TBD                    | FIELD VERIFY ON SITE                                                   | -                                                                                                                                                                                                              | -                                               |
| WS3                              | WINDOW SHADES                      | LUTRON                        | MANUAL DUAL ROLLER SHADE: CONTRACT ROLLER MANUAL                                                               | FASCIA: TBD, FABRIC: 1% OPEN WEAVE, COLOR: TBD                    | FIELD VERIFY ON SITE                                                   | -                                                                                                                                                                                                              | -                                               |
| TRANSITIONS                      |                                    |                               |                                                                                                                |                                                                   |                                                                        |                                                                                                                                                                                                                |                                                 |
| TR1                              | TRANSITION PROFILE                 | SCHLUTER SYSTEMS              | CARPET TO TILE: SCHIENE                                                                                        | STAINLESS STEEL                                                   | GC TO CONFIRM SIZES WITH MATERIAL THICKNESS                            | SEE ARCHITECTURAL DETAIL.                                                                                                                                                                                      | RECYCLED CONTENT, NON-EMITTING SOURCE OF VOCs   |
| TR2                              | TRANSITION PROFILE                 | FUTURA TRANSITIONS            | CARPET TO RESILIENT: CARPET TO LVT PROFILE                                                                     | ETCHED ALUMINUM                                                   | GC TO CONFIRM SIZES WITH MATERIAL THICKNESS                            | SEE ARCHITECTURAL DETAIL.                                                                                                                                                                                      | REACH / ROHS COMPLIANT                          |
| TR3                              | TRANSITION PROFILE                 | FUTURA TRANSITIONS            | CARPET TO CONCRETE: DELUXE BINDER BAR                                                                          | ETCHED ALUMINUM                                                   | GC TO CONFIRM SIZES WITH MATERIAL THICKNESS                            | SEE ARCHITECTURAL DETAIL.                                                                                                                                                                                      | REACH / ROHS COMPLIANT                          |
| TR4                              | TRANSITION PROFILE                 | SCHLUTER SYSTEMS              | RESILIENT TO TILE: RENO-U                                                                                      | STAINLESS STEEL                                                   | GC TO CONFIRM SIZES WITH MATERIAL THICKNESS                            | SEE ARCHITECTURAL DETAIL.                                                                                                                                                                                      | RECYCLED CONTENT, NON-EMITTING SOURCE OF VOCs   |
| TR5                              | TRANSITION PROFILE                 | FUTURA TRANSITIONS            | RESILIENT TO CONCRETE: COVING CAP                                                                              | ETCHED ALUMINUM                                                   | GC TO CONFIRM SIZES WITH MATERIAL THICKNESS                            | SEE ARCHITECTURAL DETAIL.                                                                                                                                                                                      | REACH / ROHS COMPLIANT                          |
| TR6                              | TRANSITION PROFILE                 | FUTURA TRANSITIONS            | TILE TO CONCRETE: CERAMIC REDUCER EDGETEK U SHAPED                                                             | ETCHED ALUMINUM                                                   | GC TO CONFIRM SIZES WITH MATERIAL THICKNESS                            | SEE ARCHITECTURAL DETAIL.                                                                                                                                                                                      | REACH / ROHS COMPLIANT                          |
| TR7                              | TRANSITION PROFILE                 | FUTURA TRANSITIONS            | FELT METAL EDGE FOR AP3                                                                                        | #LVT 908 EBLK                                                     | -                                                                      | -                                                                                                                                                                                                              | REACH / ROHS COMPLIANT                          |
| TR8                              | TRANSITION PROFILE                 | FUTURA TRANSITIONS            | FELT METAL EDGE FOR AP2, BEVEL CAP                                                                             | 4MM, #LVT 906 EBLK                                                | -                                                                      | -                                                                                                                                                                                                              | REACH / ROHS COMPLIANT                          |
| TR9                              | TRANSITION PROFILE                 | TBD                           | WALL PROTECTION EDGE -LABS                                                                                     | STAINLESS STEEL                                                   | -                                                                      | -                                                                                                                                                                                                              | -                                               |
| TR10                             | TRANSITION PROFILE                 | SCHLUTER SYSTEMS              | WALL TILE EDGE + CORNERS: FINEC-SQ - ALL EXPOSED EDGES, OUTSIDE CORNERS                                        | STAINLESS STEEL                                                   | GC TO CONFIRM SIZES WITH MATERIAL THICKNESS                            | -                                                                                                                                                                                                              | RECYCLED CONTENT, NON-EMITTING SOURCE OF VOCs   |
| TR11                             | TRANSITION PROFILE                 | FUTURA TRANSITIONS            | VENEER PLYWOOD EDGE - NOOKS: COVING CAP 1/8" OR 3/32"                                                          | EBLK                                                              | GC TO CONFIRM SIZES WITH MATERIAL THICKNESS                            | -                                                                                                                                                                                                              | REACH / ROHS COMPLIANT                          |
| TR12                             | TRANSITION PROFILE                 | VARIES                        | STAIR TREAD TRANSITION                                                                                         | STAINLESS STEEL                                                   | GC TO CONFIRM SIZES WITH MATERIAL THICKNESS                            | -                                                                                                                                                                                                              | -                                               |
| WALL                             |                                    |                               |                                                                                                                |                                                                   |                                                                        |                                                                                                                                                                                                                |                                                 |
| EP1                              | EPOXY PAINT                        | SHERWIN WILLIAMS              | PRO-INDUSTRIAL WATERBASED CATALYZED EPOXY                                                                      | SW7566 WESTHIGHLAND WHITE                                         | CEILINGS: FLAT FINISH, WALLS EG-SHEL FINISH                            | GC TO PROVIDE LOW/NO VOC PAINT                                                                                                                                                                                 | LOW/NO VOC                                      |
| EP2                              | PAINT                              | SHERWIN WILLIAMS              | PRO-INDUSTRIAL WATERBASED CATALYZED EPOXY                                                                      | SW7609 GEORGIAN REVIVAL BLUE                                      | CEILINGS: FLAT FINISH, WALLS EG-SHEL FINISH                            | GC TO PROVIDE LOW/NO VOC PAINT                                                                                                                                                                                 | LOW/NO VOC                                      |
| P1                               | PAINT                              | SHERWIN WILLIAMS              | ZERO VOC HARMONY INTERIOR LATEX PAINT                                                                          | SW7566 WESTHIGHLAND WHITE                                         | CEILINGS: FLAT FINISH, WALLS EG-SHEL FINISH                            | GC TO PROVIDE LOW/NO VOC PAINT                                                                                                                                                                                 | LOW/NO VOC                                      |
| P2                               | PAINT                              | SHERWIN WILLIAMS              | ZERO VOC HARMONY INTERIOR LATEX PAINT                                                                          | SW7609 GEORGIAN REVIVAL BLUE                                      | CEILINGS: FLAT FINISH, WALLS EG-SHEL FINISH                            | GC TO PROVIDE LOW/NO VOC PAINT                                                                                                                                                                                 | LOW/NO VOC                                      |
| P3                               | PAINT                              | SHERWIN WILLIAMS              | ZERO VOC HARMONY INTERIOR LATEX PAINT                                                                          | SW7506 VAST SKY                                                   | CEILINGS: FLAT FINISH, WALLS EG-SHEL FINISH                            | GC TO PROVIDE LOW/NO VOC PAINT                                                                                                                                                                                 | LOW/NO VOC                                      |
| P4                               | PAINT                              | SHERWIN WILLIAMS              | ZERO VOC HARMONY INTERIOR LATEX PAINT                                                                          | SW7072 ONLINE                                                     | CEILINGS: FLAT FINISH, WALLS EG-SHEL FINISH                            | GC TO PROVIDE LOW/NO VOC PAINT                                                                                                                                                                                 | LOW/NO VOC                                      |
| P5                               | PAINT                              | SHERWIN WILLIAMS              | ZERO VOC HARMONY INTERIOR LATEX PAINT                                                                          | SW7075 WEB GRAY                                                   | CEILINGS: FLAT FINISH, WALLS EG-SHEL FINISH                            | GC TO PROVIDE LOW/NO VOC PAINT                                                                                                                                                                                 | LOW/NO VOC                                      |
| SP1                              | SPECIALTY PAINT/COATING            | GC/ SIGNAGE VENDOR TO PROVIDE | CUSTOM GRAPHIC ON TYPE III TERRALON VINYL                                                                      | CUSTOM IMAGERY                                                    | SEE ELEVATIONS AND RENDERING FOR DESIGN INTENT                         | WALLS RECEIVING GRAPHIC TO HAVE A LEVEL 5 GYP FINISH, PROVIDE MOCKUP TO DESIGNER FOR APPROVAL. GC/CT TO PROVIDE DESIGN INTENT                                                                                  | -                                               |
| TW1                              | TILE WALL                          | EMSER                         | COUNCIL                                                                                                        | GRAY                                                              | 12X24                                                                  | TO BE INSTALLED WITH LATICRETE SPECTRALOCK EPOXY GROUT COLOR78 STERLING SILVER                                                                                                                                 | HPD, RED LIST FREE                              |
| TW2                              | TILE WALL                          | GARDEN STATE TILE             | OUTFIT, GLOSSY TILE                                                                                            | STORM                                                             | 3X12                                                                   | TO BE INSTALLED WITH LATICRETE SPECTRALOCK EPOXY GROUT COLOR 78 STERLING SILVER                                                                                                                                | EPD                                             |
| TW3                              | TILE WALL                          | GARDEN STATE TILE             | OUTFIT, GLOSSY TILE                                                                                            | BRIGHT WHITE                                                      | 3X12                                                                   | TO BE INSTALLED WITH LATICRETE SPECTRALOCK EPOXY GROUT COLOR78 STERLING SILVER                                                                                                                                 | EPD                                             |
| WC1                              | WALLCOVERING                       | P3TEC                         | STELLAR                                                                                                        | P3T-60128 WHITE OUT                                               | 4' ROLL                                                                | INSTALL ABOVE WALL BASE. TO BE USED IN CONJUNCTION WITH MANUFACTURERS STANDARD TOP CAP AND MATCHING CORNER GUARDS. ARCHITECT TO SELECT COLOR FROM STANDARD RANGE                                               | EPD,HPD                                         |
| WDW1                             | WOOD WALL                          | GC TO PROVIDE                 | RIFT SAWN WHITE OAK, POLYURETHANE FINISH, TO MATCH ARCHITECTS SAMPLE IN SPECIEIS, STAIN, GRAINING, AND TEXTURE | GC TO PROVIDE A RANGE OF SAMPLES                                  | -                                                                      | SEE DETAILS, ELEVATIONS, AND SECTIONS FOR DESIGN INTENT                                                                                                                                                        | -                                               |
| WALL PROTECTION                  |                                    |                               |                                                                                                                |                                                                   |                                                                        |                                                                                                                                                                                                                |                                                 |
| CG1                              | CORNER GUARD                       | C.S. ACROVYN                  | SSM-20                                                                                                         | WHITE, SUEDE FINISH                                               | 2" WINGS, FULL HEIGHT                                                  | CG1 TO START AT TOP OF BASE.                                                                                                                                                                                   | EPD                                             |
| CH1                              | CHAIR RAIL                         | C.S. ACROVYN                  | SCR-40 SURFACE MOUNTED                                                                                         | WHITE, SUEDE FINISH                                               | 4" HIGH                                                                | SEE ELEVATIONS FOR DESIGN INTENT AND SIZING                                                                                                                                                                    | EPD                                             |
| FRP1                             | FIBERGLASS REINFORCED PANEL        | MARLITE                       | STANDARD FRP                                                                                                   | WHITE, PEBBLE FINISH                                              | 4'X8'                                                                  | FRP TO START AT TOP OF BASE                                                                                                                                                                                    | GREENGUARD GOLD                                 |
| WP1                              | WALL PROTECTION                    | CONSTRUCTION SPECIALTIES      | ACROVYN WALL PROTECTION RIGID SHEET                                                                            | WHITE, SUEDE FINISH                                               | 4'X8'                                                                  | INSTALL ABOVE FINISHED FLOOR; WALL BASE TO BE INSTALLED ON TOP OF WP# PANEL                                                                                                                                    | EPD, CRADLE TO CRADLE                           |

1  
A503  
12" = 1'-0"

INTERIOR DETAIL - TR1 CARPET TO FLOOR TILE

2  
A503  
12" = 1'-0"

INTERIOR DETAIL - TR2 CARPET TO RESILIENT

3  
A503  
12" = 1'-0"

INTERIOR DETAIL - TR3 CARPET TO CONCRETE

4  
A503  
12" = 1'-0"

INTERIOR DETAIL - TR4 RESILIENT TO FLOOR TILE

5  
A503  
12" = 1'-0"

INTERIOR DETAIL - TR5 RESILIENT TO CONCRETE

6  
A503  
12" = 1'-0"

INTERIOR DETAIL - TR6 FLOOR TILE TO CONCRETE

7  
A503  
12" = 1'-0"

INTERIOR DETAIL - TILE COVE BASE

revised see attached email

8  
A503  
6" = 1'-0"

INTERIOR DETAIL - TILE WALL BASE

MONTANA STATE UNIVERSITY

MONTANA DEPARTMENT OF ADMINISTRATION  
ARCHITECTURE & ENGINEERING

MARK & ROBYN JONES COLLEGE  
OF NURSING - KALISPELL  
MONTANA STATE UNIVERSITY

Cushing Terrell  
co ARCHITECTS

|              |             |      |
|--------------|-------------|------|
| DRAWN BY:    | LD          |      |
| REVIEWED BY: | MH          |      |
| REV.         | DESCRIPTION | DATE |
|              |             |      |
|              |             |      |
|              |             |      |
|              |             |      |

LICENSED ARCHITECT  
JAMES R. HARDER  
No. 5642  
BILLINGS, MT  
STATE OF MONTANA

PPA#21-0168

A/E#:2022-02-09-04

SHEET TITLE  
INTERIOR MATERIALS  
SCHEDULE AND  
DETAILS

SHEET  
A503

DATE  
4.17.2024





MARK & ROBYN JONES COLLEGE  
OF NURSING - MISSOULA  
MONTANA STATE UNIVERSITY

Cushing  
Terrell  
co ARCHITECTS

|              |             |          |
|--------------|-------------|----------|
| DRAWN BY:    |             | SG, TS   |
| REVIEWED BY: |             | SP       |
| REV.         | DESCRIPTION | DATE     |
| 2            | PR-02       | 08.16.24 |



PPA#21-0171  
A/E#: 2022-02-09-05

SHEET TITLE  
SECOND FLOOR PLAN

SHEET  
A102

DATE  
05.15.2024

PLAN LEGEND


- W# — ASSEMBLY TYPE (SEE ASSEMBLIES SHEET)  
NAME — ASSEMBLY MODIFIER, PER TYPE  
101 — ROOM NAME AND NUMBER  
X — KEYNOTE  
SIM — DIRECTION OF VIEW, IF APPLICABLE  
1 — DRAWING NUMBER  
X000 — SHEET WHERE DRAWN  
101 — DOOR NUMBER (SEE SHEET A601)  
— DIMENSION TO FACE OF FRAMING  
— DIMENSION TO GRID LINE  
— DIMENSION TO CENTER LINE

GENERAL PLAN NOTES


- A. SEE A500 SHEETS FOR ALL FINISH REQUIREMENTS.  
B. SEE A600 SHEETS FOR WINDOW AND DOOR SCHEDULES  
C. SEE A700 SHEETS FOR INTERIOR ELEVATIONS  
D. COORDINATE WITH BUILDING SECTIONS AND STRUCTURAL DRAWINGS FOR FINISH FLOOR ELEVATIONS  
E. SEE G100 SHEETS REGARDING BUILDING CODE REQUIREMENTS.  
F. SEE SHEET A002 FOR TYPICAL EXTERIOR AND INTERIOR WALL TYPE ASSEMBLIES  
G. SEE A900 SHEETS FOR REFLECTED CEILING PLANS AND DETAILS  
H. PROVIDE BLOCKING IN WALL FOR ALL MOUNTED EQUIPMENT, MILLWORK, AND HARDWARE  
I. FIELD VERIFY ALL CASEWORK AND BUILT IN COMPONENTS PRIOR TO FABRICATION  
J. COORDINATE ALL PLUMBING FIXTURES LOCATIONS WITH PLUMBING DRAWINGS  
K. DIMENSIONS OF EXTERIOR WALL ARE TO FACE OF STUD (UNLESS NOTED OTHERWISE)  
L. PROVIDE BLOCKING IN WALLS AS NEEDED FOR ALL WALL-MOUNTED EQUIPMENT, CASEWORK, AND ACCESSORIES.

# KEYNOTES

1. SOLID PANEL OPERABLE PARTITION WALL SYSTEM, SEE SPEC.  
2. DOOR TO BE RECESSED INTO ADJACENT WALLS, TYPICAL BOTH SIDES. SEE DETAIL A602  
3. MOP SINK. SEE PLUMBING.  
4. CUSTOM BUILT-IN SEAT & TABLE NOOK. SEE SHEET A803 FOR ENLARGED PLANS AND DETAILS.  
5. CANE DETECTION RAIL. SEE 1/A103  
6. ALIGN WALL WITH WINDOW OPENING PER 2/A103  
7. 24"x48" ACCESS PANEL. MOUNT FLUSH WITHIN WALL 6" ABOVE FINISH FLOOR. PAINT TO MATCH ADJACENT WALL.  
8. 24"x24" ACCESS PANEL. MOUNT FLUSH WITHIN WALL 5" TO CENTERLINE OF PANEL. PAINT TO MATCH ADJACENT WALL.  
9. WALK-OFF GRATE. SEE STRUCTURAL, LANDSCAPE, AND CIVIL.  
10. CROSS BRACING. TYPICAL. PAINT. SEE STRUCTURAL.  
11. DRINKING FOUNTAIN. SEE PLUMBING.  
12. ADA COMPLIANT, HEAVY DUTY TOWER PEDESTAL. BASIS OF DESIGN: INTERCOM ONLINE PD1054, 47 INCHES TALL. POWDERCOATED BLACK, ONE SINGLE GANG BOX CUTOUT FOR ADA BUTTON. COORDINATE WITH AUTOMATIC OPERATORS.  
13. CHANGING TABLE. PROVIDE BLOCKING.  
14. LOCKERS. SEE FINISH PLANS.  
15. KNOX BOX. SEE FIRE ALARM.  
16. FIRE DEPARTMENT CONNECTION. SEE FIRE PROTECTION.  
17. RECESSED FIRE EXTINGUISHER CABINET.  
18. METAL GAUDDRAIL. SEE A402 FOR DETAIL. SAME AS STAIR 1 GAUDDRAIL.  
19. ADA COMPLIANT, HEAVY DUTY TOWER PEDESTAL. BASIS OF DESIGN: INTERCOM ONLINE PD1054, 47 INCHES TALL. POWDERCOATED BLACK, TWO BOX CUTOUTS FOR ADA BUTTON AND CARD READER. COORDINATE WITH AUTOMATIC OPERATORS, ACCESS CONTROLS, AND ELECTRICAL.

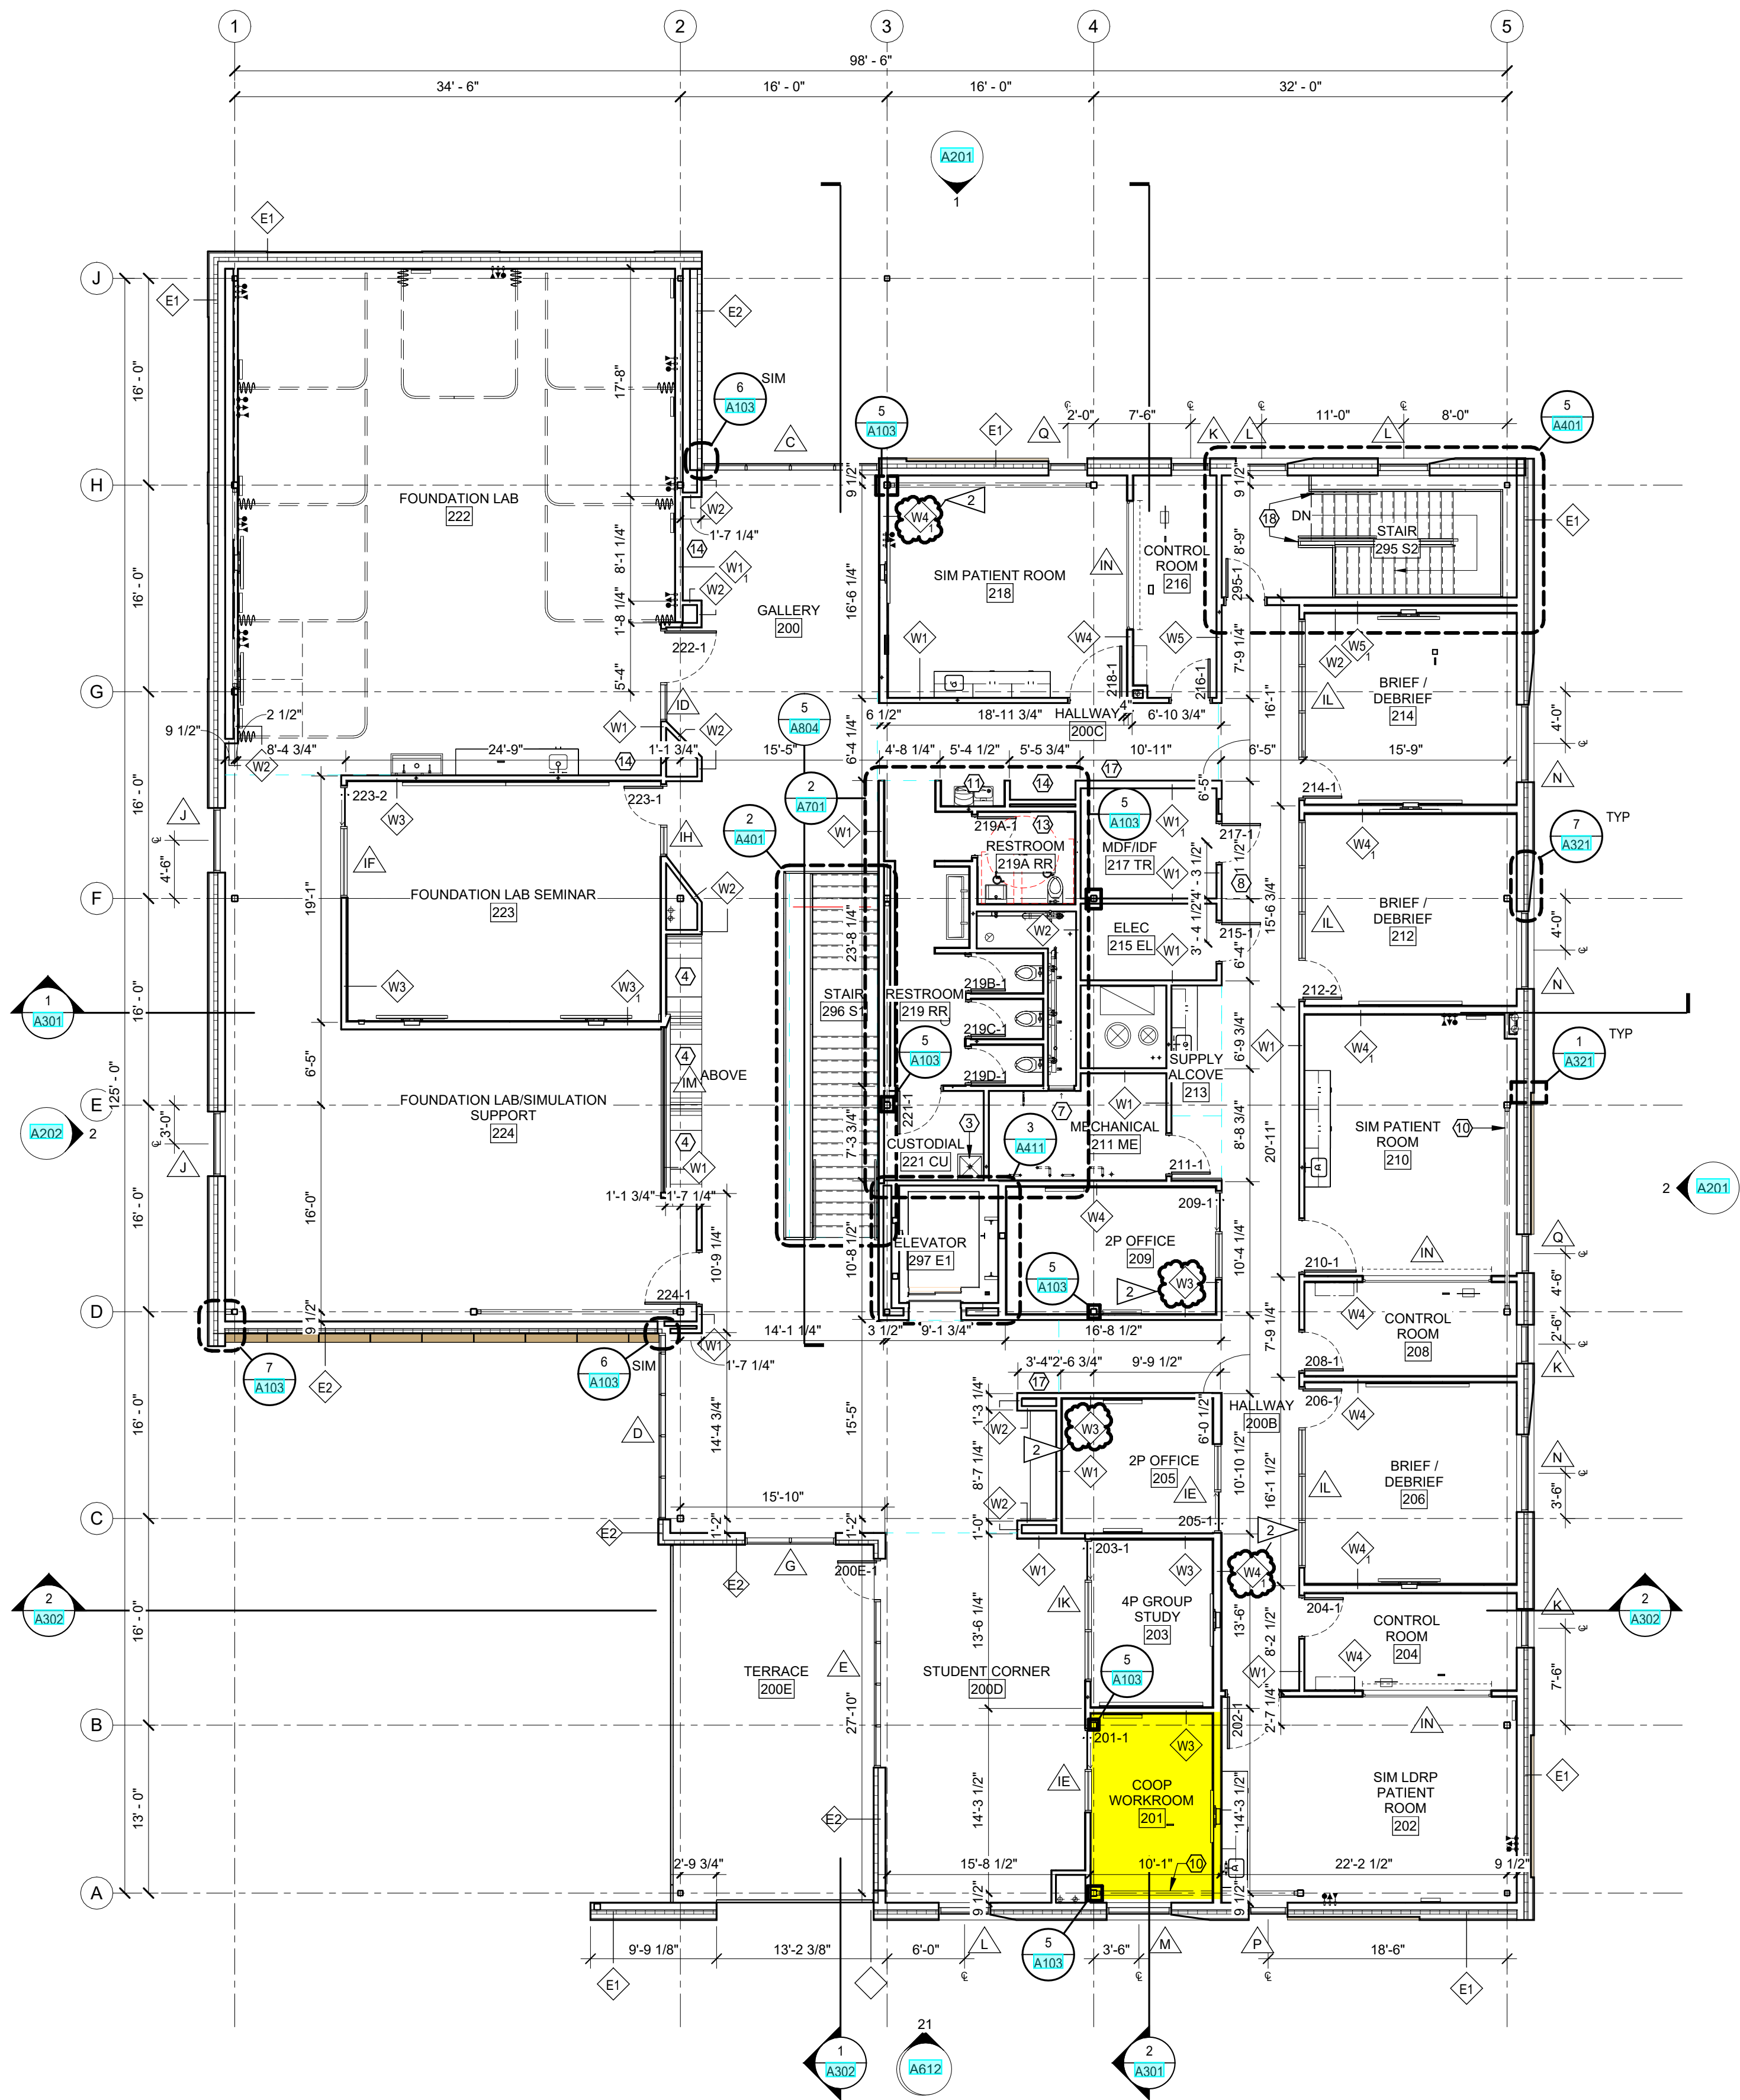



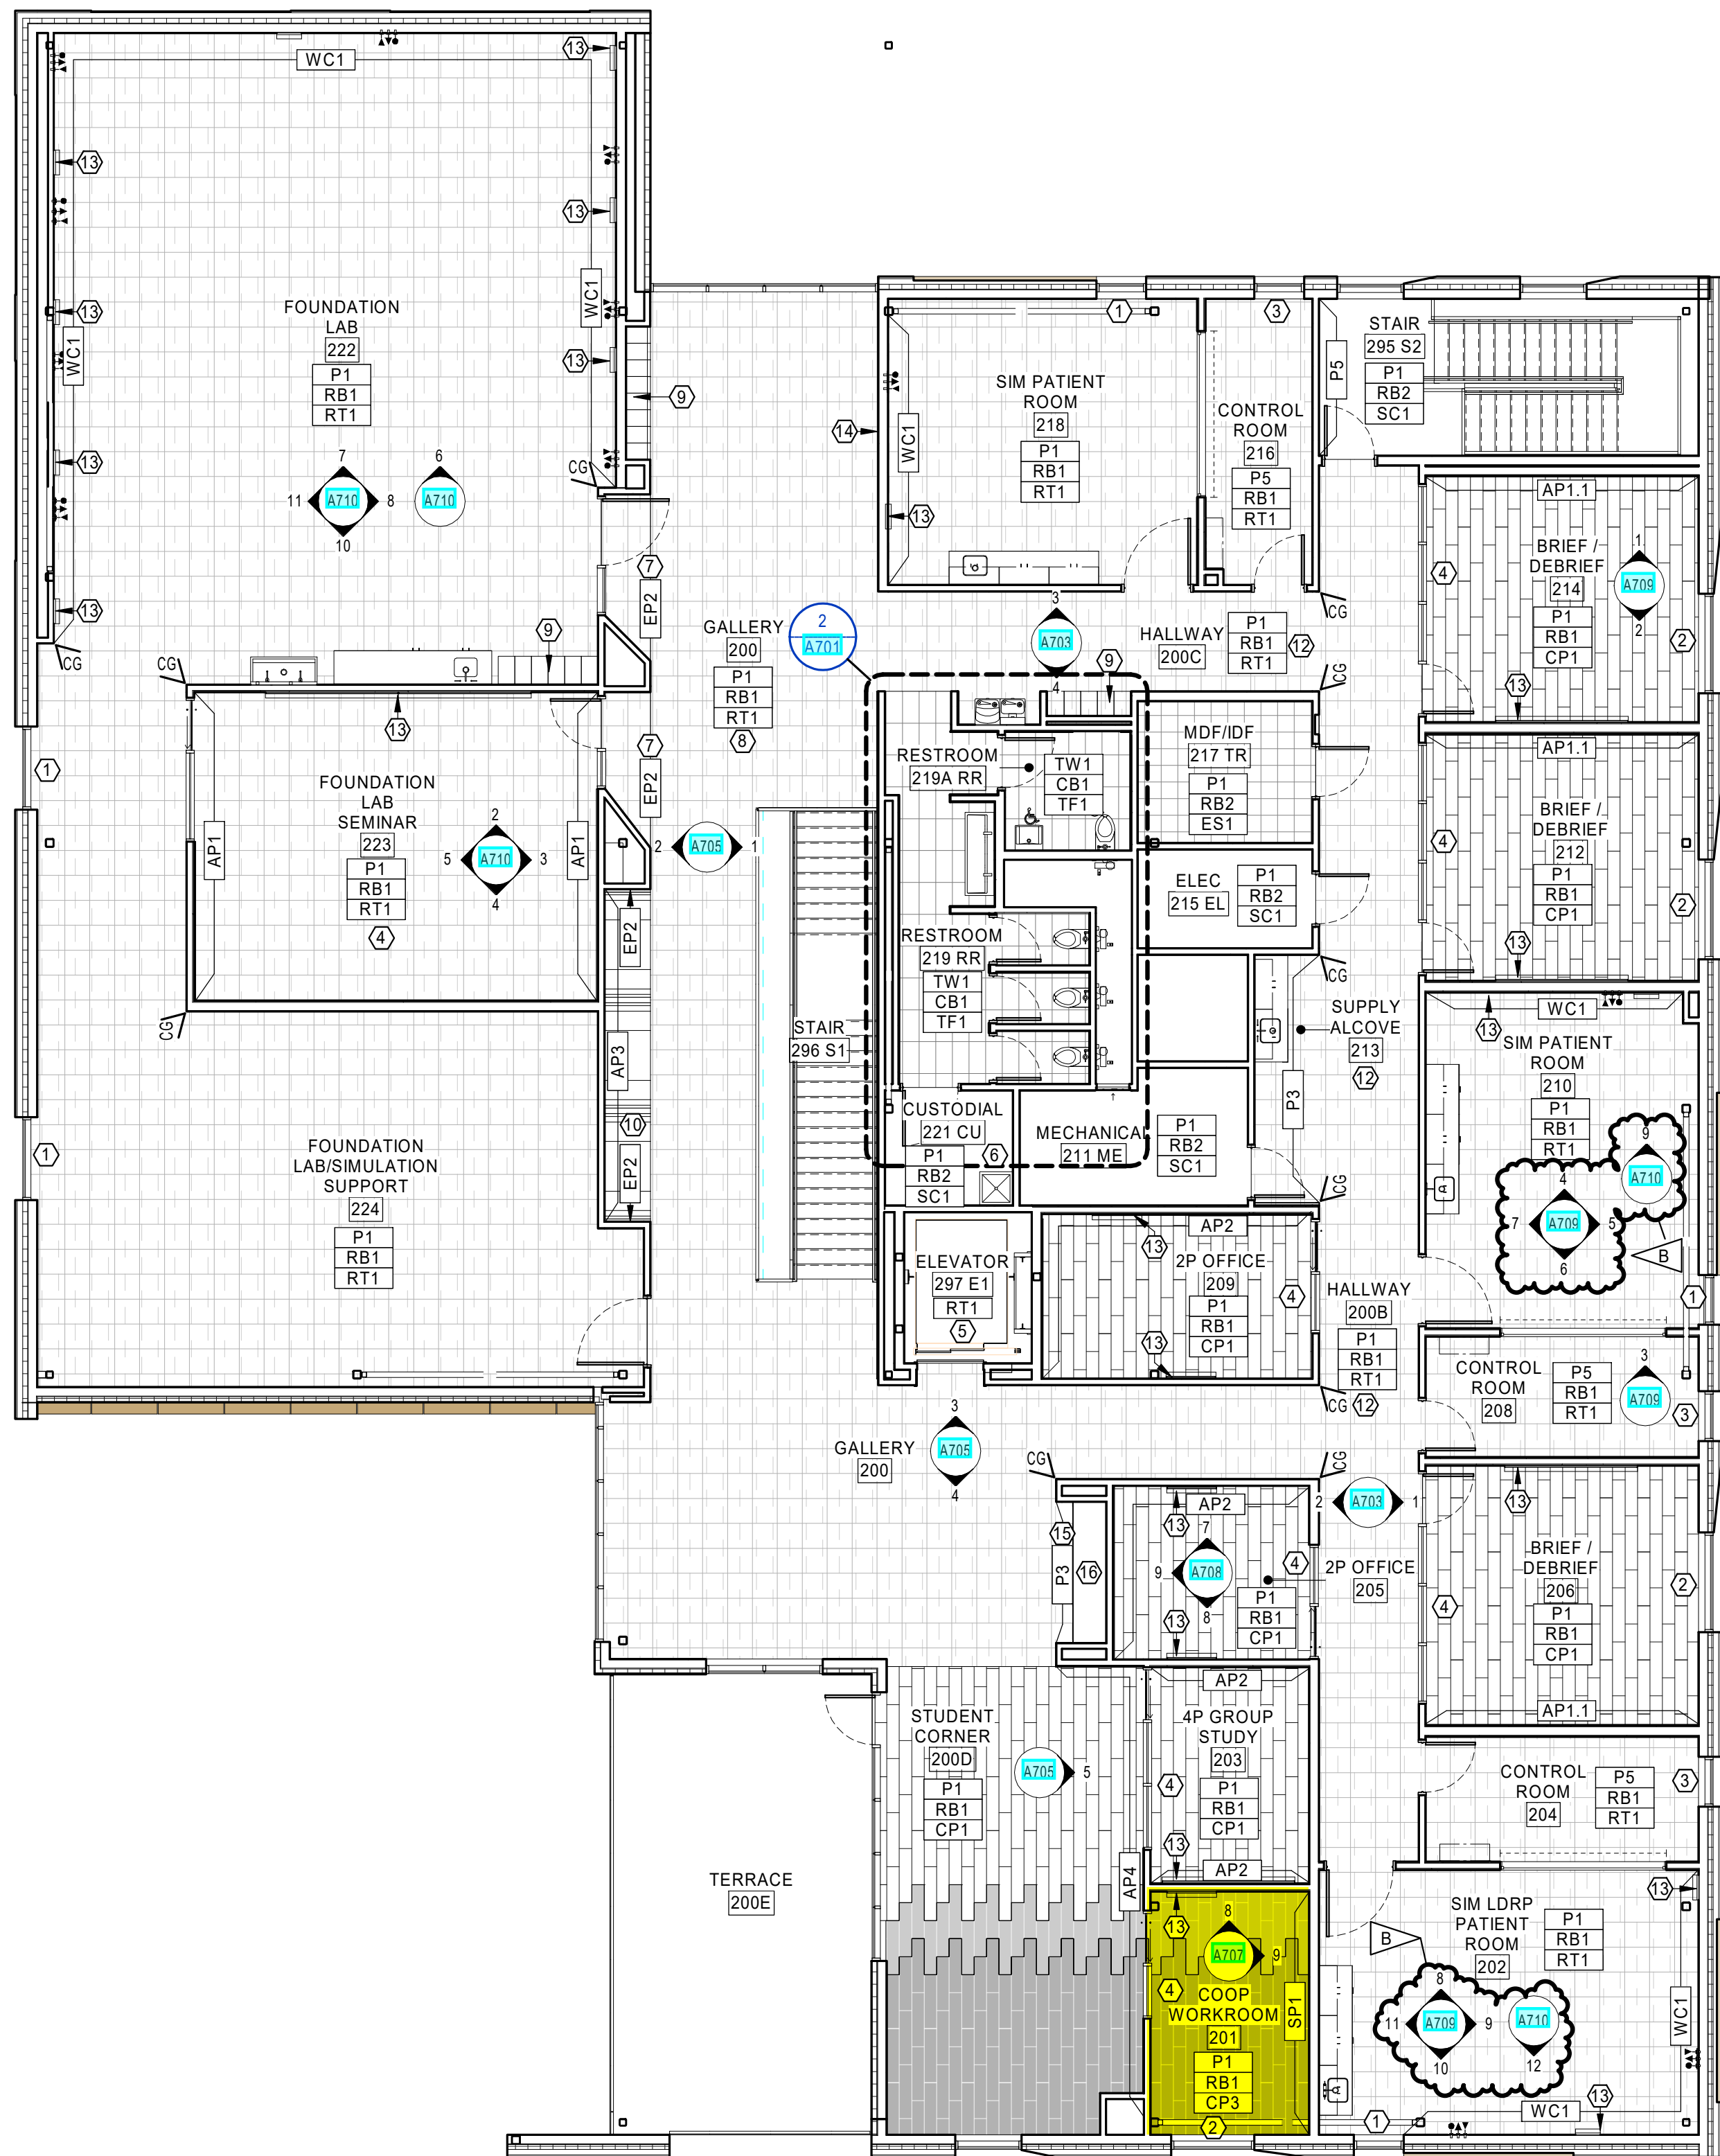

## FINISH PLAN LEGEND

|             |                                                              |
|-------------|--------------------------------------------------------------|
| NAME<br>101 | ROOM NAME AND NUMBER                                         |
| A8##        | # INTERIOR ELEVATION CALLOUT AND DIRECTION OF ELEVATION VIEW |
| XX###       | FINISH TAG                                                   |
| XX###       | EXTENT OF ACCENT PAINT OR WALL FINISHES                      |

FINISH TAGS DISPLAYED IN GROUPING ON FINISH PLAN REPRESENT MAJORITY ROOM FINISH SELECTIONS. ORDER OF GROUPING DEFINED IN EXAMPLE BELOW:

|       |                       |
|-------|-----------------------|
| XX### | MAJORITY WALL FINISH  |
| XX### | MAJORITY BASE FINISH  |
| XX### | MAJORITY FLOOR FINISH |

CG LOCATION AND TYPE OF CORNER GUARDS 'CG1'

|                    |                    |
|--------------------|--------------------|
| FLOOR FINISH 'CP1' | FLOOR FINISH 'RT1' |
| FLOOR FINISH 'CP2' | FLOOR FINISH 'SC1' |
| FLOOR FINISH 'CP3' | FLOOR FINISH 'TF1' |
| FLOOR FINISH 'EM1' | FLOOR FINISH 'TF2' |
| FLOOR FINISH 'EM2' |                    |
| FLOOR FINISH 'ES1' |                    |

## GENERAL FINISH NOTES

- VERIFY ALL CONDITIONS AND DIMENSIONS IN FIELD PRIOR TO FABRICATION.
- ALL PRODUCTS ARE TO BE INSTALLED PER MANUFACTURER'S INSTRUCTIONS, USING MANUFACTURER'S ADHESIVES, TOOLS, AND METHODS.
- REFER TO SPECIFICATIONS AND MATERIAL FINISH LIST FOR ALL FINISH MATERIAL PRODUCT INFORMATION.
- FOR INTERIOR ELEVATIONS AND ADDITIONAL FINISHES, RE: A700'S.
- FOR CEILING HEIGHTS AND ADDITIONAL FINISHES RE: A900'S.
- COORDINATE ALL OWNER FURNISHED EQUIPMENT, ACCESSORIES, AND FURNITURE WITH OWNER AND/OR OWNER'S VENDOR.
- ALL FLOOR TRANSITIONS ARE TO OCCUR DIRECTLY BENEATH DOORS OR CENTERED IN OPENING UNLESS OTHERWISE NOTED. TRANSITIONS ARE TO BE ADA COMPLIANT.
- REFER TO FINISH PLAN FOR LOCATION OF CORNER GUARDS. INSTALL AT TOP OF WALL BASE.
- ALL GYPSUM WALLS TO BE PAINTED 'P1' UNLESS OTHERWISE NOTED.
- ALL GYPSUM CEILINGS AND SOFFITS TO BE PAINTED 'P1' UNLESS OTHERWISE NOTED ON REFLECTED CEILING PLAN.
- ALL WALL BASE TO BE 'RB1' UNLESS OTHERWISE NOTED.
- ALL HOLLOW METAL FRAMES TO BE PAINTED BLACK IN SEMI-GLOSS FINISH, UNLESS OTHERWISE NOTED. SEE DOOR SCHEDULE FOR MORE INFORMATION.
- ALL METAL ACCESS DOORS, PANELS, COVER PLATES, VENTS, AND GRILLES TO BE PAINTED TO MATCH THE SURFACE IT IS LOCATED ON.
- ALL QUARTZ AND SOLID SURFACE COUNTERTOPS TO HAVE EASED EDGES. ADJACENT BACKSPLASH TO MATCH, UNLESS OTHERWISE NOTED.
- ALL WINDOW TREATMENTS ARE TO BE FIELD MEASURED, INSTALLED WITH ALL COMPONENTS, AND INSIDE MOUNTED, UNLESS OTHERWISE NOTED.
- ALL WALLS TO RECEIVE CUSTOM GRAPHIC TO HAVE A LEVEL 5 GYP FINISH.
- ALL LEARNING STUDIOS, LABS, CONFERENCE ROOMS, AND OFFICES TO RECEIVE 'WH1' WHITEBOARD. REFER TO MATERIAL FINISH LIST FOR PRODUCT SPECIFICATIONS AND ELEVATIONS FOR SIZING.
- FOR ALL FLOORING AND WALL TRANSITIONS REFER TO MATERIAL FINISH LIST FOR PRODUCT SPECIFICATIONS. GC IS RESPONSIBLE TO PROVIDE THE CORRECT SIZING FOR TRANSITIONS.
- SEE RCP FOR PAINTED DRYFALL SYSTEM AND ACOUSTIC SPRAY SYSTEM.
- PAINT ALL EXPOSED STRUCTURAL STEEL COLUMNS, CROSS BRACING, ETC. WITH 'P1' SEMI-GLOSS FINISH, UNLESS NOTED OTHERWISE.

## KEYNOTES


- MOTORIZED AND CONTROLLED ROLLER SHADES 'WS1' TO BE INSTALLED ON EXTERIOR WINDOWS IN THIS ROOM. REFER TO MATERIAL FINISH LIST FOR PRODUCT SPECIFICATIONS. COORDINATE POWER AND AUTOMATION WITH ELECTRICAL.
- MANUAL ROLLER SHADES 'WS2' ON EXTERIOR WINDOWS IN THIS ROOM. REFER TO MATERIAL FINISH LIST FOR PRODUCT SPECIFICATIONS.
- DUAL MANUAL ROLLER SHADES 'WS3' ON EXTERIOR WINDOWS IN THIS ROOM. REFER TO MATERIAL FINISH LIST FOR PRODUCT SPECIFICATIONS.
- INSTALL PRIVACY WINDOW FILM 'WF1' ON GLAZING IN THIS ROOM. REFER TO MATERIAL FINISH LIST FOR PRODUCT SPECIFICATIONS. REFER TO DOOR SCHEDULE FOR MOUNTING HEIGHTS.
- ELEVATOR CAB FINISHES TO BE SELECTED BY ARCHITECT FROM VENDORS FULL RANGE; INCLUDING WALL PANELS, HAND RAILS AND FLOORING.
- INSTALL 'FRP1' ON ALL WALLS IN THIS ROOM. 4FT HIGH TO START AT TOP OF BASE.
- PAINT ALL WALLS WITHIN ALCOVE 'EP2'. CEILING TO BE CLAD WITH 'WDW1'.
- SEE ISOMETRICS, ELEVATIONS, RENDERINGS FOR DESIGN AND MATERIAL INTENT.
- SEE MATERIAL FINISH LIST 'LK1' AND 'LK1.1' FOR LOCKER SPECIFICATION. VENDOR PROVIDED, VENDOR INSTALLED.
- CUSTOM BOOTH SEATING AND TABLES. SEE ELEVATIONS, RENDERINGS AND DETAILS FOR CONSTRUCTION AND DESIGN INTENT. REFER TO MATERIAL FINISH LIST FOR UPHOLSTERY.
- NOT USED.
- INSTALL 'WP1' ON ALL WALLS IN THIS ROOM. 4FT HIGH TO START AT TOP OF FINISHED FLOOR. INSTALL WALL BASE ON TOP OF WFP.
- WHITEBOARD 'WH1' LOCATED ON THIS WALL. REFER TO MATERIAL FINISH LIST FOR PRODUCT SPECIFICATIONS, SIZE AND LOCATION.
- LEVEL 5 WALL FINISH FOR FUTURE ART INSTALLATION.
- PAINT ALL WALLS WITHIN ALCOVE 'PS'.
- CUSTOM MILLWORK, SEE ELEVATION FOR DETAILS.



MARK & ROBYN JONES COLLEGE  
OF NURSING - MISSOULA  
MONTANA STATE UNIVERSITY

Cushing  
Terrell  
co ARCHITECTS

DRAWN BY: LD  
REVIEWED BY: MH  
REV. DESCRIPTION DATE  
B Addendum 2 24.06.20

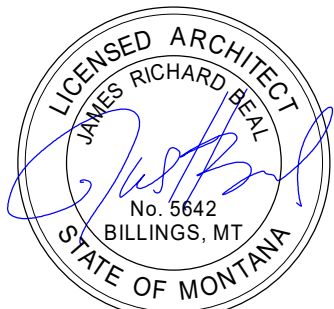

PPA#21-0171


A/E#: 2022-02-09-05

SHEET TITLE  
SECOND FLOOR  
FINISH PLAN


SHEET  
A502

DATE  
05.15.2024




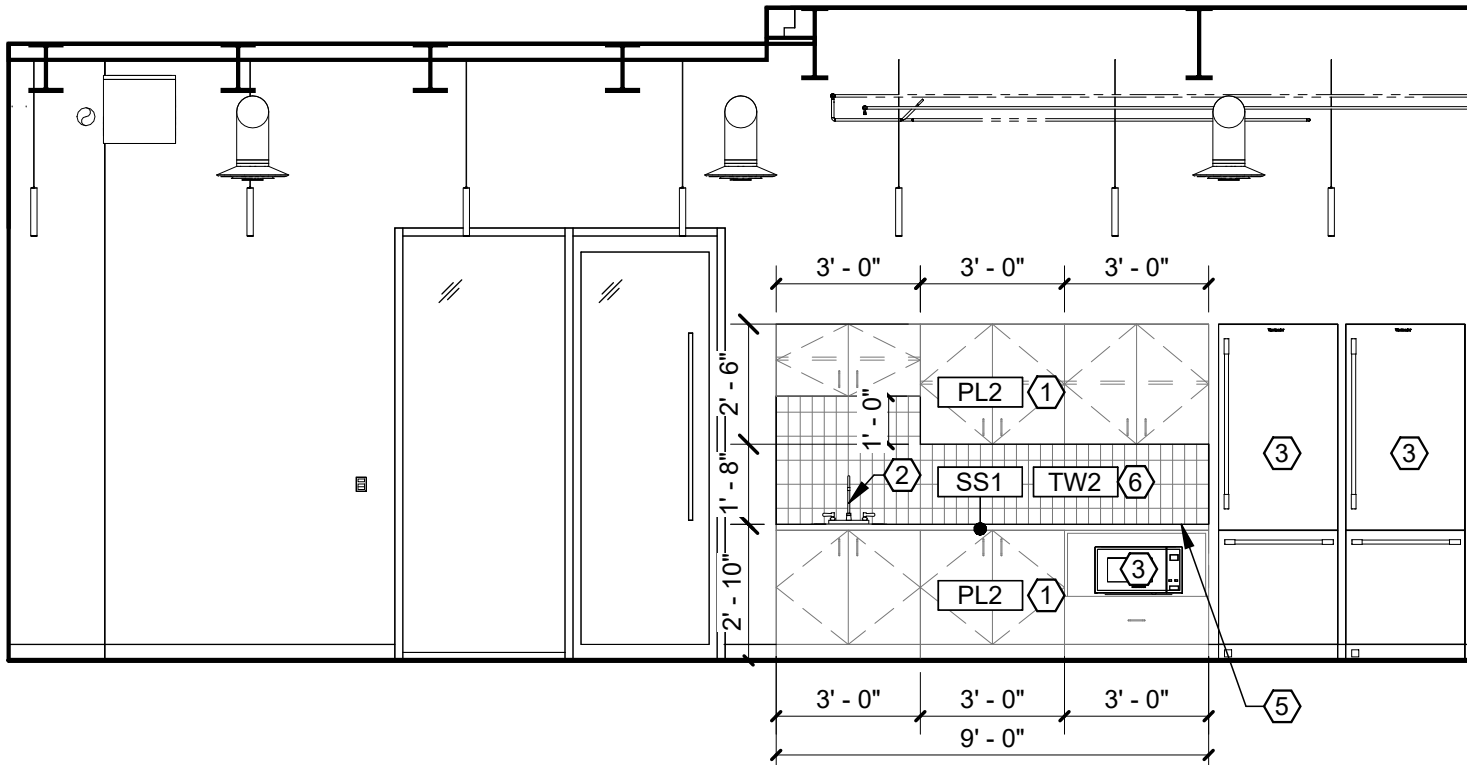


1 NOURISHMENT 101 CO- NORTH  
A707 1/4" = 1'-0"

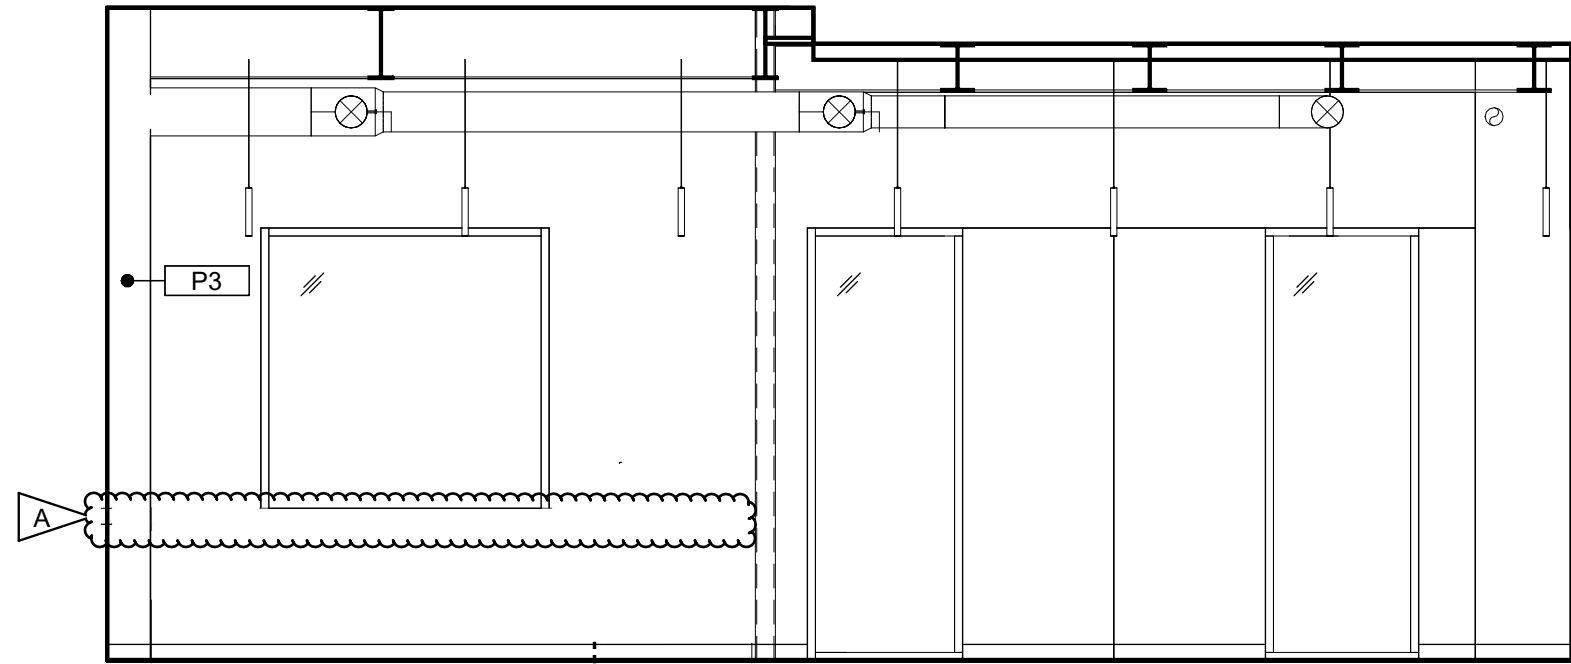


2 NOURISHMENT 101 CO - SOUTH  
A707 1/4" = 1'-0"

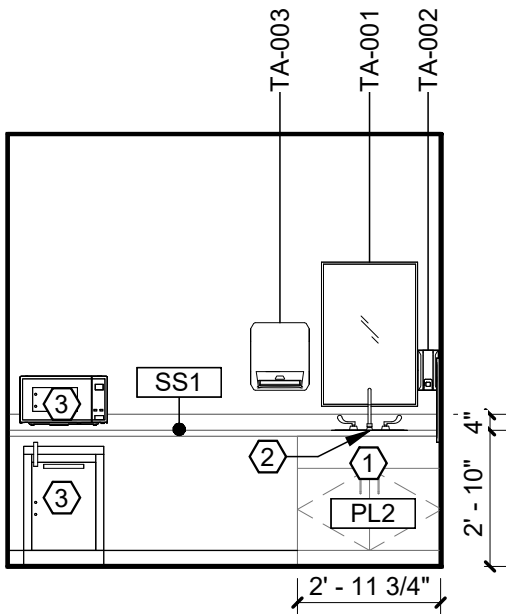


3 FAMILY CARE ROOM 134 - NORTH  
A707 1/4" = 1'-0"

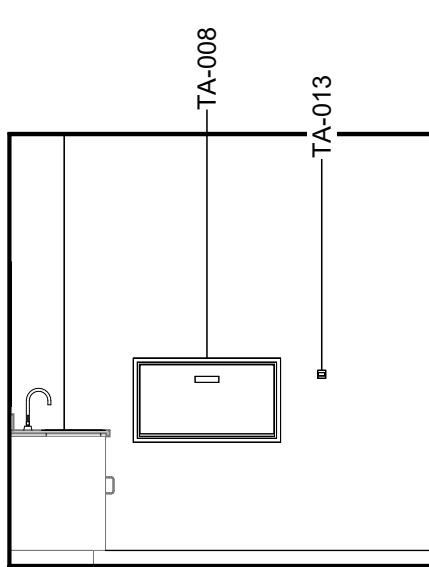


4 FAMILY CARE ROOM 134 - EAST  
A707 1/4" = 1'-0"

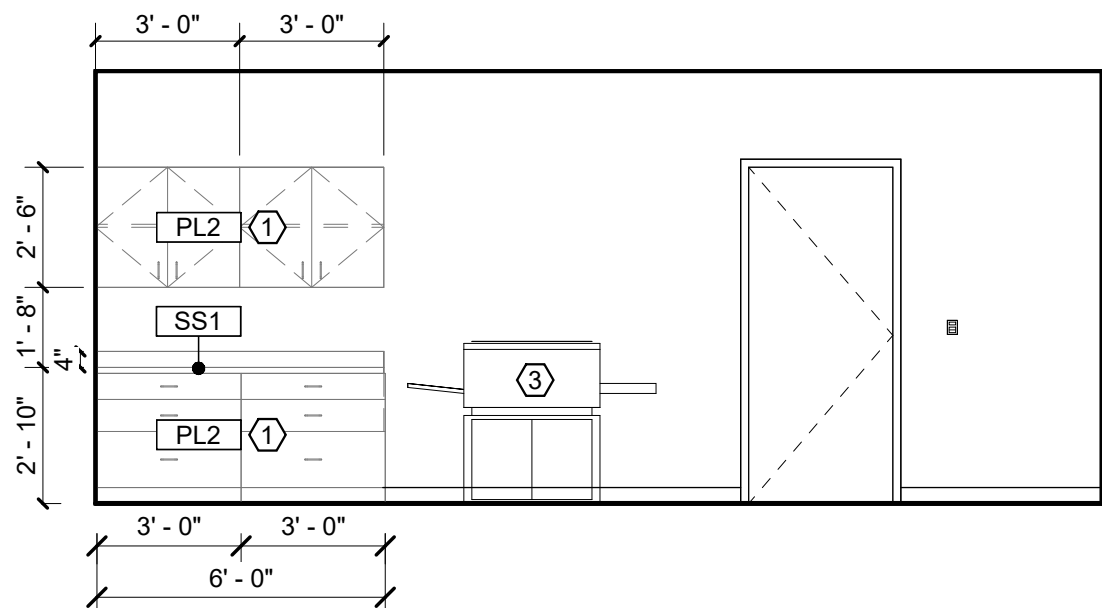


5 ADMIN SUPPORT 119 - EAST  
A707 1/4" = 1'-0"

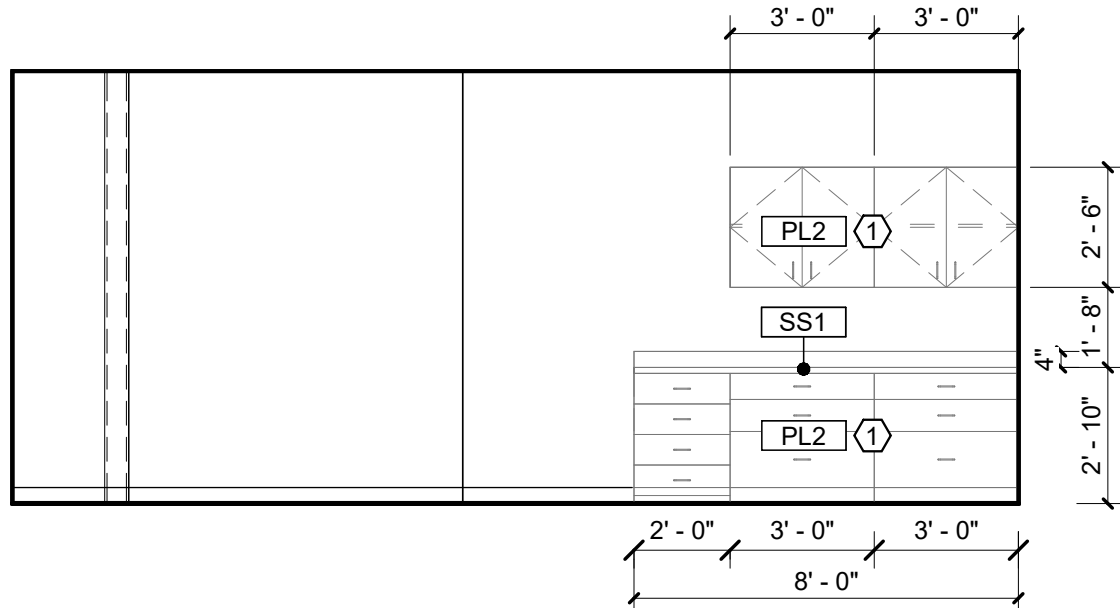


6 ADMIN SUPPORT 119 - WEST  
A707 1/4" = 1'-0"

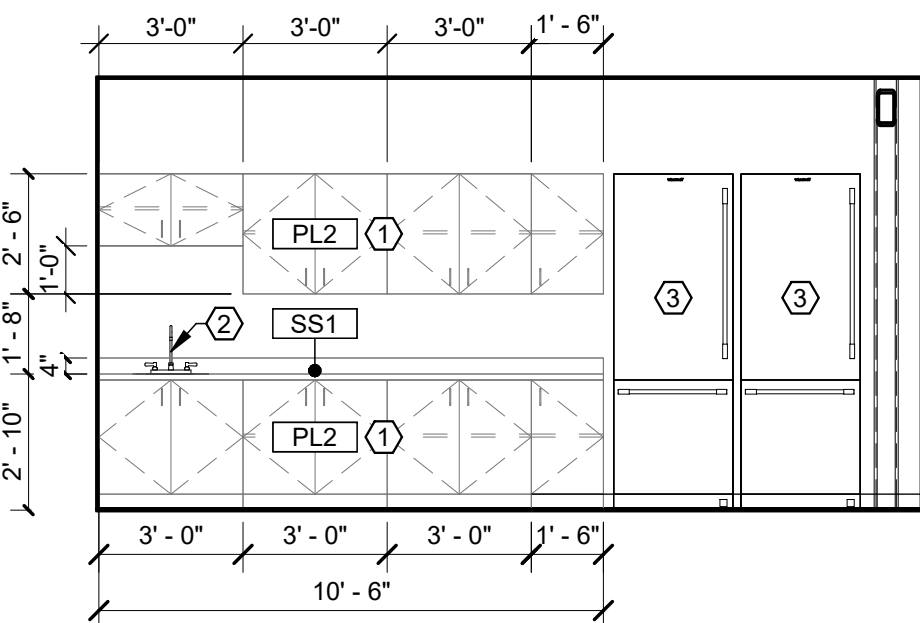

7 FACULTY GATHERING 136 - WEST  
A707 1/4" = 1'-0"

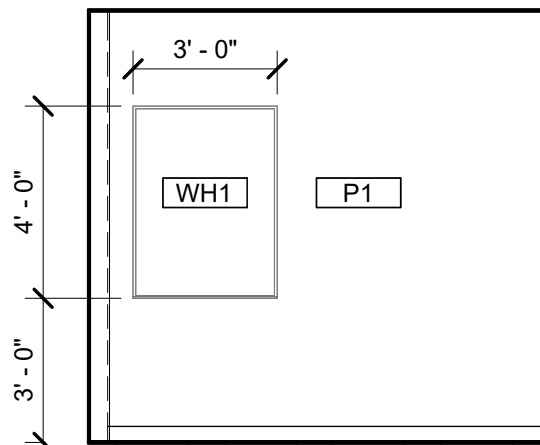

8 COOP WORKROOM 201 - NORTH  
A707 1/4" = 1'-0"

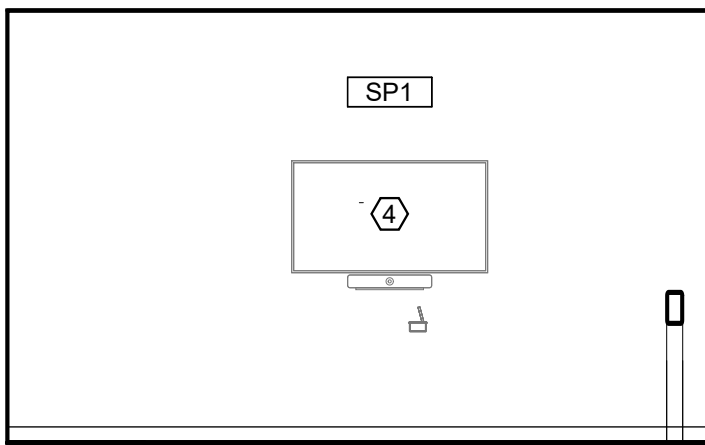

9 COOP WORKROOM 201 - EAST  
A707 1/4" = 1'-0"

GENERAL INTERIOR ELEVATION NOTES

- A. SEE A701 FOR TOILET AND LAV ACCESSORY SCHEDULE.  
B. SEE A503 FOR MATERIAL/FINISH ABBREVIATION LIST.  
C. PAINT ALL EXPOSED STRUCTURAL STEEL COLUMNS, CROSS BRACING, ETC. WITH 'P1' SEMI-GLOSS FINISH. UNLESS NOTED OTHERWISE.

# KEYNOTES


1. MODULAR CASEWORK VENDOR PROVIDED, VENDOR INSTALLED. SEE SHEET A801 AND MATERIAL FINISH LIST FOR PRODUCT SPECIFICATIONS.  
2. FAUCET BY GC/PLUMBING SUB. COORDINATE WITH MODULAR CASEWORK VENDOR FOR INSTALLATION DIMENSIONS.  
3. EQUIPMENT NIC. REFER TO ELECTRICAL AND MECHANICAL PLANS FOR CONNECTIONS AND HEAT LOADS.  
4. AV MONITOR. REFER TO AV DRAWINGS FOR MOUNTING HEIGHTS.  
5. OMIT COUNTERTOP BACKSPLASH AT 'TW#' LOCATIONS.  
6. TR10 AT ALL EXPOSED TILE OUTSIDE CORNERS.



MARK & ROBYN JONES COLLEGE  
OF NURSING - MISSOULA  
MONTANA STATE UNIVERSITY

Cushing  
Terrell  
co ARCHITECTS

|              |             |          |
|--------------|-------------|----------|
| DRAWN BY:    |             | LD       |
| REVIEWED BY: |             | MH       |
| REV.         | DESCRIPTION | DATE     |
| A            | Addendum 1  | 24.06.14 |
|              |             |          |
|              |             |          |
|              |             |          |

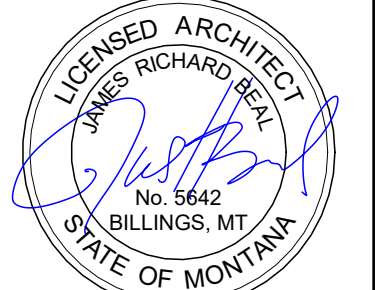

PPA#21-0171  
A/E#: 2022-02-09-05

SHEET TITLE  
INTERIOR ELEVATIONS


SHEET  
A707

DATE  
05.15.2024




# MATERIALS LIST - BASIS OF DESIGN

| ITEM NO         | PRODUCT TYPE                       | MANUFACTURER                     | DESCRIPTION                                                                                                   | COLOR                                                               | SIZE                                                                | NOTES                                                                                                                                                                                                          | Sustainability Notes                            |
|-----------------|------------------------------------|----------------------------------|---------------------------------------------------------------------------------------------------------------|---------------------------------------------------------------------|---------------------------------------------------------------------|----------------------------------------------------------------------------------------------------------------------------------------------------------------------------------------------------------------|-------------------------------------------------|
| BASE            |                                    |                                  |                                                                                                               |                                                                     |                                                                     |                                                                                                                                                                                                                |                                                 |
| CB1             | COVE BASE                          | SCHLUTER SYSTEMS                 | DILEX-AHK COVE BASE                                                                                           | STAINLESS STEEL                                                     | GC TO CONFIRM SIZE WITH TILE ASSEMBLY                               | TO BE INSTALLED WITH LATICRETE SPECTRALOCK EPOXY GROUT COLOR 78 STERLING SILVER. TO BE USED WITH SCHLUTER UNCOUPLING MEMBRANE AND EXPANSION JOINTS AS RECOMMENDED. SEE ARCHITECTURAL DETAIL.                   | RECYCLED CONTENT, NON-EMITTING SOURCE OF VOCs   |
| RB1             | RESILIENT BASE                     | JOHNSONITE                       | MILLWORK PROFILE MONUMENT                                                                                     | PEWTER, GC                                                          | 4"HIGH                                                              | MITER CORNER<br>ROLLED GOODS                                                                                                                                                                                   | EPD, FLOORSORE, CRADLE TO GATE                  |
| RB2             | RESILIENT BASE                     | JOHNSONITE                       | THERMOSET THERMOPLASTIC RUBBER COVE BASE                                                                      | PEWTER, GC                                                          | 4"HIGH                                                              |                                                                                                                                                                                                                | EPD, FLOORSORE, CRADLE TO GATE                  |
| CEILING         |                                    |                                  |                                                                                                               |                                                                     |                                                                     |                                                                                                                                                                                                                |                                                 |
| AC1             | ACOUSTIC CEILING                   | ARMSTRONG                        | CALLA MINERAL FIBER                                                                                           | WHITE                                                               | 2X2GRID, PRELUDE XL 15/16 SUSPENSION SYSTEM IN COLOR STANDARD WHITE | -                                                                                                                                                                                                              | EPD, HPD, DECLARE, GREENGUARD                   |
| AC3             | ACOUSTIC CEILING                   | FSORB                            | FSORB ACOUSTIC PANELING                                                                                       | WHITE                                                               | 2X2GRID, PRELUDE XL 15/16 SUSPENSION SYSTEM IN COLOR BLACK          | SEE RCPS. COORDINATE WITH MEP FIXTURES                                                                                                                                                                         | EPD, HPD, DECLARE, GREENGUARD                   |
| AC4             | ACOUSTIC CEILING                   | ARMSTRONG                        | CALLA MINERAL FIBER                                                                                           | BLACK                                                               |                                                                     | CONTROL ROOMS ONLY. SEE RCPS.COORDINATE WITH MEP FIXTURES                                                                                                                                                      | EPD, HPD, DECLARE, GREENGUARD                   |
| AL              | ALUMINUM CEILING                   | LONGBOARD                        | ENDURA LINEAR DIRECT MOUNT CEILING. 6INCH V GROOVE PLANK.                                                     | BEECHWOOD                                                           | -                                                                   | SEE RCPS.                                                                                                                                                                                                      | EPD                                             |
| ALP             | ALUMINUM CEILING                   | LONGBOARD                        | ENDURA LINEAR DIRECT MOUNT CEILING. 6INCH V GROOVE PERFORATED PLANK. SOUNDTEX ACOUSTIC LINER                  | BEECHWOOD, SOUNDTEX BLACK                                           | -                                                                   | SEE RCPS. COORDINATE WITH MEP FIXTURES                                                                                                                                                                         | EPD                                             |
| BF1             | BAFFLES                            | LONGBOARD                        | DAUNTLESS BAFFLE CEILING SYSTEM                                                                               | BEECHWOOD                                                           | 6" HIGH BAFFLE                                                      | SEE RCPS. COORDINATE WITH MEP FIXTURES                                                                                                                                                                         | EPD                                             |
| FLOOR           |                                    |                                  |                                                                                                               |                                                                     |                                                                     |                                                                                                                                                                                                                |                                                 |
| CP1             | CARPET TILE                        | MILLIKEN                         | COLLECTION: LOW COUNTRY. PATTERN: SALT MARSH                                                                  | SLM13 FRIPP                                                         | 9.85"X39.4"                                                         | 33% OFFSET ASHLAR INSTALLATION                                                                                                                                                                                 | EPD, DECLARE, C2C                               |
| CP2             | CARPET TILE                        | MILLIKEN                         | COLLECTION: LOW COUNTRY. PATTERN: SEA RISE                                                                    | SRS196-13 INDIGO PLANT                                              | 9.85"X39.4"                                                         | 33% OFFSET ASHLAR INSTALLATION                                                                                                                                                                                 | EPD, DECLARE, C2C                               |
| CP3             | CARPET TILE                        | MILLIKEN                         | COLLECTION: LOW COUNTRY. PATTERN: WATERWAY                                                                    | WAT196-13 INDIGO PLANT                                              | 9.85"X39.4"                                                         | 33% OFFSET ASHLAR INSTALLATION                                                                                                                                                                                 | EPD, DECLARE, C2C                               |
| EM1             | ENTRY WALK OFF CARPET              | MILLIKEN                         | OBEX BAR TRANSITIONS RECESSED                                                                                 | DARK GREY                                                           | 10.87"X39.37"                                                       | COORDINATE WITH STRUCTURE                                                                                                                                                                                      | INDOOR AIR ADVANTAGE GOLD                       |
| EM2             | ENTRY WALK OFF CARPET              | MILLIKEN                         | WALK OFF OBEX CARPET TILE                                                                                     | CUT FIZZ, DARK GREY                                                 | 19.68X19.68                                                         | -                                                                                                                                                                                                              | INDOOR AIR ADVANTAGE GOLD                       |
| ES1             | ELECTRIC STATIC FLOOR              | STATICWORX                       | AMERIWORX CLASSIC EDS SOLID VINYL TILE                                                                        | ADIRONDACK RIDGE                                                    | 12X12                                                               | COORDINATE GROUNDING FOR COPPER WIRE WITH ELECTRICAL                                                                                                                                                           | FLOORSORE, RECYCLED CONTENT                     |
| RT1             | RESILIENT FLOORING                 | TARKEIT                          | COLLECTION: COLOR WEAVE                                                                                       | THUNDER                                                             | 18X18                                                               | GLUE DOWN                                                                                                                                                                                                      | EPD, FLOORSORE, CRADLE TO GATE                  |
| SC1             | SEALED CONCRETE                    | SHERWIN WILLIAMS                 | H&C CLARISHIELD WATER-BASED CONCRETE SEALER                                                                   | NATURAL LOOK                                                        | -                                                                   | -                                                                                                                                                                                                              | -                                               |
| TF1             | TILE FLOOR                         | EMSER                            | MOOD                                                                                                          | RIVER GRAY                                                          | 12X23                                                               | TO BE INSTALLED WITH LATICRETE SPECTRALOCK EPOXY GROUT COLOR 78 STERLING SILVER. TO BE USED WITH SCHLUTER UNCOUPLING MEMBRANE AND EXPANSION JOINTS AS RECOMMENDED                                              | HPD, RED LIST FREE                              |
| TF2             | TILE FLOOR                         | FLORIDA TILE                     | CANAL STREET COLLECTION                                                                                       | BLACK BAYOU                                                         | 24X48                                                               | TO BE INSTALLED WITH LATICRETE SPECTRALOCK EPOXY GROUT COLOR 78 STERLING SILVER. TO BE USED WITH SCHLUTER UNCOUPLING MEMBRANE AND EXPANSION JOINTS AS RECOMMENDED                                              | EPD, HPD, GREENGUARD                            |
| MILLWORK        |                                    |                                  |                                                                                                               |                                                                     |                                                                     |                                                                                                                                                                                                                |                                                 |
| FB1             | FABRIC UPHOLSTERY                  | ANZEA                            | KAPOW COLLECTION                                                                                              | SWISH                                                               | SEE ELEVATIONS AND RENDERING FOR DESIGN INTENT                      | SEAT CUSHION. GC TO PROVIDE SHOP DRAWINGS FOR FINAL APPROVAL                                                                                                                                                   | HPD, REDLIST FREE                               |
| FB2             | FABRIC UPHOLSTERY                  | DESIGNTEX                        | TACK CLOTH                                                                                                    | MARINER 3749-404                                                    | SEE ELEVATIONS AND RENDERING FOR DESIGN INTENT                      | BACK CUSHION. GC TO PROVIDE SHOP DRAWINGS FOR FINAL APPROVAL                                                                                                                                                   | HPD                                             |
| HD1             | HARDWARE: MODULAR CASEWORK         | CAROLINA MILEMARKER              | GRIP CABINET PULL, ADA COMPLIANT                                                                              | SATIN NICKEL                                                        | -                                                                   | TO BE INSTALLED WITH MODULAR CASEWORK. CONTACT: Jared.B@cdcollective.com WITH CONTRACT DESIGN                                                                                                                  | -                                               |
| PL1             | PLASTIC LAMINATE: CUSTOM MILLWORK  | WILSONART                        | HPL BLONDE ECHO LINEARITY FINISH                                                                              | 7939K-18                                                            | -                                                                   | ALL MILLWORK SURFACES TO BE MATCHING WOOD GRAIN LOOK, NO MELAMINE                                                                                                                                              | HPD, INDOOR AIR ADVANTAGE GOLD, GREENGUARD GOLD |
| PL2             | PLASTIC LAMINATE: MODULAR CASEWORK | CAROLINA-OFS                     | HPL LINEN (WOOD LOOK)                                                                                         | OFS STANDARD LAMINATE                                               | -                                                                   | ALL MILLWORK SURFACES TO BE MATCHING WOOD GRAIN LOOK, NO MELAMINE, CONTACT: Jared.B@cdcollective.com WITH CONTRACT DESIGN                                                                                      | INDOOR AIR ADVANTAGE GOLD                       |
| PL3             | PLASTIC LAMINATE: CUSTOM MILLWORK  | WILSONART                        | HPL LINEN (WHITE)                                                                                             | D427-60 MATTE FINISH                                                | -                                                                   | ALL MILLWORK SURFACES TO BE MATCHING WOOD GRAIN LOOK, NO MELAMINE                                                                                                                                              | HPD, INDOOR AIR ADVANTAGE GOLD, GREENGUARD GOLD |
| QZ1             | QUARTZ SURFACE                     | EVERO QUARTZ BY BRADLEY          | GEO SERIES                                                                                                    | ANDORRA                                                             | SEE PLUMBING SPECIFICATIONS                                         | RESTROOM TROUGH SINK. SEE PLUMBING FOR DETAILS                                                                                                                                                                 | GREENGUARD GOLD                                 |
| SS1             | SOLID SURFACE: MODULAR CASEWORK    | CAROLINA-OFS                     | LIVINGSTONE SURFACES, SNOWFALL                                                                                | L213                                                                | -                                                                   | MITERED CORNERS, EASED EDGES, CONTACT: Jared.B@cdcollective.com WITH CONTRACT DESIGN                                                                                                                           | HPD, GREENGUARD                                 |
| SS2             | SOLID SURFACE: MODULAR CASEWORK    | GC/CUSTOM MILLWORKER TO PROVIDE  | LIVINGSTONE SURFACES, SNOWFALL                                                                                | L213                                                                | -                                                                   | MITERED CORNERS, EASED EDGES, INSTALL WITH IN-WALL CONCEALED BRACKETS                                                                                                                                          | HPD, GREENGUARD                                 |
| WALL            |                                    |                                  |                                                                                                               |                                                                     |                                                                     |                                                                                                                                                                                                                |                                                 |
| AC2             | ACOUSTIC ARCHITECTURAL ELEMENT     | TURF DESIGNS                     | ARCHITECTURAL ELEMENT: PATTERN FRACTAL, CLASS A                                                               | SHELL HOUSING COLOR: DAMASCAS 09, INSERTS: LIGHT 04 GREY            | MODULAR CLOUD, 36"x36"                                              | SEE RCP, DETAILS, AND ELEVATIONS FOR DESIGN INTENT. COORDINATE WITH MECHANICAL, ELECTRICAL AND STRUCTURAL SYSTEMS. INSTALLER TO USE RECOMMENDED THREADED ROD CONNECTION. CONTACT: jordan@absolute-resource.com | HPD, DECLARE                                    |
| AP1             | ACOUSTIC PRODUCTS                  | KIREI                            | SOLID WALL PANEL                                                                                              | 442 GREY                                                            | SHEET SIZE 9'X4'X1/2"THICK                                          | Z-CLIP MOUNT. SEE ELEVATIONS FOR DESIGN INTENT AND SIZING                                                                                                                                                      | HPD                                             |
| AP1.1           | ACOUSTIC PRODUCTS                  | KIREI                            | SOLID WALL PANEL                                                                                              | 660 CORONET                                                         | SHEET SIZE 9'X4'X1/2"THICK                                          | Z-CLIP MOUNT. SEE ELEVATIONS FOR DESIGN INTENT AND SIZING                                                                                                                                                      | HPD                                             |
| AP2             | ACOUSTIC PRODUCTS                  | MOMENTUM TEXTILES                | NUFELT BOWTIE ACOUSTIC WALLCOVERING. PATTERN TO RUN VERTICAL, MATCH SEAMS.                                    | WISHFUL THINKING                                                    | 0.12" THICK X 63" WIDE ROLL                                         | ADHESIVE MOUNT. PROVIDE METAL TRANSITION ON ALL EXPOSED EDGES.GC TO PROVIDE SHOP DRAWINGS FOR FINAL APPROVAL                                                                                                   | HPD, GREENGUARD, RECYCLED CONTENT               |
| AP3             | ACOUSTIC PRODUCTS                  | KIREI                            | GROOVY 3.0 PANELS                                                                                             | 442 GREY                                                            | SHEET SIZE: 110 X 44 NOOKS                                          | SEE ELEVATIONS AND DETAILS FOR DESIGN INTENT. COORDINATE FITTING WITH ELECTRICAL AND FIRE PROTECTION. TO BE USED WITH TRANSITION EDGE. #LVT908BRZ                                                              | EPD, HPD, DECLARE, RECYCLED CONTENT             |
| AP4             | ACOUSTIC PRODUCTS                  | MDC ZINTRA                       | ETCH TETRIS                                                                                                   | PANEL COLOR: CADET, REVEAL COLOR: SUNSHINE                          | SHEET SIZE 9'X4'X1/2"THICK                                          | SEE ELEVATIONS AND DETAILS FOR DESIGN INTENT. COORDINATE FITTING WITH ELECTRICAL AND FIRE PROTECTION                                                                                                           | REDLIST FREE, RECYCLED CONTENT                  |
| AP4.1           | ACOUSTIC PRODUCTS                  | MDC ZINTRA                       | ETCH TETRIS                                                                                                   | PANEL COLOR: PEWTER, REVEAL COLOR: SLATE                            | SHEET SIZE 9'X4'X1/2"THICK                                          | SEE ELEVATIONS AND DETAILS FOR DESIGN INTENT. COORDINATE FITTING WITH ELECTRICAL AND FIRE PROTECTION                                                                                                           | REDLIST FREE, RECYCLED CONTENT                  |
| CC1             | CUBICLE CURTAIN                    | KNOLL                            | FABRIC PATTERN SIGNAL, MESH: WHITE, ACCESSORIES AND TRACK PROVIDED BY GC                                      | FABRIC: COASTLINE, MESH: WHITE, GROMMETS:WHITE OR CLEAR, ANNOIDIZED | SEE ELEVATIONS AND RENDERING FOR DESIGN INTENT                      | OMBRE STRIPES TO RUN HORIZONTAL. GC TO PROVIDE SHOP DRAWINGS FOR FINAL APPROVAL. SEE RCP AND DETAILS FOR HANGING STRUCTURE                                                                                     | FREE OF INTENTIONALLY ADDED PFAS                |
| LK1             | LOCKERS                            | CAROLINA MILEMARKER              | 2 TIER STORAGE LOCKER. BATTERY OPERATED LOCKS. PULL: RECESSED. INCLUDE 2 PRONG COAT HOOKS                     | HPL LINEN (WOOD LOOK) PULL: STAIN NICKLE                            | SEE ELEVATIONS                                                      | -                                                                                                                                                                                                              | INDOOR AIR ADVANTAGE GOLD                       |
| LK1.1           | LOCKERS                            | CAROLINA MILEMARKER              | OPEN CUBBIES                                                                                                  | HPL LINEN (WOOD LOOK) PULL: STAIN NICKLE                            | SEE ELEVATIONS                                                      | CONFIRM QTY AND SIZE OF OPEN CUBBIES WITH CLIENT PRIOR TO APPROVAL                                                                                                                                             | INDOOR AIR ADVANTAGE GOLD                       |
| WF1             | PRIVACY WINDOW FILM                | TAKEFORM                         | DUAL FADE FROSTED CUSTOM PATTERN                                                                              | FROSTED                                                             | 60 INCH BAND TO START 2FT FROM BOTTOM OF DOOR FRAME                 | GC TO PROVIDE SHOP DRAWINGS FOR APPROVAL. GC TO PROVIDE MOCKUP PRIOR TO ORDERING FOR OWNER APPROVAL                                                                                                            | -                                               |
| WH1             | WHITEBOARD                         | CLARUS                           | FLOAT : BACKPAINTED MAGNETIC GLASSBOARD                                                                       | WHITE                                                               | SEE ELEVATIONS                                                      | INCLUDE MARKERS, HANGERS AND ALL ACCESSORIES                                                                                                                                                                   | EPD, DECLARE                                    |
| WS1             | WINDOW SHADES                      | LUTRON                           | MOTORIZED ROLLER SHADES: CONTRACT ROLLER QS WIRELESS                                                          | FASCIA: TBD, FABRIC: 1% OPEN, COLOR: MSCREEN CHARCOAL/GREY          | FIELD VERIFY ON SITE                                                | COORDINATE WITH ELECTRICAL                                                                                                                                                                                     | -                                               |
| WS2             | WINDOW SHADES                      | LUTRON                           | MANUAL ROLLER SHADES: CONTRACT ROLLER MANUAL                                                                  | FASCIA: TBD, FABRIC: 1% OPEN, COLOR:MSCREEN CHARCOAL/GREY           | FIELD VERIFY ON SITE                                                | -                                                                                                                                                                                                              | -                                               |
| WS3             | WINDOW SHADES                      | LUTRON                           | MANUAL DUAL ROLLER SHADE: CONTRACT ROLLER MANUAL                                                              | FASCIA: TBD, FABRIC: 1% OPEN WEAVE, COLOR: TBD                      | FIELD VERIFY ON SITE                                                | -                                                                                                                                                                                                              | -                                               |
| TRANSITIONS     |                                    |                                  |                                                                                                               |                                                                     |                                                                     |                                                                                                                                                                                                                |                                                 |
| TR1             | TRANSITION PROFILE                 | SCHLUTER SYSTEMS                 | CARPET TO TILE: SCHIENE                                                                                       | STAINLESS STEEL                                                     | GC TO CONFIRM SIZES WITH MATERIAL THICKNESS                         | SEE ARCHITECTURAL DETAIL.                                                                                                                                                                                      | RECYCLED CONTENT, NON-EMITTING SOURCE OF VOCs   |
| TR2             | TRANSITION PROFILE                 | FUTURA TRANSITIONS               | CARPET TO RESILIENT: CARPET TO LVT PROFILE                                                                    | ETCHED ALUMINUM                                                     | GC TO CONFIRM SIZES WITH MATERIAL THICKNESS                         | SEE ARCHITECTURAL DETAIL.                                                                                                                                                                                      | REACH / ROHS COMPLIANT                          |
| TR3             | TRANSITION PROFILE                 | FUTURA TRANSITIONS               | CARPET TO CONCRETE: DELUXE BINDER BAR                                                                         | ETCHED ALUMINUM                                                     | GC TO CONFIRM SIZES WITH MATERIAL THICKNESS                         | SEE ARCHITECTURAL DETAIL.                                                                                                                                                                                      | REACH / ROHS COMPLIANT                          |
| TR4             | TRANSITION PROFILE                 | SCHLUTER SYSTEMS                 | RESILIENT TO TILE: RENO-U                                                                                     | STAINLESS STEEL                                                     | GC TO CONFIRM SIZES WITH MATERIAL THICKNESS                         | SEE ARCHITECTURAL DETAIL.                                                                                                                                                                                      | RECYCLED CONTENT, NON-EMITTING SOURCE OF VOCs   |
| TR5             | TRANSITION PROFILE                 | FUTURA TRANSITIONS               | RESILIENT TO CONCRETE: COVING CAP                                                                             | ETCHED ALUMINUM                                                     | GC TO CONFIRM SIZES WITH MATERIAL THICKNESS                         | SEE ARCHITECTURAL DETAIL.                                                                                                                                                                                      | REACH / ROHS COMPLIANT                          |
| TR6             | TRANSITION PROFILE                 | FUTURA TRANSITIONS               | TILE TO CONCRETE: CERAMIC REDUCER EDGETEK U SHAPED                                                            | ETCHED ALUMINUM                                                     | GC TO CONFIRM SIZES WITH MATERIAL THICKNESS                         | SEE ARCHITECTURAL DETAIL.                                                                                                                                                                                      | REACH / ROHS COMPLIANT                          |
| TR7             | TRANSITION PROFILE                 | FUTURA TRANSITIONS               | FELT METAL EDGE FOR AP3, AP4                                                                                  | #LVT 908 EBLK                                                       | GC TO CONFIRM SIZES WITH MATERIAL THICKNESS                         | -                                                                                                                                                                                                              | REACH / ROHS COMPLIANT                          |
| TR8             | TRANSITION PROFILE                 | FUTURA TRANSITIONS               | FELT METAL EDGE FOR AP2: BEVEL CAP                                                                            | 4MM, #LVT 906 EBLK                                                  | GC TO CONFIRM SIZES WITH MATERIAL THICKNESS                         | -                                                                                                                                                                                                              | REACH / ROHS COMPLIANT                          |
| TR9             | TRANSITION PROFILE                 | TBD                              | WALL PROTECTION EDGE -LABS                                                                                    | STAINLESS STEEL                                                     | GC TO CONFIRM SIZES WITH MATERIAL THICKNESS                         | -                                                                                                                                                                                                              | -                                               |
| TR10            | TRANSITION PROFILE                 | SCHLUTER SYSTEMS                 | WALL TILE EDGE + CORNERS: FINEC-SQ - ALL EXPOSED EDGES, OUTSIDE CORNERS                                       | STAINLESS STEEL                                                     | GC TO CONFIRM SIZES WITH MATERIAL THICKNESS                         | -                                                                                                                                                                                                              | RECYCLED CONTENT, NON-EMITTING SOURCE OF VOCs   |
| TR11            | TRANSITION PROFILE                 | FUTURA TRANSITIONS               | VENEER PLYWOOD EDGE - NOOKS: COVING CAP 1/8" OR 3/32"                                                         | EBLK                                                                | GC TO CONFIRM SIZES WITH MATERIAL THICKNESS                         | -                                                                                                                                                                                                              | REACH / ROHS COMPLIANT                          |
| TR12            | TRANSITION PROFILE                 | VARIES                           | STAIR TREAD TRANSITION                                                                                        | STAINLESS STEEL                                                     | GC TO CONFIRM SIZES WITH MATERIAL THICKNESS                         | -                                                                                                                                                                                                              | -                                               |
| WALL            |                                    |                                  |                                                                                                               |                                                                     |                                                                     |                                                                                                                                                                                                                |                                                 |
| EP1             | EPOXY PAINT                        | SHERWIN WILLIAMS                 | PRO-INDUSTRIAL WATERBASED CATALYZED EPOXY                                                                     | SW7566 WESTHIGHLAND WHITE                                           | CEILINGS: FLAT FINISH, WALLS EG-SHEL FINISH                         | GC TO PROVIDE LOW/NO VOC PAINT                                                                                                                                                                                 | LOW/NO VOC                                      |
| EP2             | EPOXY PAINT                        | SHERWIN WILLIAMS                 | ZERO VOC HARMONY INTERIOR LATEX PAINT                                                                         | SW7609 GEORGIAN REVIVAL BLUE                                        | CEILINGS: FLAT FINISH, WALLS EG-SHEL FINISH                         | GC TO PROVIDE LOW/NO VOC PAINT                                                                                                                                                                                 | LOW/NO VOC                                      |
| P1              | PAINT                              | SHERWIN WILLIAMS                 | ZERO VOC HARMONY INTERIOR LATEX PAINT                                                                         | SW7566 WESTHIGHLAND WHITE                                           | CEILINGS: FLAT FINISH, WALLS EG-SHEL FINISH                         | GC TO PROVIDE LOW/NO VOC PAINT                                                                                                                                                                                 | LOW/NO VOC                                      |
| P2              | PAINT                              | SHERWIN WILLIAMS                 | ZERO VOC HARMONY INTERIOR LATEX PAINT                                                                         | SW7609 GEORGIAN REVIVAL BLUE                                        | CEILINGS: FLAT FINISH, WALLS EG-SHEL FINISH                         | GC TO PROVIDE LOW/NO VOC PAINT                                                                                                                                                                                 | LOW/NO VOC                                      |
| P3              | PAINT                              | SHERWIN WILLIAMS                 | ZERO VOC HARMONY INTERIOR LATEX PAINT                                                                         | SW7506 VAST SKY                                                     | CEILINGS: FLAT FINISH, WALLS EG-SHEL FINISH                         | GC TO PROVIDE LOW/NO VOC PAINT                                                                                                                                                                                 | LOW/NO VOC                                      |
| P4              | PAINT                              | SHERWIN WILLIAMS                 | ZERO VOC HARMONY INTERIOR LATEX PAINT                                                                         | SW7072 ONLINE                                                       | CEILINGS: FLAT FINISH, WALLS EG-SHEL FINISH                         | GC TO PROVIDE LOW/NO VOC PAINT                                                                                                                                                                                 | LOW/NO VOC                                      |
| P5              | PAINT                              | SHERWIN WILLIAMS                 | ZERO VOC HARMONY INTERIOR LATEX PAINT                                                                         | SW7075 WEB GRAY                                                     | CEILINGS: FLAT FINISH, WALLS EG-SHEL FINISH                         | GC TO PROVIDE LOW/NO VOC PAINT                                                                                                                                                                                 | LOW/NO VOC                                      |
| SP1             | SPECIALTY PAINT/COATING            | GC/ SIGNAGE VENDOR TO PROVIDE    | CUSTOM GRAPHIC ON TYPE III TERRALON VINYL                                                                     | CUSTOM IMAGERY                                                      | SEE ELEVATIONS AND RENDERING FOR DESIGN INTENT                      | WALLS RECEIVING GRAPHIC TO HAVE A LEVEL 5 GYP FINISH. PROVIDE MOCKUP TO DESIGNER FOR APPROVAL, GC/CT TO PROVIDE DESIGN INTENT                                                                                  | -                                               |
| TW1             | TILE WALL                          | EMSER                            | COUNCIL                                                                                                       | GRAY                                                                | 12X24                                                               | TO BE INSTALLED WITH LATICRETE SPECTRALOCK EPOXY GROUT COLOR 78 STERLING SILVER                                                                                                                                | HPD, RED LIST FREE                              |
| TW2             | TILE WALL                          | DALTILE                          | STAGECRAFT KALEIDOSCOPE                                                                                       | GALAXY 1469                                                         | 6X6                                                                 | TO BE INSTALLED WITH LATICRETE SPECTRALOCK EPOXY GROUT COLOR 78 STERLING SILVER                                                                                                                                | RECYCLED CONTENT                                |
| TW3             | TILE WALL                          | DALTILE                          | STAGECRAFT KALEIDOSCOPE                                                                                       | ARCTIC WHITE 0190                                                   | 6X6                                                                 | TO BE INSTALLED WITH LATICRETE SPECTRALOCK EPOXY GROUT COLOR 78 STERLING SILVER                                                                                                                                | RECYCLED CONTENT                                |
| WC1             | WALLCOVERING                       | P3TEC                            | STELLAR                                                                                                       | P3T-60128 WHITE OUT                                                 | 4' ROLL                                                             | INSTALL ABOVE WALL BASE. TO BE USED IN CONJUNCTION WITH MANUFACTURERS STANDARD TOP CAP AND MATCHING CORNER GUARDS. ARCHITECT TO SELECT COLOR FROM STANDARD RANGE.                                              | EPD,HPD                                         |
| WDW1            | WOOD WALL & SOFFIT                 | GC TO PROVIDE/ CUSTOM MILLWORKER | RIFT SAWN WHITE OAK, POLYURETHANE FINISH, TO MATCH ARCHITECTS SAMPLE IN SPECIES, STAIN, GRAINING, AND TEXTURE | GC TO PROVIDE A RANGE OF SAMPLES                                    | -                                                                   | SEE DETAILS, ELEVATIONS, AND SECTIONS FOR DESIGN INTENT                                                                                                                                                        | -                                               |
| WALL PROTECTION |                                    |                                  |                                                                                                               |                                                                     |                                                                     |                                                                                                                                                                                                                |                                                 |
| CG1             | CORNER GUARD                       | C.S. ACROVYN                     | SSM-20                                                                                                        | WHITE, SUEDE FINISH                                                 | 2" WINGS, FULL HEIGHT                                               | CG1 TO START AT TOP OF BASE.                                                                                                                                                                                   | EPD                                             |
| CH1             | CHAIR RAIL                         | C.S. ACROVYN                     | SCR-40 SURFACE MOUNTED                                                                                        | WHITE, SUEDE FINISH                                                 | 4"HIGH                                                              | SEE ELEVATIONS FOR DESIGN INTENT AND SIZING                                                                                                                                                                    | EPD                                             |
| FRP1            | FIBERGLASS REINFORCED PANEL        | MARLITE                          | STANDARD FRP                                                                                                  | WHITE, PEBBLE FINISH                                                | 4'X8'                                                               | FRP TO START AT TOP OF BASE                                                                                                                                                                                    | GREENGUARD GOLD                                 |
| WP1             | WALL PROTECTION                    | CONSTRUCTION SPECIALTIES         | ACROVYN WALL PROTECTION RIGID SHEET                                                                           | WHITE, SUEDE FINISH                                                 | 4'X8'                                                               | INSTALL ABOVE FINISHED FLOOR; WALL BASE TO BE INSTALLED ON TOP OF WP# PANEL.                                                                                                                                   | EPD, CRADLE TO CRADLE                           |

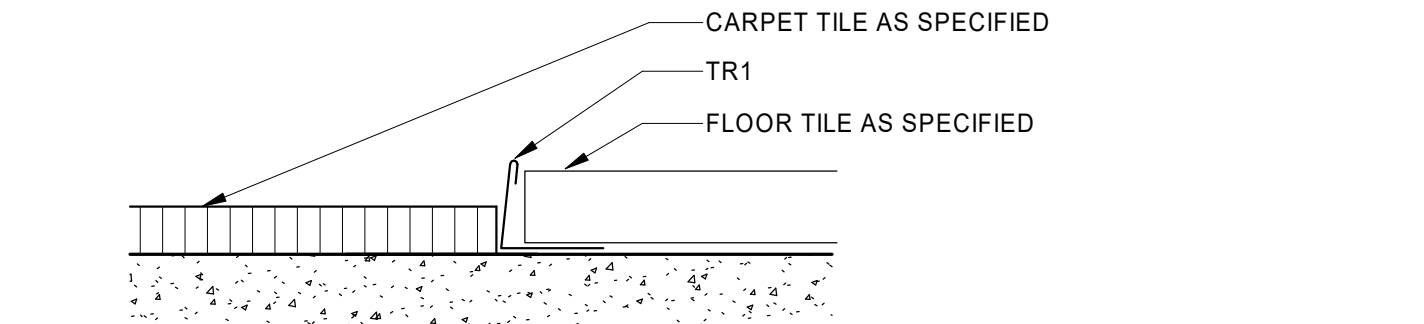


1  
A503  
12" = 1'-0"

## INTERIOR DETAIL - TR1 CARPET TO FLOOR TILE

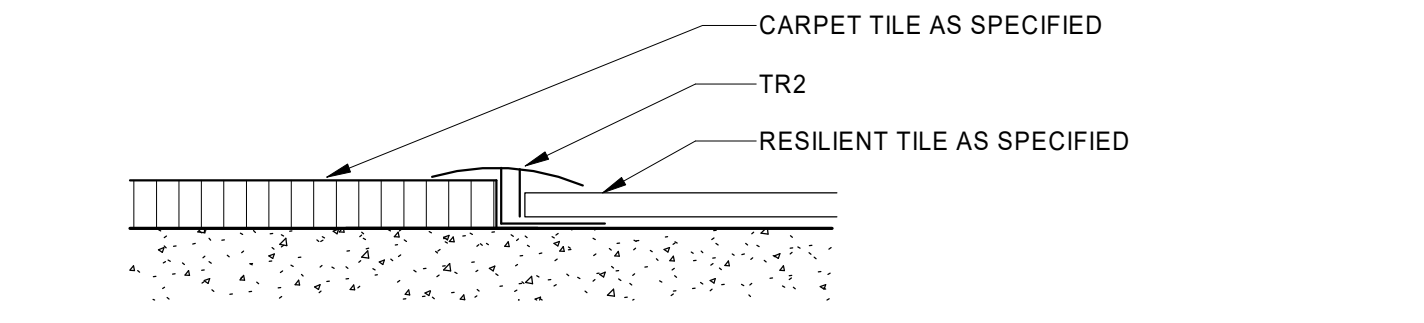


2  
A503  
12" = 1'-0"

## INTERIOR DETAIL - TR2 CARPET TO RESILIENT

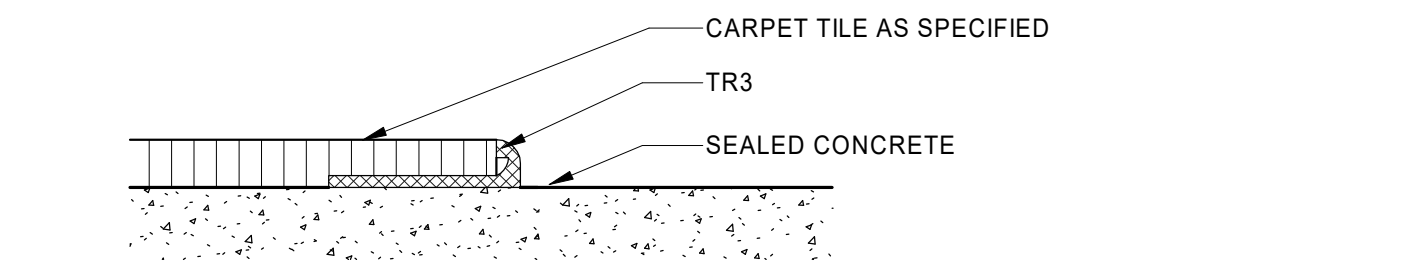


3  
A503  
12" = 1'-0"

## INTERIOR DETAIL - TR3 CARPET TO CONCRETE

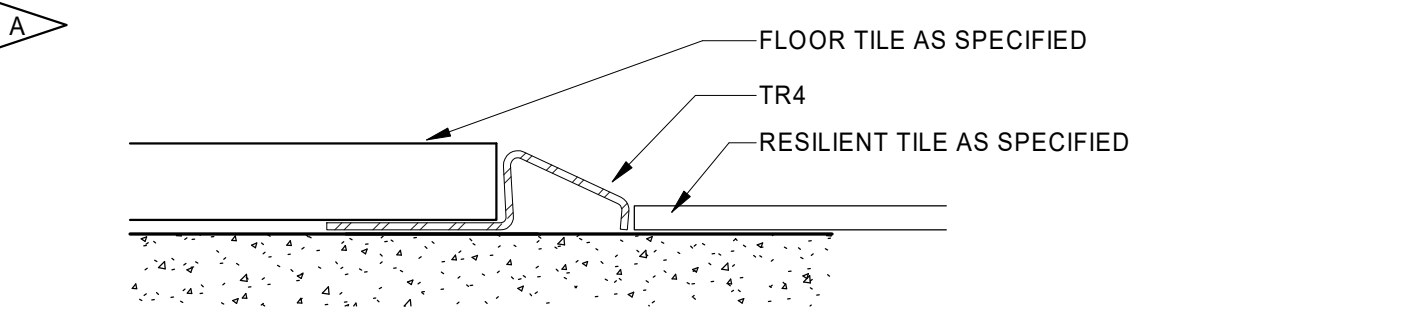


4  
A503  
12" = 1'-0"

## INTERIOR DETAIL - TR4 RESILIENT TO FLOOR TILE

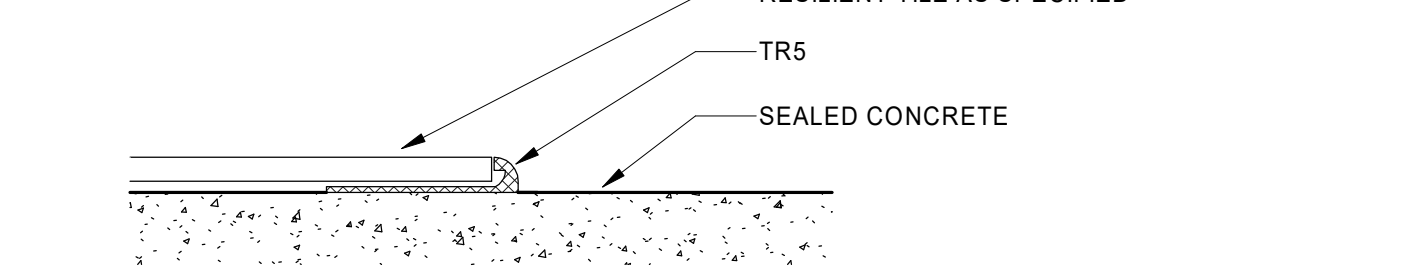


5  
A503  
12" = 1'-0"

## INTERIOR DETAIL - TR5 RESILIENT TO CONCRETE

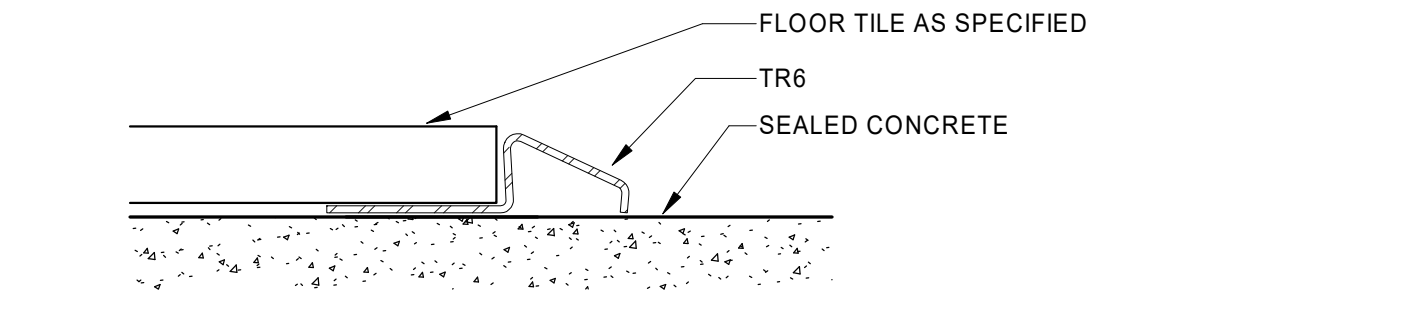


6  
A503  
12" = 1'-0"

## INTERIOR DETAIL - TR6 FLOOR TILE TO CONCRETE

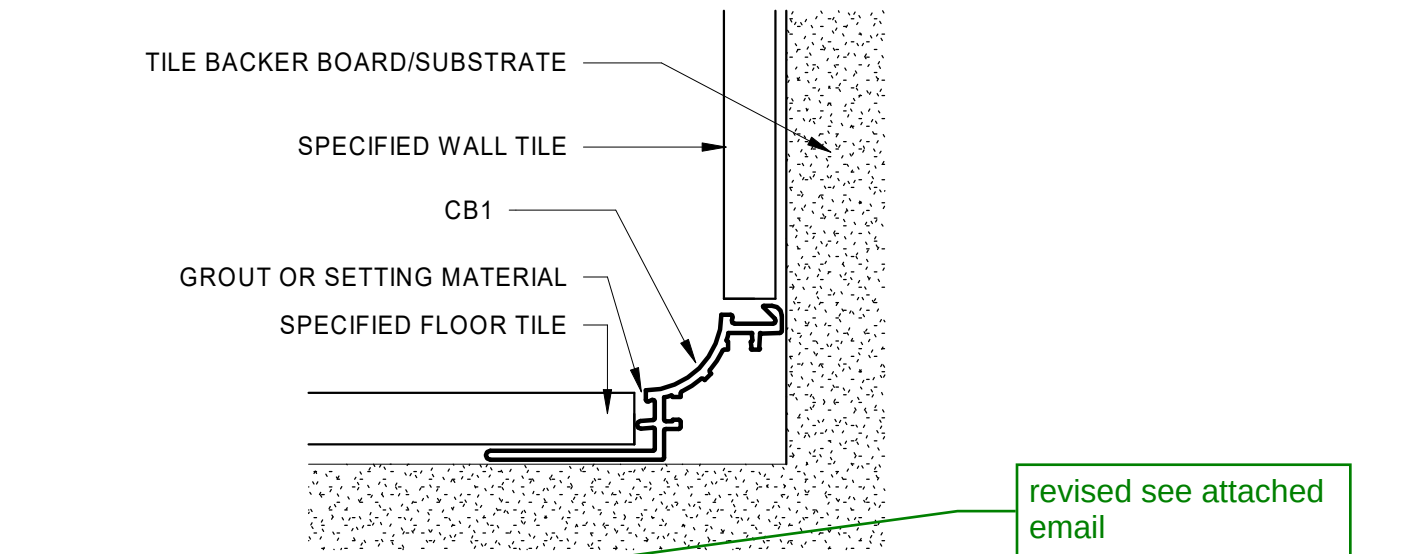

7  
A503  
12" = 1'-0"

## INTERIOR DETAIL - TILE COVE BASE

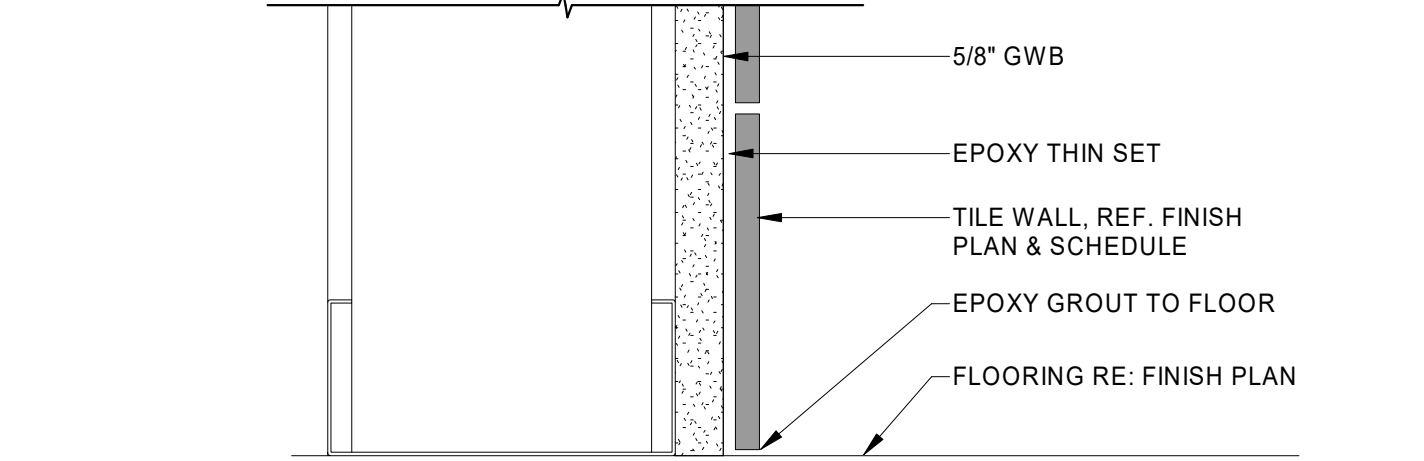

8  
A503  
6" = 1'-0"


## INTERIOR DETAIL - TILE WALL BASE



MARK & ROBYN JONES COLLEGE  
OF NURSING - MISSOULA  
MONTANA STATE UNIVERSITY

Cushing  
Terrell  
co ARCHITECTS

|              |             |          |
|--------------|-------------|----------|
| DRAWN BY:    |             | LD       |
| REVIEWED BY: |             | MH       |
| REV.         | DESCRIPTION | DATE     |
| A            | Addendum 1  | 24.06.14 |
| B            | Addendum 2  | 24.06.20 |
|              |             |          |
|              |             |          |
|              |             |          |

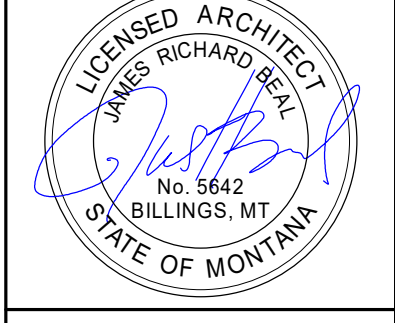

PPA#21-0171  
A/E#:  
2022-02-09-05  
SHEET TITLE  
INTERIOR MATERIALS  
LIST AND DETAILS  
SHEET  
A503  
DATE  
05.15.2024